



CONSTRUCTION DRAWING SET
VIVALDY RESIDENCE
21/11/2025

Vivaldy Residence, Summarecon Serpong
INTERIOR ARCHITECTURAL DESIGN DRAWING SET



Serpong Utara, Tangerang Selatan
+62812 8603 4050
duende.designandbuild@gmail.com

CLIENT :

Mrs. S

CONTRACTOR :

PROJECT :
Vivaldy ResidenceLOCATION :
Summarecon Serpong, Tangerang

DRAWING TITLE :

Drawing Schedule

NO.	DRAWING NO.	TITLE	SCALE	DATE
				2025/11/21
01	A0 - 00	COVER PAGE	N.T.S	○
02	A0 - 01	DRAWING SCHEDULE	N.T.S	○
03	A0 - 02	NOTES, SYMBOL & LEGENDS	N.T.S	○
04	A0 - 03	MATERIAL LIST	N.T.S	○
05	PR1 - 01	PERSPECTIVE LINING ROOM & DINING ROOM	N.T.S	○
06	PR1 - 02	PERSPECTIVE KITCHEN	N.T.S	○
07	PR1 - 03	PERSPECTIVE MASTER BEDROOM	N.T.S	○
08	PR1 - 04	PERSPECTIVE MASTER BEDROOM	N.T.S	○
09	PR1 - 05	PERSPECTIVE WALK IN CLOSET	N.T.S	○
10	PR1 - 06	PERSPECTIVE WALK IN CLOSET	N.T.S	○
11	A1 - 01	LAYOUT INTERIOR	1 : 75	○
12	A1 - 02	LAYOUT ELECTRICAL	1 : 75	○
13	LD1 - 01	LAYOUT LIVING & DINING ROOM	1 : 25	○
14	LD1 - 02	ELEVATION A LIVING & DINING ROOM	1 : 25	○
15	LD1 - 03	SECTION 1 LIVING & DINING ROOM	1 : 25	○
16	LD1 - 04	SECTION 2 & 3 LIVING & DINING ROOM	1 : 25	○
17	LD1 - 05	SECTION 4 & 5 LIVING & DINING ROOM	1 : 25	○
18	KT1 - 01	LAYOUT KITCHEN	1 : 25	○
19	KT1 - 02	ELEVATION A KITCHEN	1 : 25	○
20	KT1 - 03	ELEVATION B KITCHEN	1 : 25	○
21	KT1 - 04	SECTION 1 KITCHEN	1 : 25	○
22	KT1 - 05	SECTION 2 KITCHEN	1 : 25	○
23	KT1 - 06	SECTION 3 KITCHEN	1 : 25	○
24	KT1 - 07	SECTION 4 KITCHEN	1 : 25	○
25	KT1 - 08	SECTION 5 KITCHEN	1 : 25	○
26	KT1 - 09	SECTION 6 KITCHEN	1 : 25	○

NO.	DRAWING NO.	TITLE	SCALE	DATE
				2025/11/21
27	BR1 - 01	LAYOUT MASTER BEDROOM	1 : 25	○
28	BR1 - 02	ELEVATION A MASTER BEDROOM	1 : 25	○
29	BR1 - 03	ELEVATION B MASTER BEDROOM	1 : 25	○
30	BR1 - 04	SECTION 1 MASTER BEDROOM	1 : 25	○
31	BR1 - 05	SECTION 2 MASTER BEDROOM	1 : 25	○
32	BR1 - 06	SECTION 3 MASTER BEDROOM	1 : 25	○
33	BR1 - 07	SECTION 4 MASTER BEDROOM	1 : 25	○
34	BR1 - 08	SECTION 5 MASTER BEDROOM	1 : 25	○
35	BR1 - 09	SECTION 6 MASTER BEDROOM	1 : 25	○
36	BR1 - 10	SECTION 7 MASTER BEDROOM	1 : 25	○
37	WC1 - 01	LAYOUT WALK IN CLOSET	1 : 25	○
38	WC1 - 02	SECTION 1 WALK IN CLOSET	1 : 25	○
39	WC1 - 03	SECTION 2 WALK IN CLOSET	1 : 25	○
40	WC1 - 04	SECTION 3 WALK IN CLOSET	1 : 25	○
41	WC1 - 05	SECTION 4 WALK IN CLOSET	1 : 25	○
42	WC1 - 06	SECTION 5 WALK IN CLOSET	1 : 25	○
43	WC1 - 07	SECTION 6 WALK IN CLOSET	1 : 25	○
44	WC1 - 08	SECTION 7 WALK IN CLOSET	1 : 25	○
45	WC1 - 09	SECTION 8 WALK IN CLOSET	1 : 25	○

DATE ON : 21/11/2025	SCALE : N.T.S	UNIT : mm	JOB NO : 51
DRAWN : Zumroti Aulia	CHECKED BY : Jessica O.		APPROVED BY : Jessica O.

SHEET NO :

A0

DRAWING NO :

01

REV. NO :

GENERAL NOTES

1. All arrangements, ideas and designs that represented on the above drawings shall remain property of the Architect/Designer and protected by copyright law. No part thereof shall be reproduced, copied, adapted, distributed, sold, published, or otherwise used in any form without the prior written consent of and appropriate compensation to the Architect/Designer of Duende Design and Build.
2. Information related to existing condition informed herein on the drawing was obtained from owner documentation during design process. All drawings are indicated to describe the general scope of design intent, and as such, may not include the required complete information needed to finalize the project; therein the accuracy of such information has not been fully verified. The contractor shall responsible for providing all required information for the proper execution and finalization of the project work, thereby shall contact the owner or Architect/Designer immediately for clarification or supplemental information if additional information is necessary or there are unclear meaning of the documents.
3. Drawings and specifications are intended for assistance and guidance, but exact dimensions shall be controlled by actual conditions at the site. The exact field measurement is part of contractor and subcontractor responsibility for accurate fabrication and installation; therein all dimensions and on site conditions are required to be verified before work started, also Contractor/Subcontractor shall report to Architect/Designer if there are any discrepancies.
4. Contractor and subcontractor shall be responsible for achieving necessary design result which is based on all specified items on the drawings.
5. Duende Design and Build is not responsible for any discrepancies in size, measurement, shape and proportion from client's signed/approved graphic elements.

DESIGN TEAM

PRINCIPAL DESIGNER:
-

PROJECT TEAM:
-

DRAWING SYMBOLS

	COLUMN LINE REFERENCE
	MATCH LINE
	BUILDING SECTION TAG
	ELEVATION TAG
	FURNITURE SECTION TAG
	ENLARGED DETAIL TAG
	FURNITURE, FIXTURE, & EQUIPMENT
	SPACE/ROOM NUMBER
	DRAWING TITLE
	GRAPHIC DRAWING SCALE

	STRUCTURE COLUMN
	PRAKTIS COLUMN
	HEBEL / BRICK WALL 1 : 2
	HEBEL / BRICK WALL 1 : 4
	PARTITION
	DIMENSION STYLE
	MULTILEADER STYLE
	ROOM LABEL
	PILE INDICATOR
	ENTRY INDICATOR

MATERIAL SYMBOLS

	Ceramic, Epoxy, Concrete Floor, Granite Tile, Homogenous Tile, Mozaic
	Fabric, Leather, Carpet
	Glass, Mirror
	Laminated : HPL, Veneer
	Metal : Aluminum, Stainless Steel
	Paint : Wall Paint, Duco Paint, Emulsion Paint, Melamic Paint
	Stone : Exposed Brick Wall, Natural Stone, Granite, Marble, Solid Surface, Terazzo
	Timber : Ecowood/Composite Wood, Solid Wood, Kalsiplank, Parquette, Rattan
	Curtain Wall, Graphic Wall, Printing Wall, Wallpaper

CLIENT :
Mrs. S

CONTRACTOR :

PROJECT : Vivaldy Residence
 LOCATION : Summarecon Serpong, Tangerang

DRAWING TITLE :
Notes, Symbol & Legends

DATE ON : 21/11/2025	SCALE : N.T.S	UNIT : mm	JOB NO : 51	CHECKED BY : Jessica O.
DRAWN : Zumrati Aulia				APPROVED BY : Jessica O.

SHEET NO : A0	DRAWING NO : 02
---------------	-----------------

REV. NO :

Vivaldy Residence, Summarecon Serpong

INTERIOR ARCHITECTURAL MATERIAL LIST



Serpong Utara, Tangerang Selatan
+62812 8603 4050
duende.designandbuild@gmail.com

CLIENT :

Mrs. S

CONTRACTOR :

Vivaldy Residence

LOCATION :

Summarecon Serpong, Tangerang

PROJECT :

Material List

DRAWING TITLE :

NO.	MATERIAL	CODE	LOOKS (SIMPLIFIED)	LOCATION		BRAND	TYPE
01	WALL PAINT	P1	WHITE	ALL INDOOR WALL FINISH			
02	CEILING PAINT	P2	WHITE	ALL CEILING FINISH			
03	GLASS	G1	CLEAR	LIVING ROOM WALK IN CLOSET KITCHEN	VERTICAL CABINET DOOR WARDROBE DOOR VERTICAL KITCHEN SET	BY CONTRACTOR	
04	MIRROR	G2	CLEAR MIRROR	MASTER BEDROOM DINING ROOM	DRESSING AREA WALL PANEL AND WARDROBE DOOR WALL PANEL	BY CONTRACTOR	
05		G3	BRONZE MIRROR	MASTER BEDROOM	BED CENTER WALL PANEL	BY CONTRACTOR	
06	ALUMUNIUM	M1	DARK GREY/BLACK	LIVING ROOM	VERTICAL CABINET DOOR FRAME	BY CONTRACTOR	
07	METAL	M2	DARK GREY/BLACK	KITCHEN	EXTENTION TABLE LEG	BY CONTRACTOR	
08	STAINLESS PLAT	M3		KITCHEN	UPPER CABINET ACCENT		
09	HOMOGENEOUS TILE	H1	WHITE MARBLE 60X120 CM	KITCHEN	TOP TABLE & BACKSPLASH		
10		H2	WHITE GREY 30X30 CM (TEXTURED)	BACK TERRACE	FLOORING		
11		H3	WOODEN LIGHT BROWN 15X90 CM	WALK IN CLOSET	FLOORING		
12	CERAMIC TILE	C1	POLISHED WHITE 20X20 CM	LOWER CABINET PLINTH			
13	HPL	L1A	WOOD GRAIN (MED-DARK)	LIVING ROOM	OPEN CABINET	TACO	TH 325 NT BROWN KRAFTWOOD
				DINING ROOM	WALL PANEL		
				KITCHEN	FRIDGE CABINET		
14		L1B		MASTER BEDROOM	CABINET TV, BED SIDE WALL PANEL	TACO	TH 5033 NT SUNKISSED OAK
15		L2A	SOLID WARM WHITE	LIVING ROOM	TV WALL PANEL, TV CABINET BODY, VERTICAL CLOSE CABINET	CARTA	CT 0163 T WARM WHITE
		L2B	SOLID LIGHT GRAY	MASTER BEDROOM	BED CENTER WALL PANEL		
16		L2C			KITCHEN	UPPER CABINET	CARTA
17		L3A	MARBLE WHITE	WALK IN CLOSET	WARDROBE, DRESSING TABLE BODY, MIRROR FRAME	TACO	TH 062 SA FLOUR WHITE
				LIVING ROOM	TOP TV CABINET	TACO	TH L7012 DP SAHARA MARBLE
		MASTER BEDROOM	TV WALL PANEL				
	DINING ROOM	WALL PANEL					
18	L3B		WALK IN CLOSET	DRESSING TOP TABLE	TACO	TH 887 JG MILKY RAMONE GLOSS	
19	L4	SOLID MED GREY	KITCHEN	LOWER CABINET	CARTA	CX 0307 DM ASPHALT GREY	
20	L5	FABRIC	LIVING ROOM	VERTICAL CABINET INNER	TACO	TH 1235 FA CREAM BRIXTER	
21	L6	FABRIC	WALK IN CLOSET	WARDROBE INNER	TACO	TH 7202 AA CREAM TROFEO	

DATE ON : 21/11/2025	SCALE : N1:5	UNIT : mm	JOB NO : 51	CHECKED BY : Jessica O.
DRAWN : Zumrati Aulia				APPROVED BY : Jessica O.

SHEET NO :

A0

DRAWING NO :

03

REV. NO :




Serpong Utara, Tangerang Selatan
+62812 8603 4050
duende.designandbuild@gmail.com

CLIENT :

Mrs. S

CONTRACTOR :

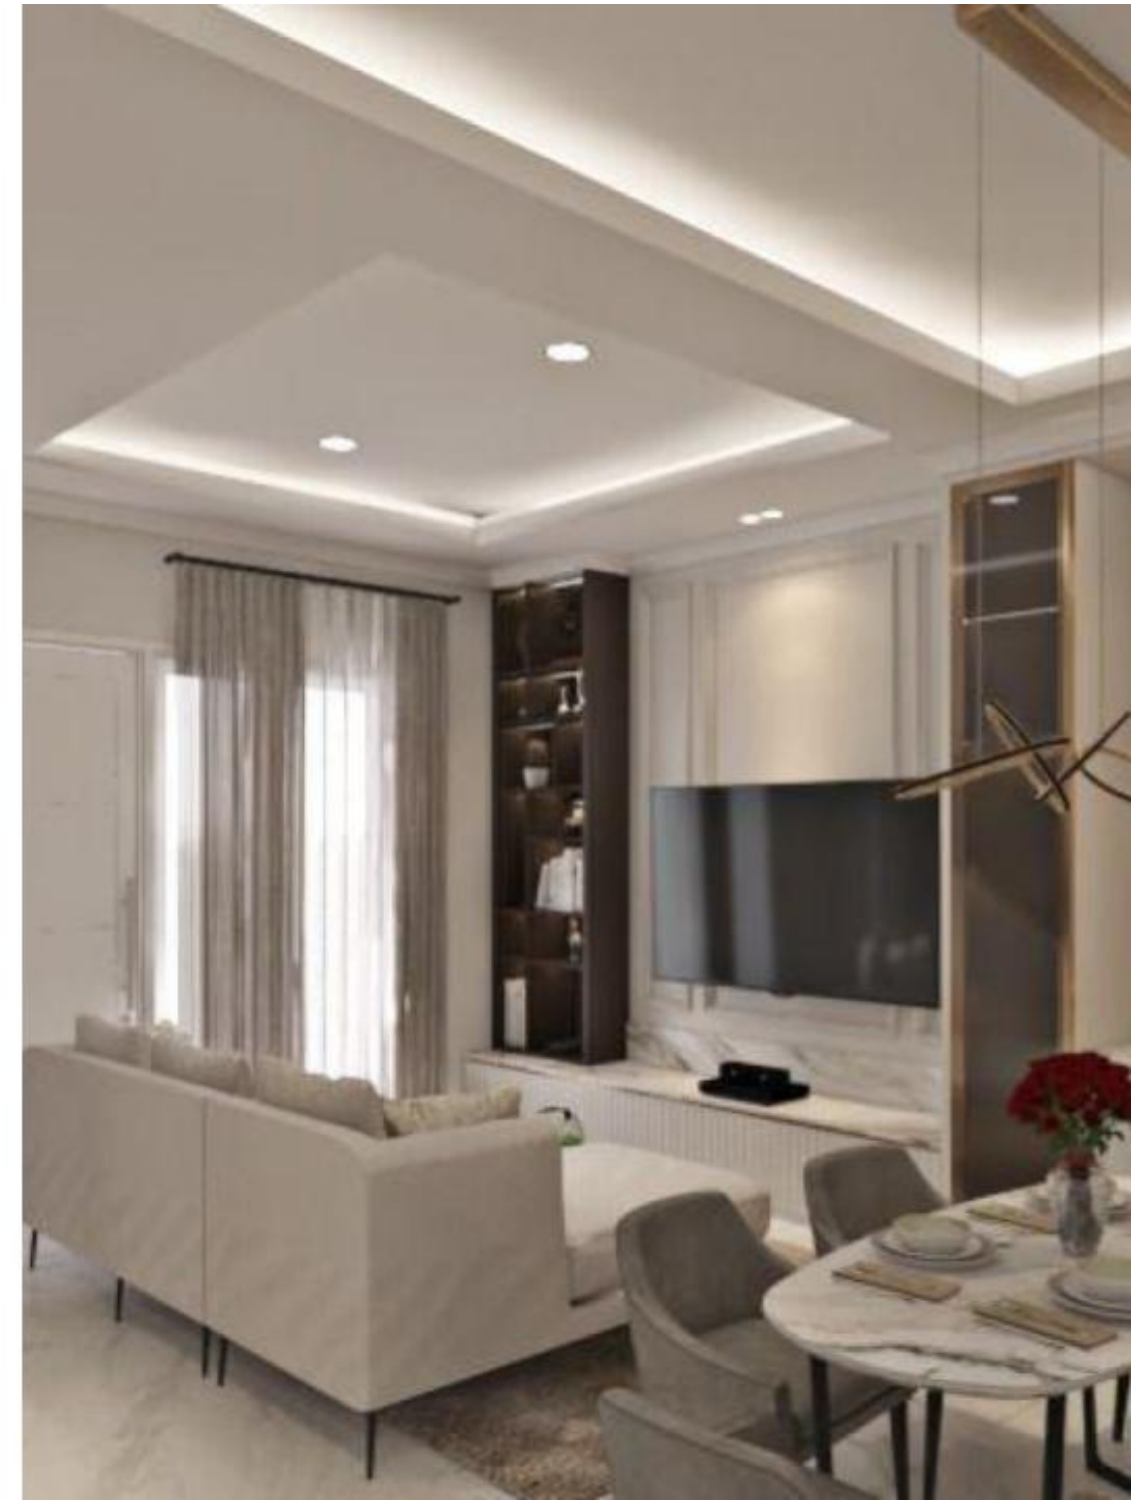

PROJECT :

Vivaldy Residence

LOCATION :

Summarecon Serpong, Tangerang

DRAWING TITLE :

Perspective Living Room & Dining Room

DATE ON : 21/11/2025	SCALE : N.T.S	UNIT : mm	JOB NO : 51
DRAWN : Zurrafi Aulia	CHECKED BY : Jessica O.		APPROVED BY : Jessica O.

SHEET NO :

PR1

DRAWING NO :

01

REV. NO :

CLIENT :
Mrs. S

CONTRACTOR :

PROJECT :
Vivaldy Residence
 LOCATION :
Summarecon Serpong, Tangerang

DRAWING TITLE :
Perspective Kitchen



DATE ON : 21/11/2025	SCALE : N.T.S	DRAWN : Zumrati Aulia	UNIT : mm	JOB NO : 51	CHECKED BY : Jessica O.	APPROVED BY : Jessica O.
-------------------------	------------------	--------------------------	--------------	----------------	----------------------------	-----------------------------

SHEET NO : PR1	DRAWING NO : 02
--------------------------	---------------------------



CLIENT :
Mrs. S

CONTRACTOR :

PROJECT : **Vivaldy Residence**
 LOCATION : **Summarecon Serpong, Tangerang**

DRAWING TITLE : **Perspective Master Bedroom**

DATE ON : 21/11/2025	SCALE : N.T.S	UNIT : mm	JOB NO : 51
DRAWN : Zumrati Aulia	CHECKED BY : Jessica O.		APPROVED BY : Jessica O.

SHEET NO : **PR1**
 DRAWING NO : **03**



CLIENT :
Mrs. S

CONTRACTOR :

PROJECT : **Vivaldy Residence**
 LOCATION : **Summarecon Serpong, Tangerang**

DRAWING TITLE : **Perspective Master Bedroom**

DATE ON : 21/11/2025	SCALE : N.T.S	UNIT : mm	JOB NO : 51
DRAWN : Zumrati Aulia	CHECKED BY : Jessica O.		APPROVED BY : Jessica O.

SHEET NO : **PR1**
 DRAWING NO : **04**



CLIENT :
Mrs. S

CONTRACTOR :

PROJECT : **Vivaldy Residence**
 LOCATION : **Summarecon Serpong, Tangerang**

DRAWING TITLE : **Perspective Walk In Closet**

DATE ON : 21/11/2025	SCALE : N.T.S	UNIT : mm	JOB NO : 51
DRAWN : Zumrahi Aulia	CHECKED BY : Jessica O.		APPROVED BY : Jessica O.

SHEET NO : PR1	DRAWING NO : 05
--------------------------	---------------------------



CLIENT :
Mrs. S

CONTRACTOR :

PROJECT : **Vivaldy Residence**
 LOCATION : **Summarecon Serpong, Tangerang**

DRAWING TITLE : **Perspective Walk In Closet**


DATE ON : 21/11/2025	SCALE : N.T.S	UNIT : mm	JOB NO : 51
DRAWN : Zumrati Aulia	CHECKED BY : Jessica O.		APPROVED BY : Jessica O.

SHEET NO : **PR1**
 DRAWING NO : **06**




Serpong Utara, Tangerang Selatan
+62812 8603 4050
duende.designandbuild@gmail.com

CLIENT :
Mrs. S

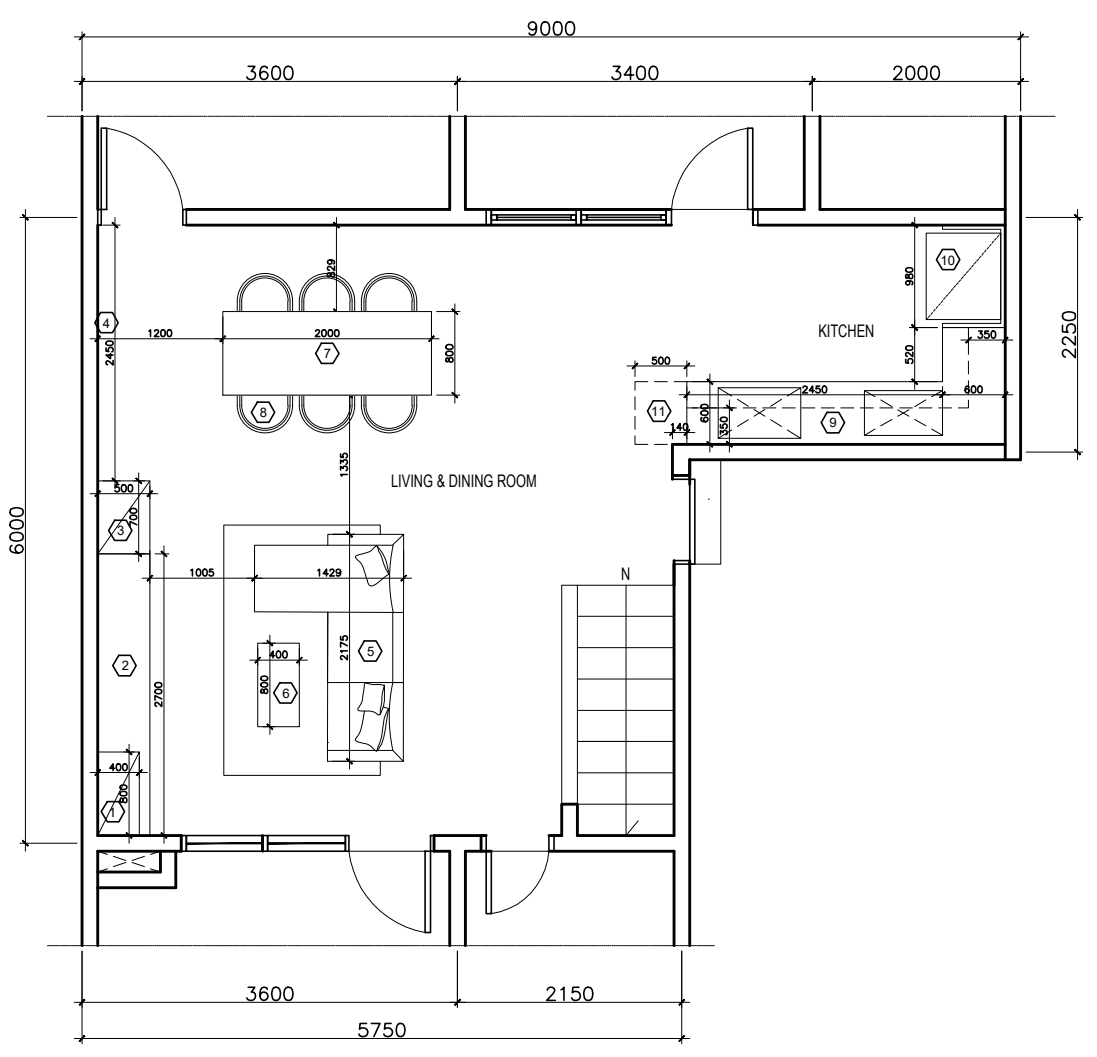

Layout Lt.1
Scale 1:75

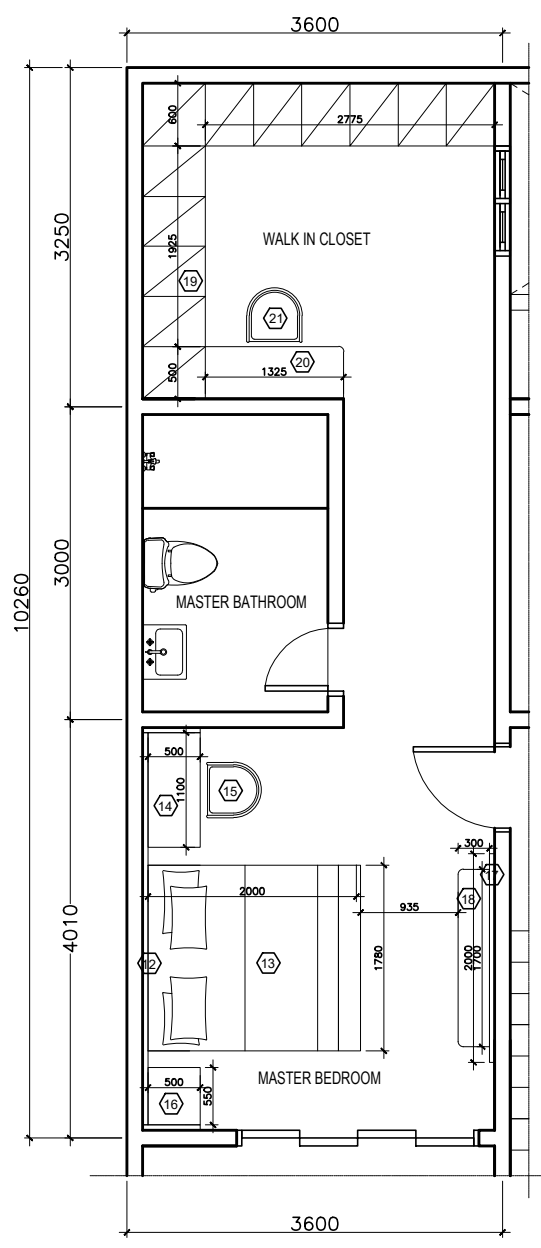

Layout Lt.2
Scale 1:75

LEGEND

- ① = OPEN CABINET
- ② = TV CABINET & TV WALL PANEL
- ③ = VERTICAL CABINET
- ④ = DINING ROOM WALL PANEL
- ⑤ = SOFA 3S L-SHAPED
- ⑥ = COFFE TABLE
- ⑦ = DINING TABLE
- ⑧ = DINING CHAIR
- ⑨ = KITCHEN SET
- ⑩ = FRIDGE CABINET
- ⑪ = FOLDING TABLE
- ⑫ = BED WALL PANEL
- ⑬ = BED 200X200 CM
- ⑭ = WORKING TABLE
- ⑮ = WORKING CHAIR
- ⑯ = BED SIDE TABLE
- ⑰ = TV WALL PANEL
- ⑱ = TV CABINET
- ⑲ = WARDROBE
- ⑳ = DRESSING TABLE
- ㉑ = STOOL/CHAIR

CONTRACTOR :

PROJECT : **Vivaldy Residence**
LOCATION : **Summarecon Serpong, Tangerang**


DRAWING TITLE :

Layout Interior


DATE ON :	SCALE :	N.T.S	UNIT :	mm	JOB NO :	51
DRAWN :	Zurmiti Aulia		APPROVED BY :		Jessica O.	
CHECKED BY :		Jessica O.				

SHEET NO :	DRAWING NO :
A1	01

REV. NO :

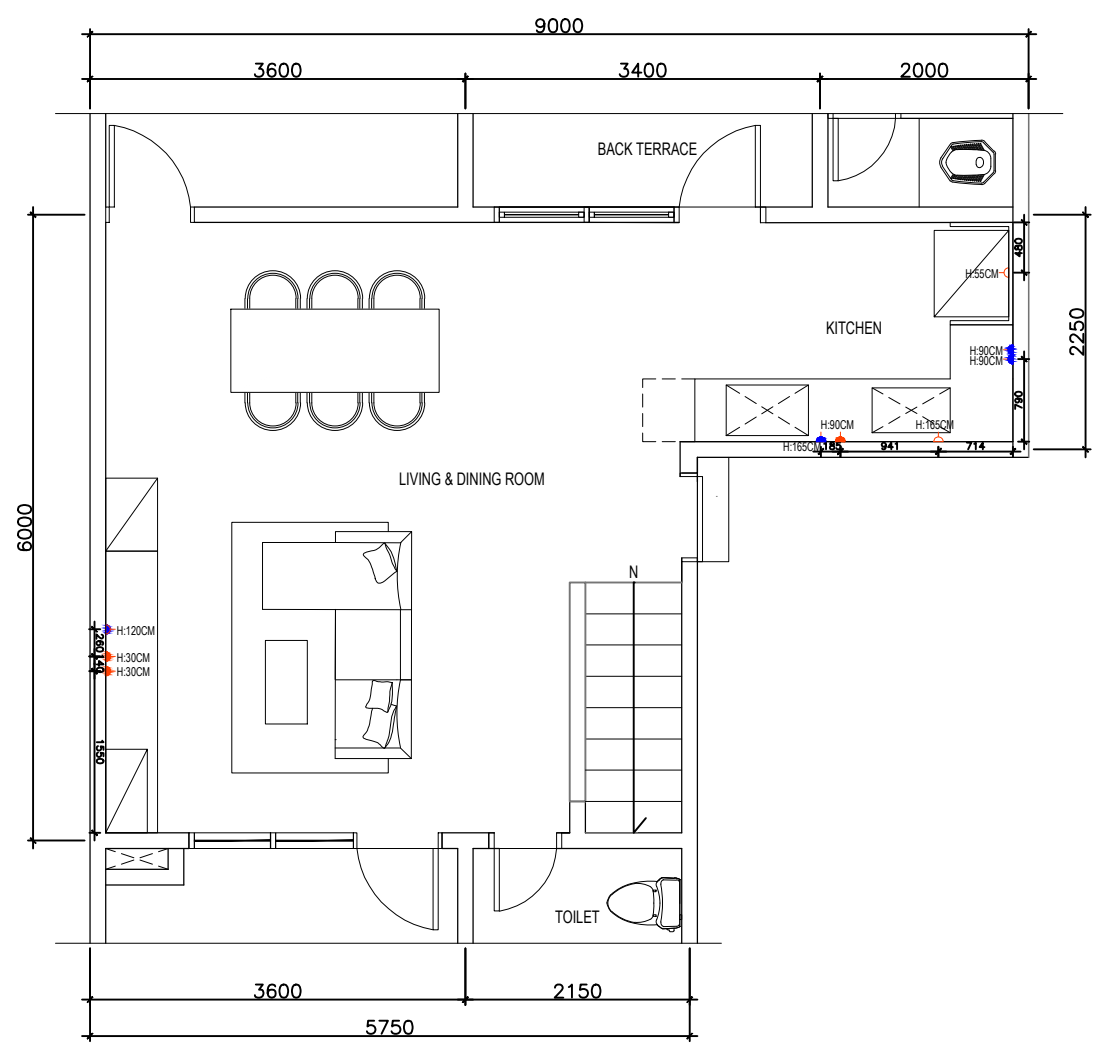



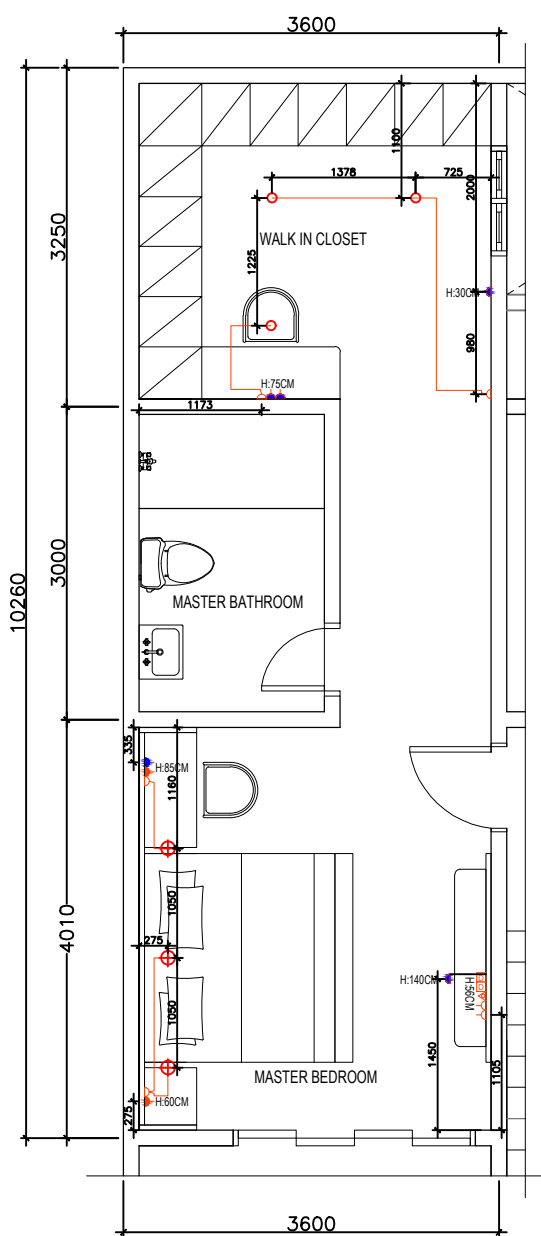






Electrical Layout Lt.1 (Power Socket)
 Scale 1:75



Electrical Layout Lt.2 (Power Socket)
 Scale 1:75

LEGEND

-  = POWER SOCKET (POSITION AS EXISTING) (4 PCS)
-  = POWER SOCKET (CHANGE POSITION) (5 PCS)
-  = POWER SOCKET (NEW) (9 PCS)
-  = OUTLET DATA (2 PCS)
-  = OUTLET TV BERBAYAR (1 PCS)
-  = SPOT LIGHT (3 PCS)
-  = DOWN LIGHT (3 PCS)
-  = SINGLE LIGHT SWITCH (3 PCS)
-  = DOUBLE LIGHT SWITCH (1 PCS)

CLIENT :
 Mrs. S

CONTRACTOR :

PROJECT : Vivaldy Residence
 LOCATION : Summarecon Serpong, Tangerang

DRAWING TITLE :
 Layout Electrical

DATE ON : 21/11/2025	SCALE : N.T.S	UNIT : mm	JOB NO : 51
DRAWN : Zumrati Aulia			CHECKED BY : Jessica O.
		APPROVED BY : Jessica O.	

SHEET NO : A1	DRAWING NO : 02
---------------	-----------------



DUENDE
design + build


Serpong Utara, Tangerang Selatan
+62812 8603 4050
duende.designandbuild@gmail.com

CLIENT :

Mrs. S

CONTRACTOR :

PROJECT : **Vivaldy Residence**
LOCATION : **Summarecon Serpong, Tangerang**

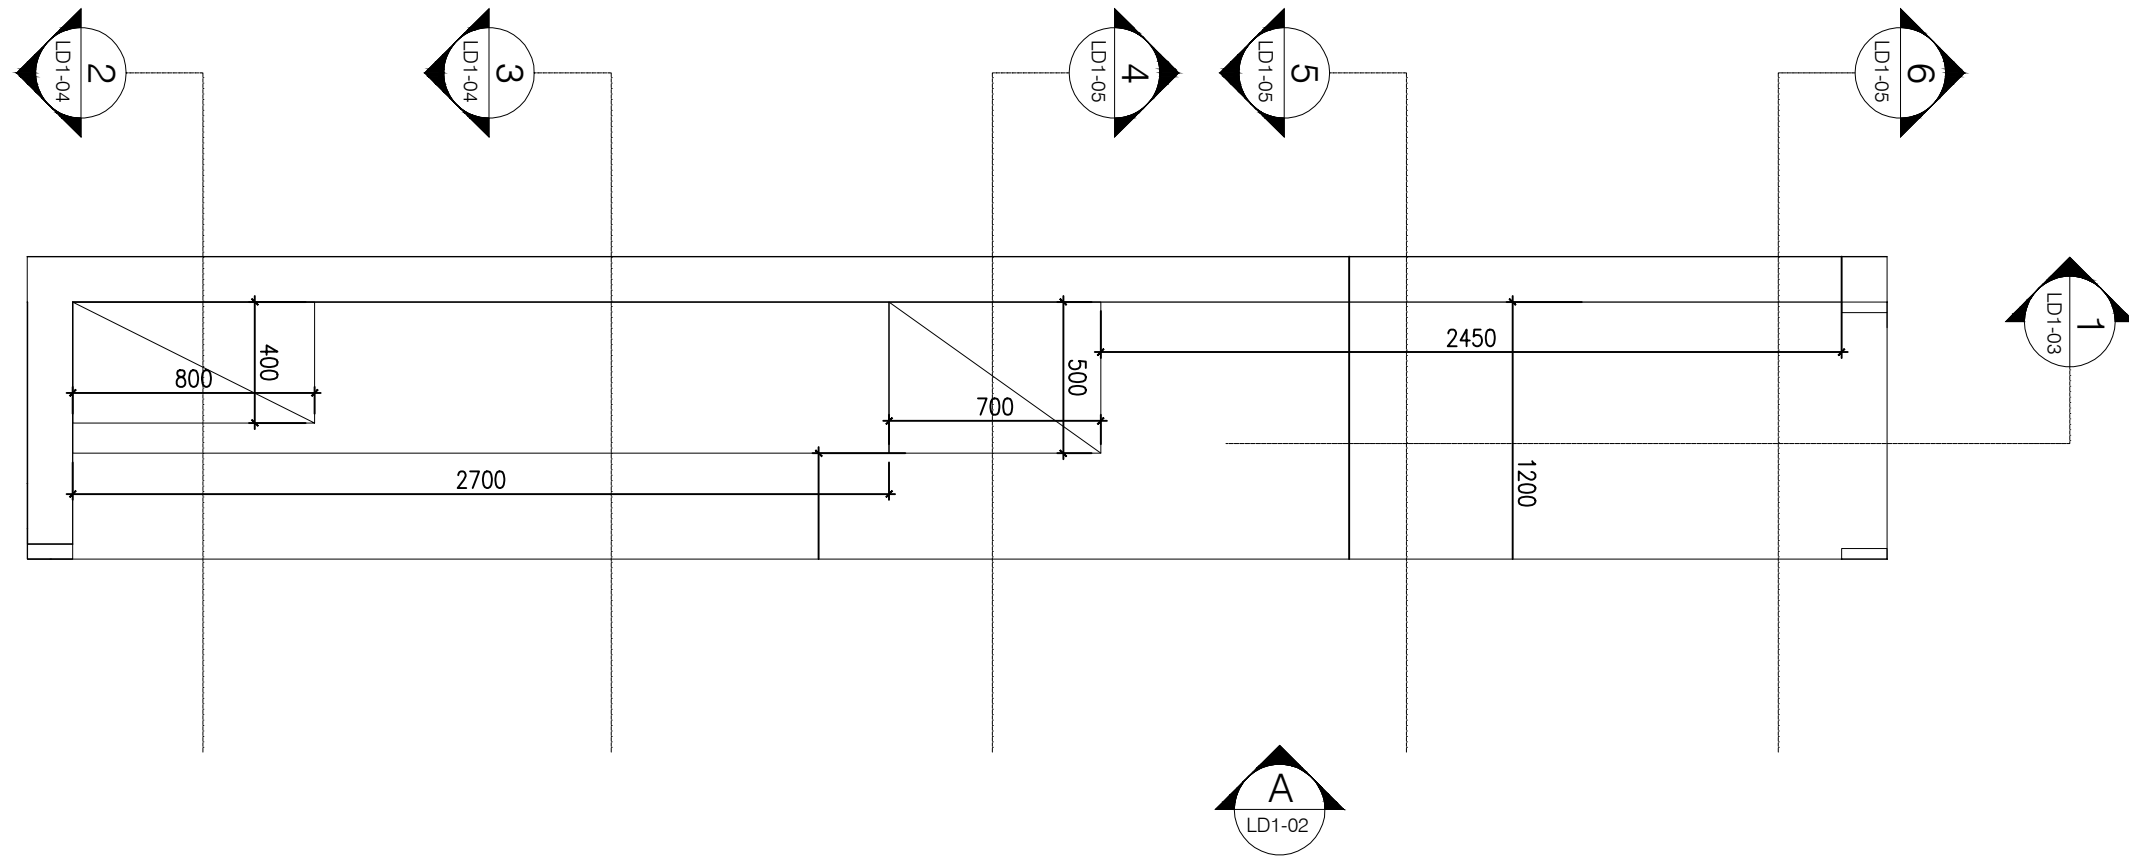

LAYOUT LIVING ROOM & DINING ROOM

SCALE 1:25

DRAWING TITLE :
Layout

DATE ON : 21/11/2025	SCALE : 1 : 25	UNIT : mm	JOB NO : 51
DRAWN : Citra A.	CHECKED BY : Jessica O.		APPROVED BY : Jessica O.

SHEET NO : LD1	DRAWING NO : 01
-------------------	--------------------

REV. NO :



DUENDE
design + build

Serpong Utara, Tangerang Selatan
+62812 8603 4050
duende.designandbuild@gmail.com

CLIENT :

Mrs. S

CONTRACTOR :

PROJECT :


Vivaldy Residence

LOCATION :

Summarecon Serpong, Tangerang

DRAWING TITLE :

Layout

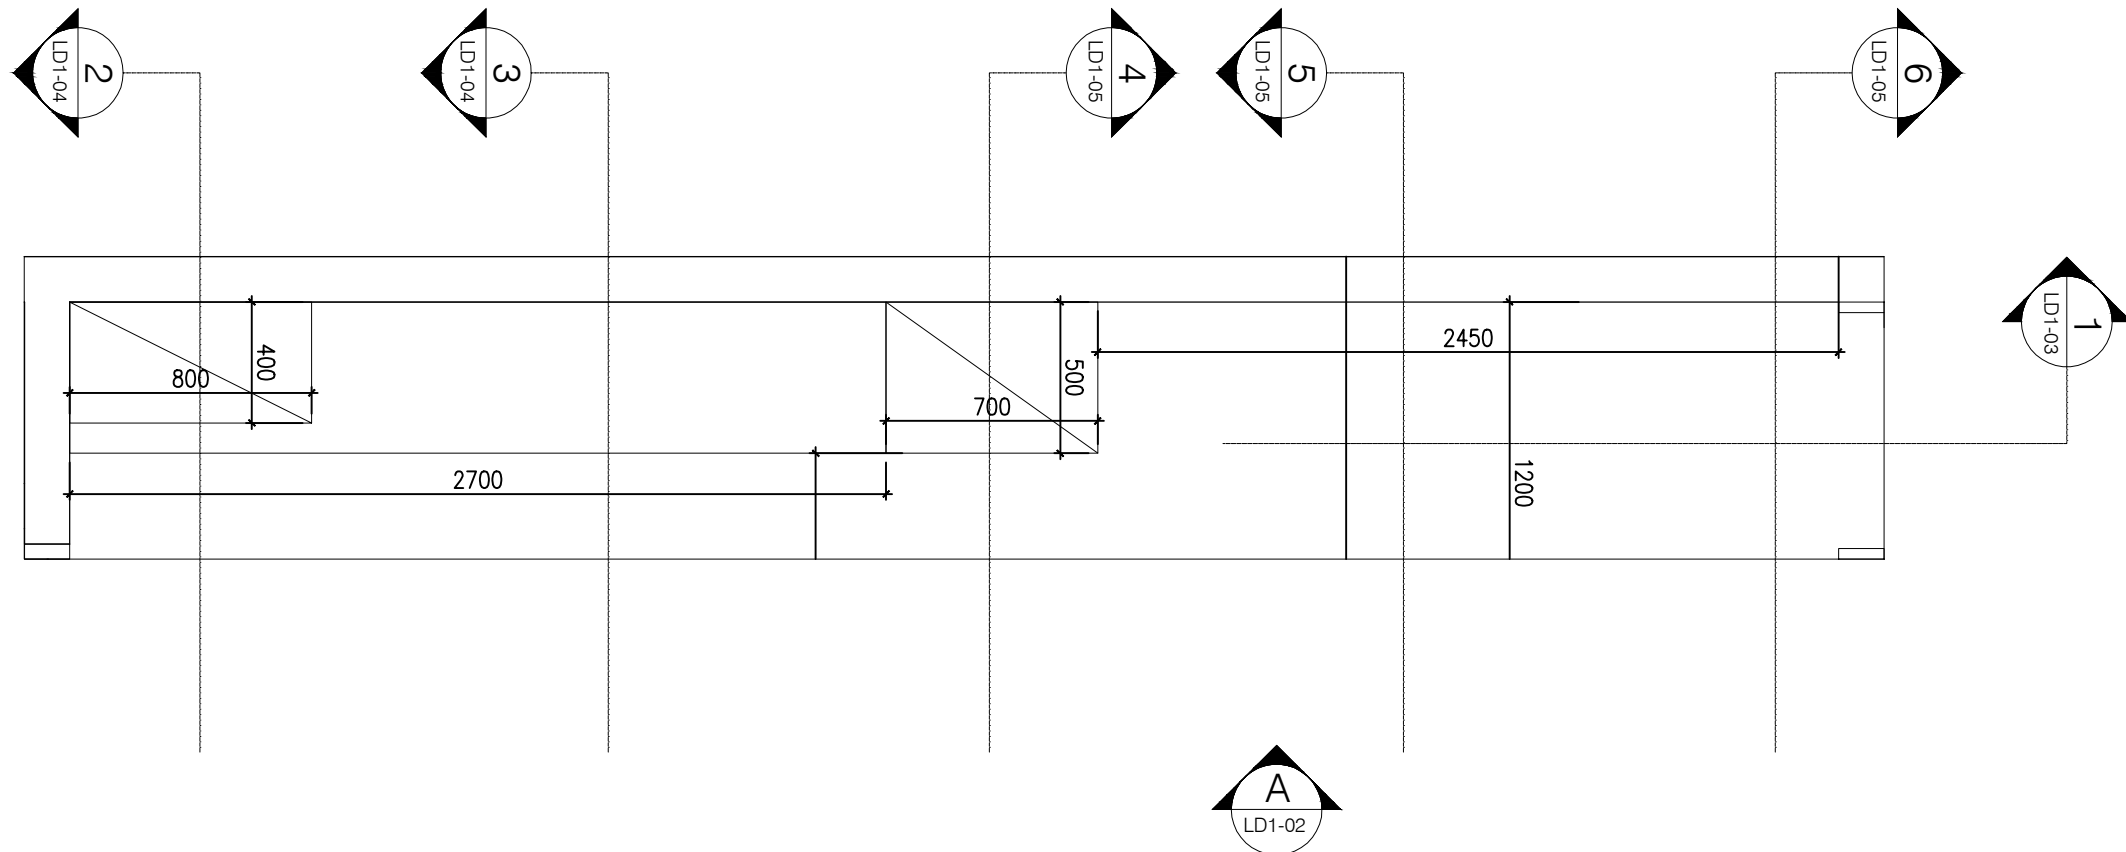


LAYOUT LIVING ROOM & DINING ROOM
SCALE 1:25

DATE ON : 21/11/2025	SCALE : 1 : 25	DRAWN : Citra A.	UNIT : mm	JOB NO : 51	APPROVED BY : Jessica O.
CHECKED BY : Jessica O.					

SHEET NO : LD1	DRAWING NO : 01
-------------------	--------------------

REV. NO :

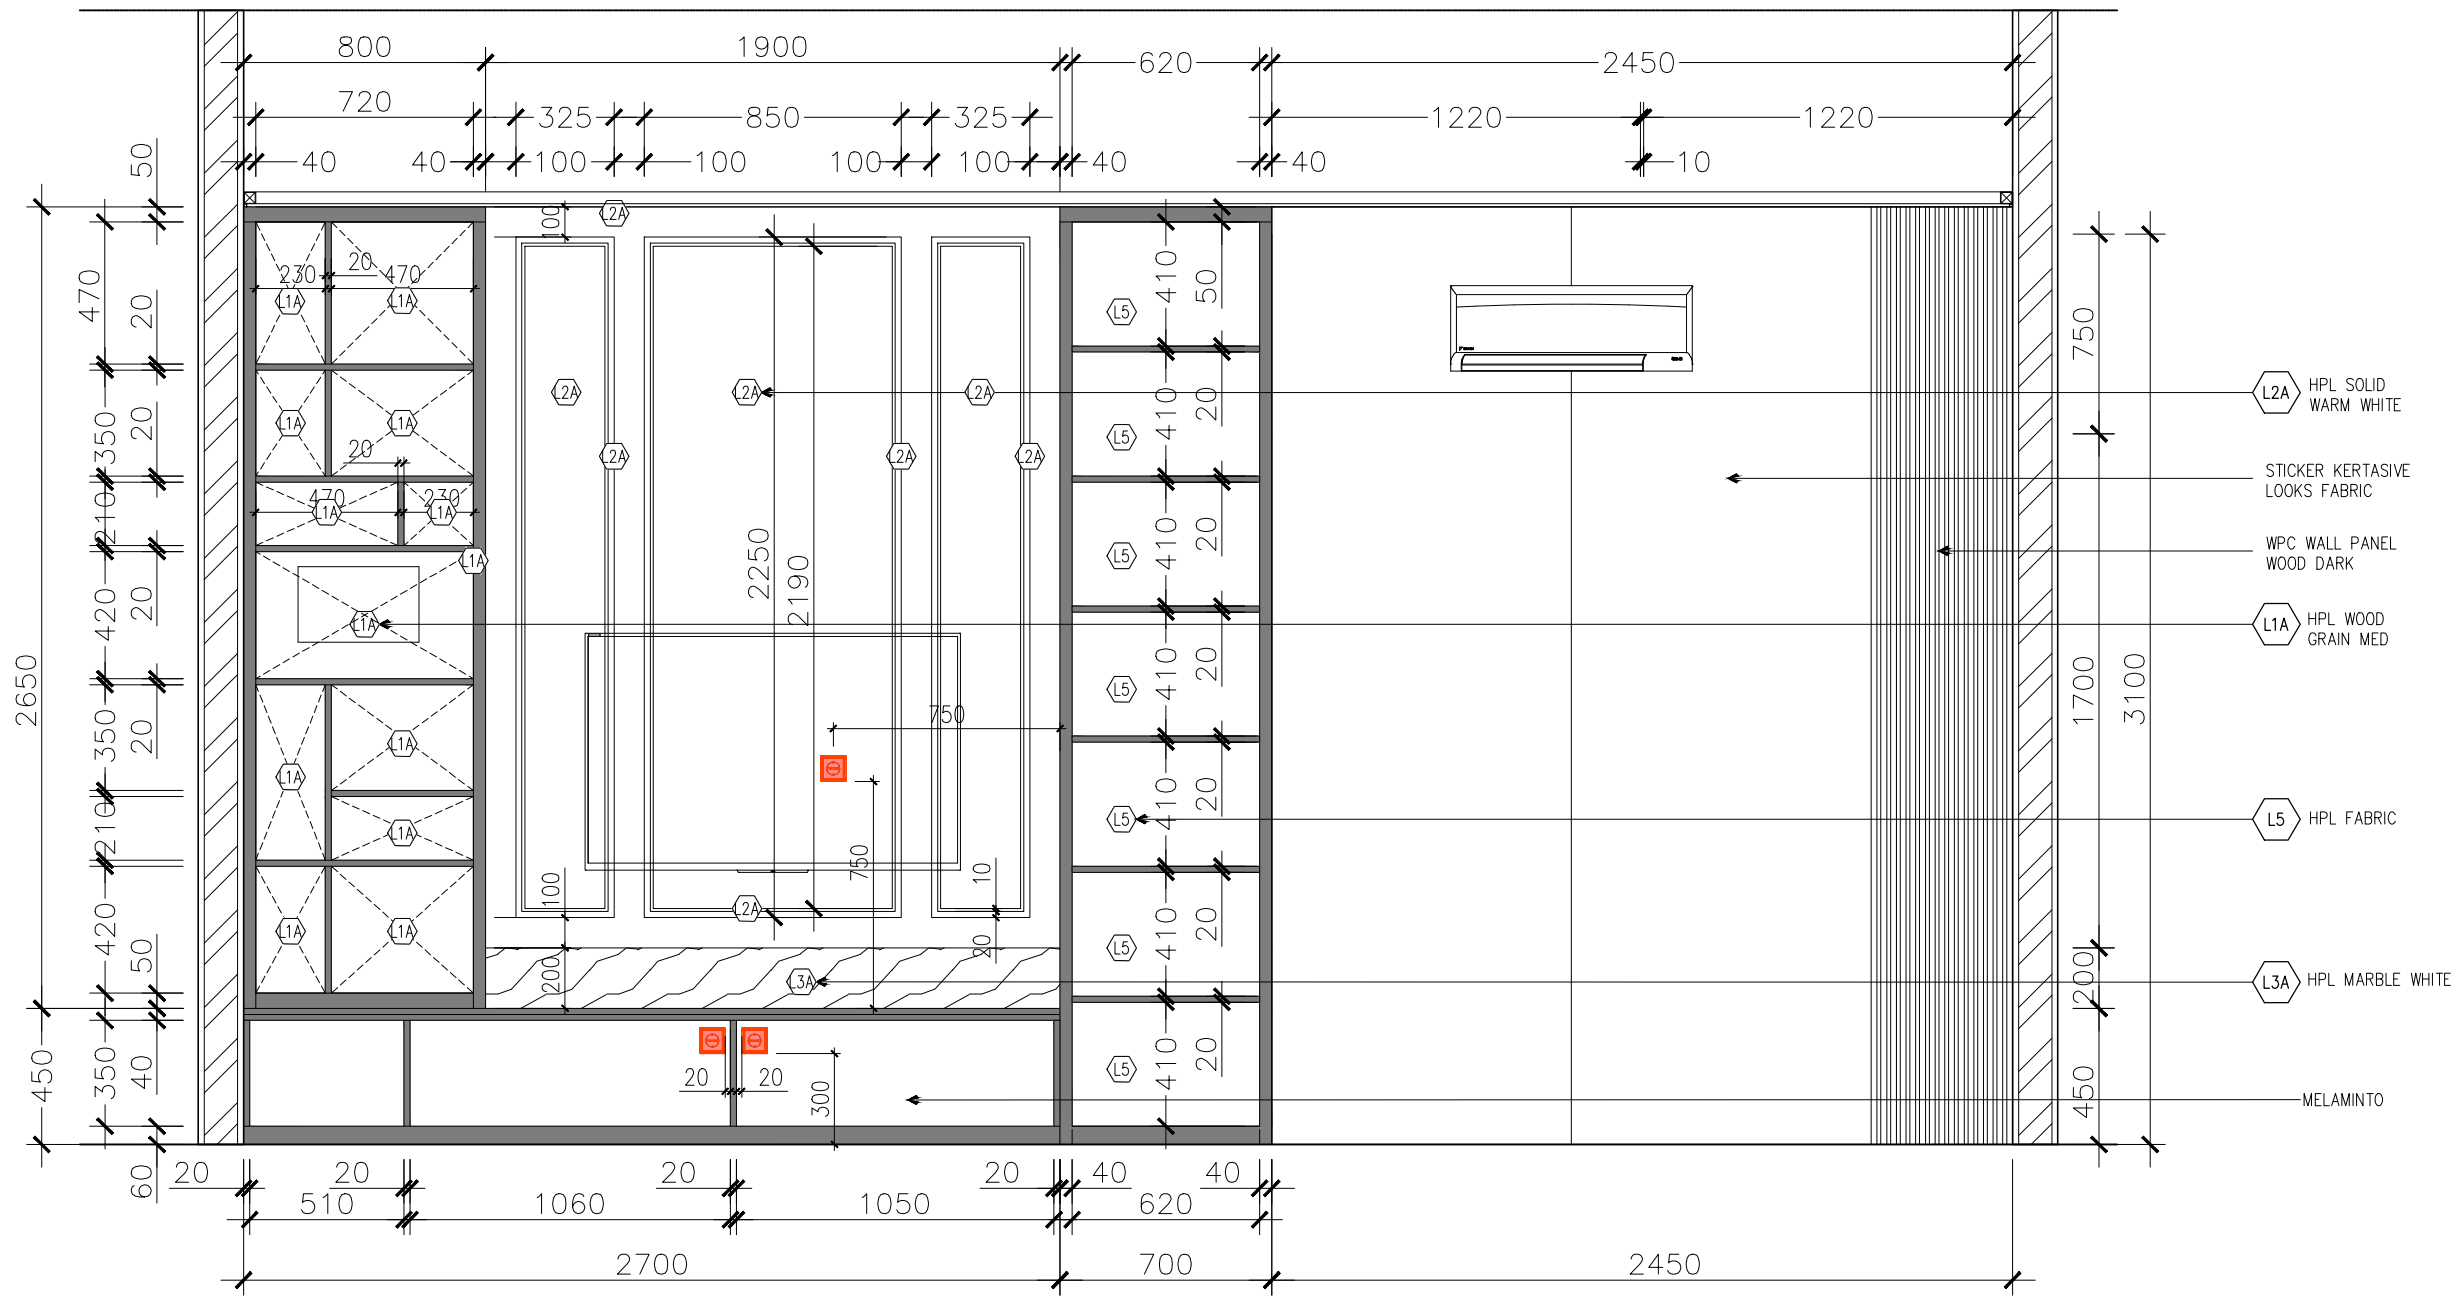

SECTION 1 BACKDROP TV
SCALE 1:25

PROJECT :
Vivaldy Residence
 LOCATION :
Summarecon Serpong, Tangerang

DRAWING TITLE :
Section 1

DATE ON : 21/11/2025	SCALE : 1:25	DRAWN : Olga A.	UNIT : mm	JOB NO : 51	APPROVED BY : Jessica O.
CHECKED BY : Jessica O.					

SHEET NO : LD1	DRAWING NO : 03
-------------------	--------------------



Serpong Utara, Tangerang Selatan
 +62812 8603 4050
 duende.designandbuild@gmail.com

CLIENT :

Mrs. S


CONTRACTOR :

PROJECT :
Vivaldy Residence


LOCATION :
Summarecon Serpong, Tangerang

DRAWING TITLE :

Section 2 & 3

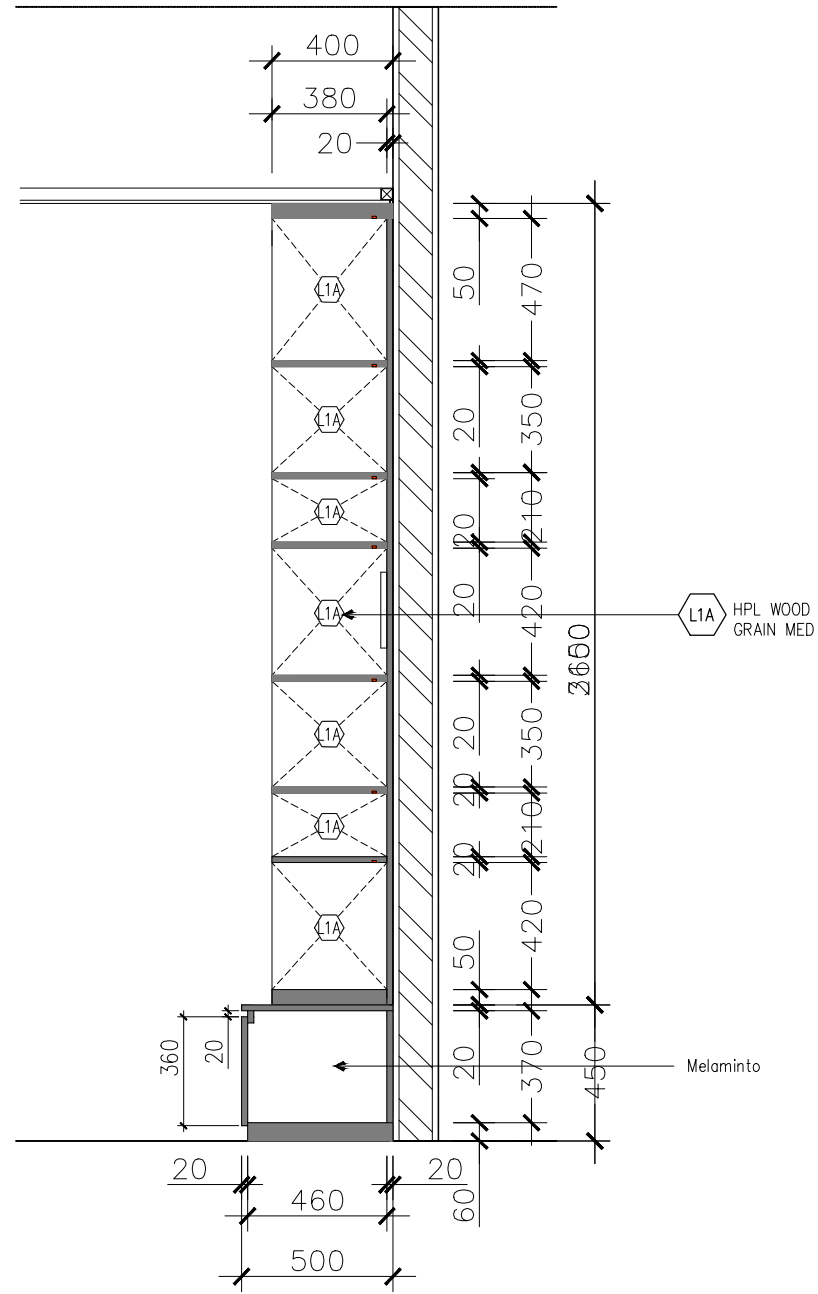

SECTION 2 BACKDROP TV
SCALE 1:25

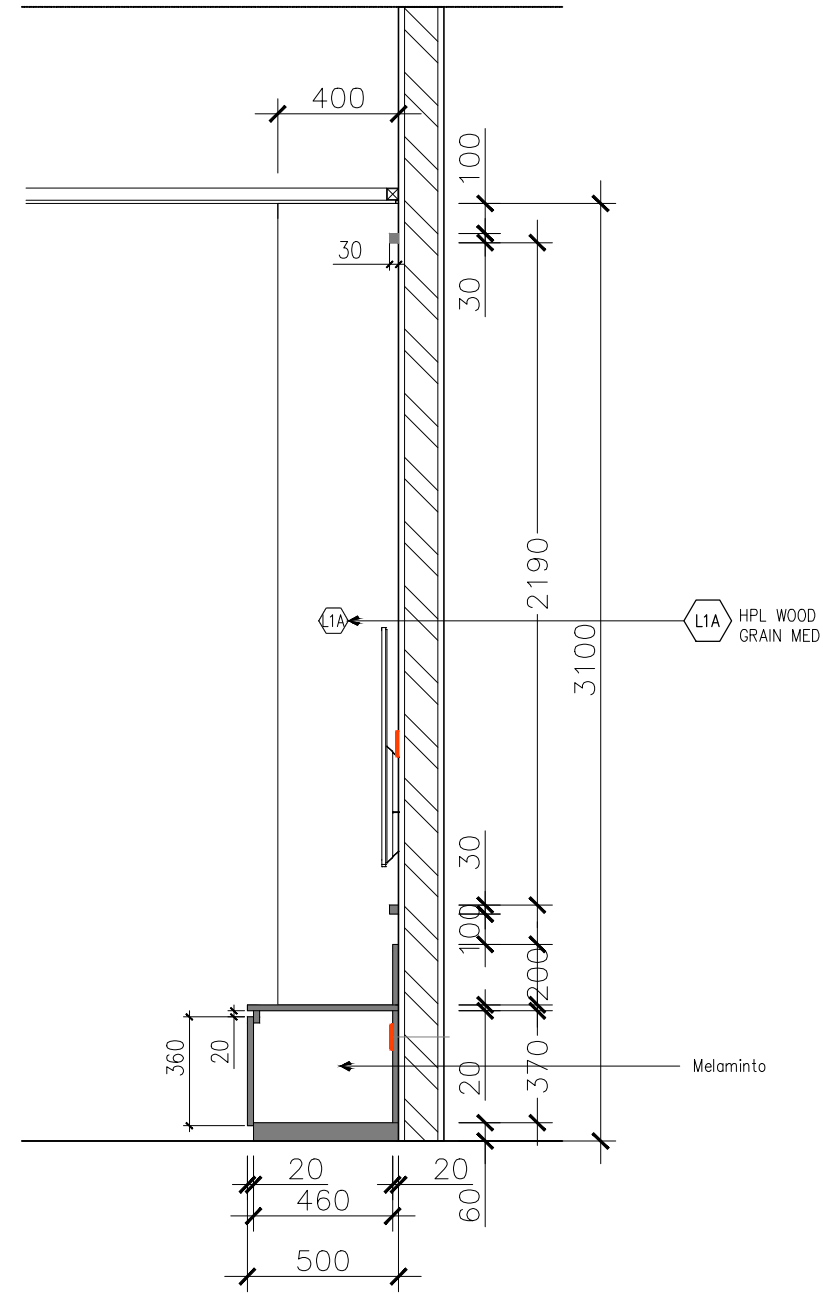


SECTION 3 BACKDROP TV
SCALE 1:25

DATE ON : 21/11/2025	SCALE : 1 : 25	DRAWN : Olga A	UNIT : mm	JOB NO : 51	APPROVED BY : Jessica O.
CHECKED BY : Jessica O.					


SHEET NO : LD1	DRAWING NO : 04
-------------------	--------------------

REV. NO :


CLIENT :
Mrs. S

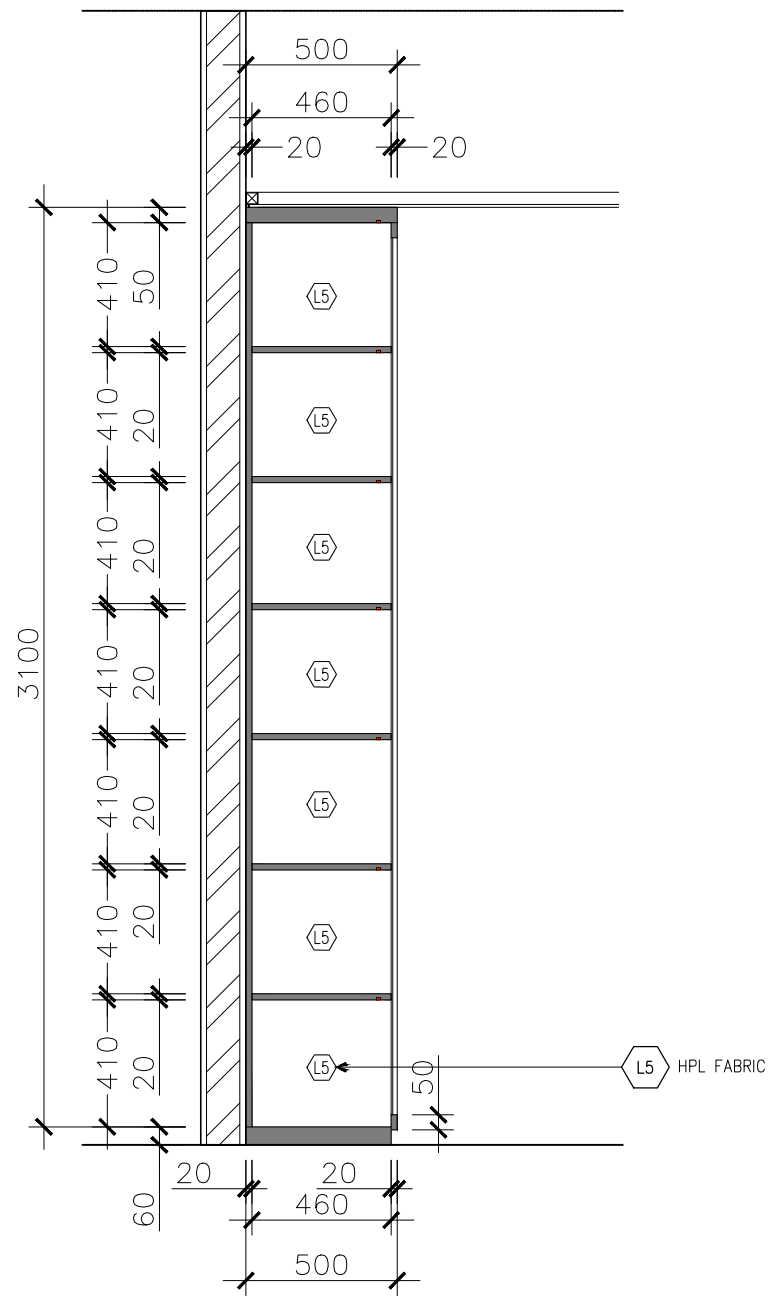

SECTION 4 BACKDROP TV
SCALE 1:25

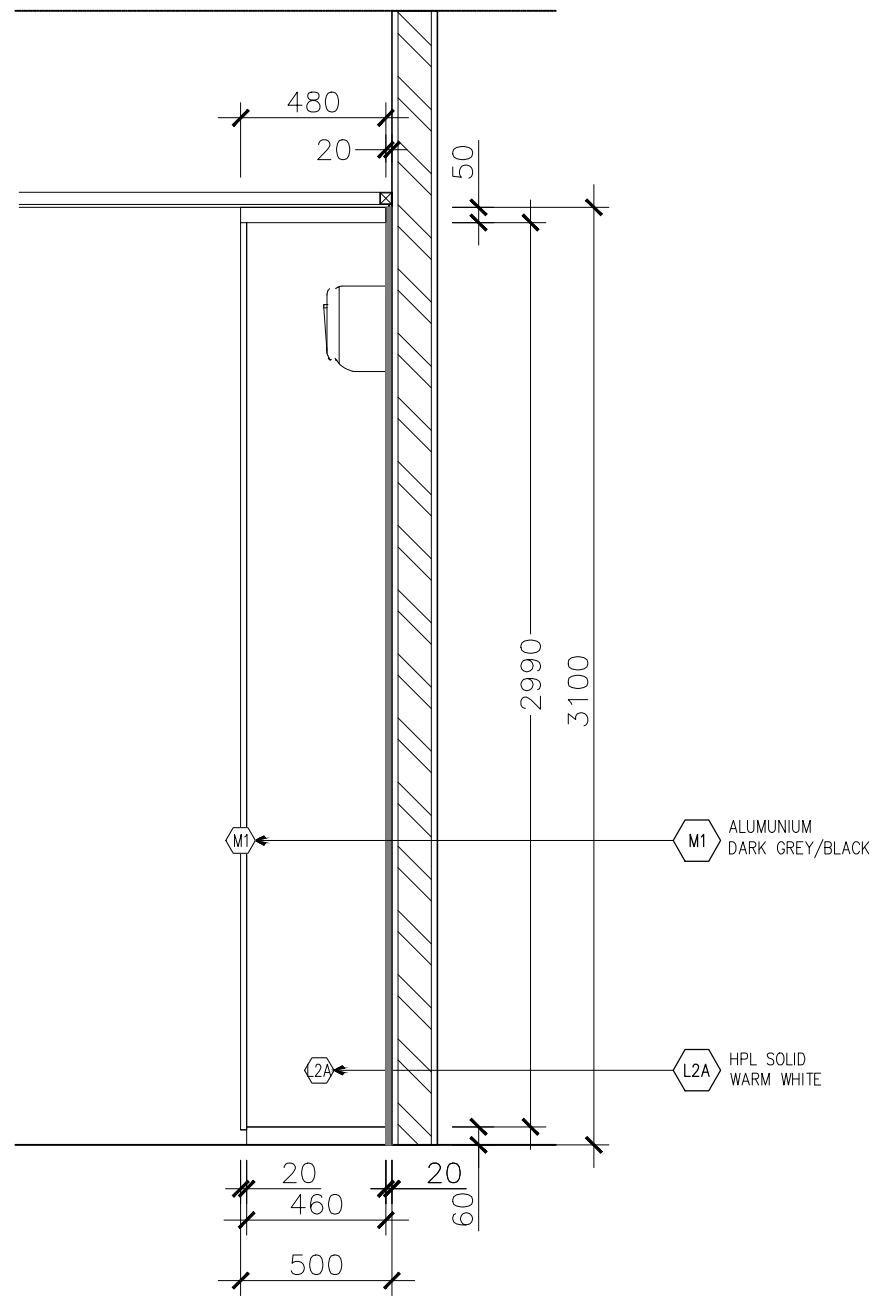

SECTION 5 BACKDROP TV
SCALE 1:25

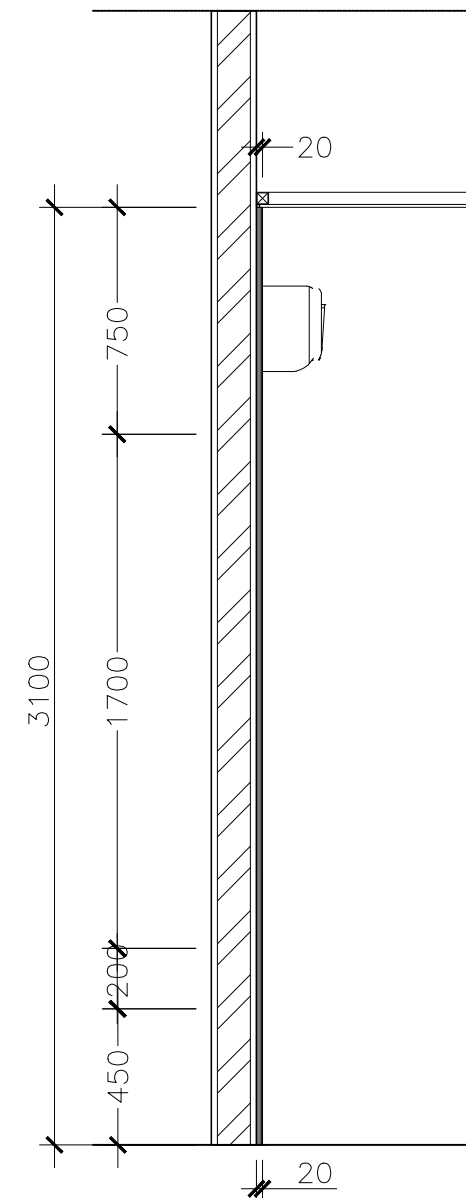

SECTION 6 BACKDROP TV
SCALE 1:25

CONTRACTOR :
Vivaldy Residence


PROJECT :
Summarecon Serpong, Tangerang

LOCATION :

DRAWING TITLE :
Section 4,5 & 6

DATE ON : 21/11/2025	SCALE : 1:25	UNIT : mm	JOB NO : 51
DRAWN : CliaA	CHECKED BY : Jessica O.	APPROVED BY : Jessica O.	

SHEET NO : LD1	DRAWING NO : 05
-------------------	--------------------

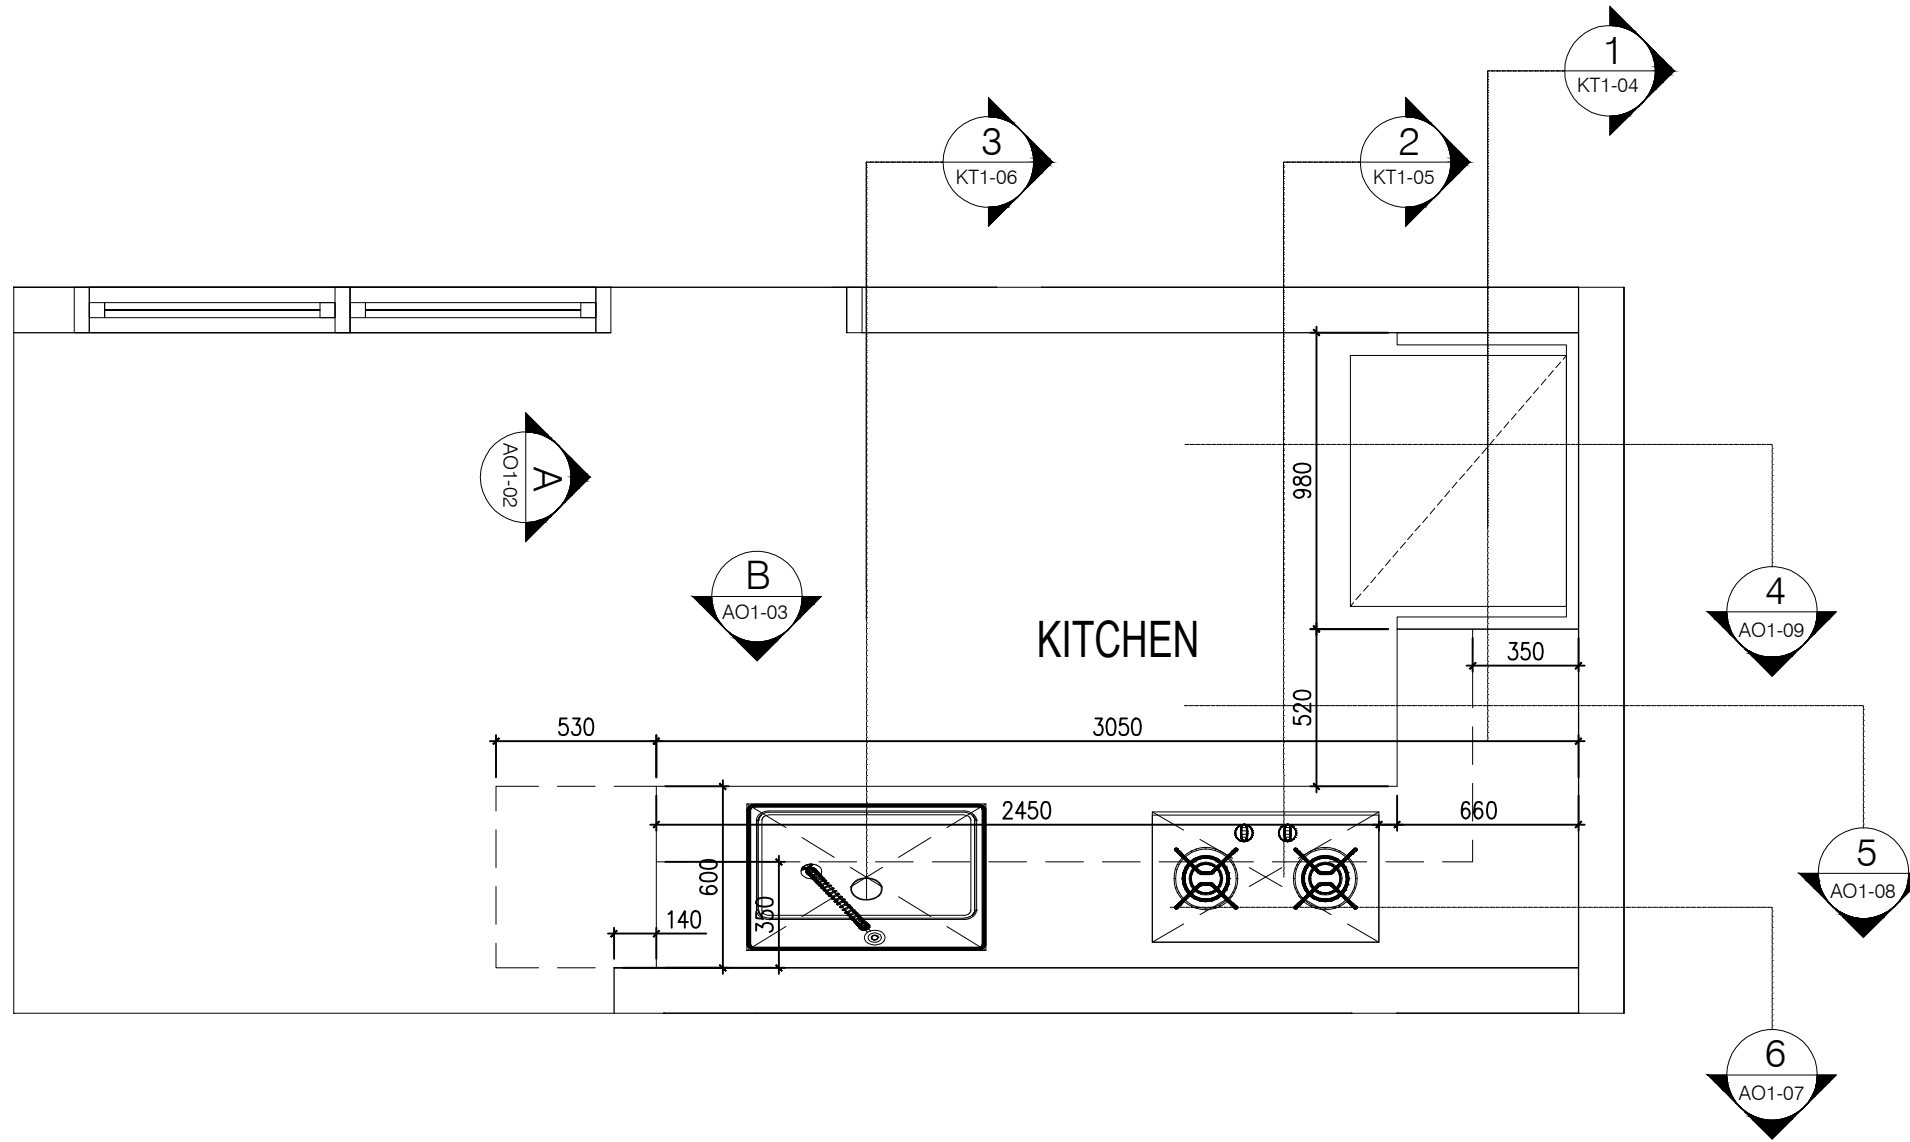

LAYOUT KITCHEN
 SCALE 1:25

DATE ON : 21/11/2025	SCALE : 1 : 25	DRAWN : Citra A.	UNIT : mm	CHECKED BY : Jessica O.	APPROVED BY : Jessica O.
JOB NO :					

SHEET NO : KT1	DRAWING NO : 01
-------------------	--------------------



DUENDE
design + build

Serpong Utara, Tangerang Selatan
+62812 8603 4050
duende.designandbuild@gmail.com

CLIENT :

Mrs. S

CONTRACTOR :

PROJECT :


Vivaldy Residence

LOCATION :

Summarecon Serpong, Tangerang

DRAWING TITLE :

Elevation A Kitchen

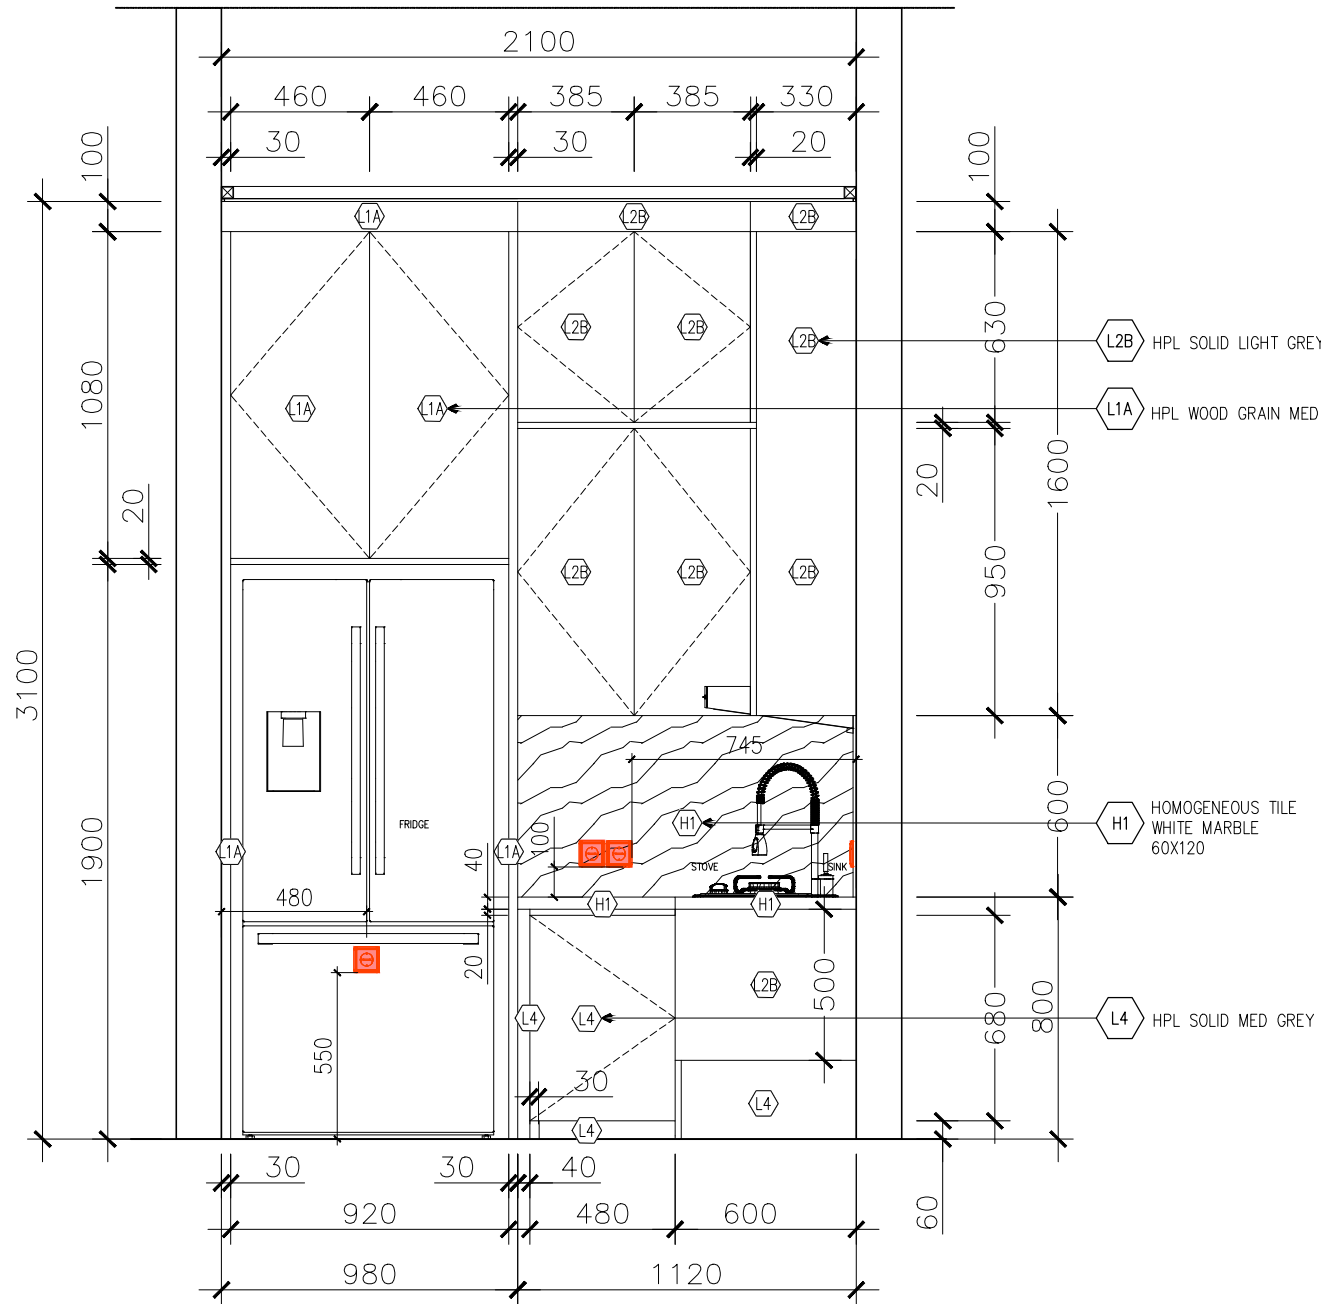

ELEVATION A KITCHEN
SCALE 1:25

DATE ON :	21/11/2025	SCALE :	1 : 25
DRAWN :	Cla A.	UNIT :	mm
CHECKED BY :	Jessica O.	JOB NO :	51
APPROVED BY :	Jessica O.		

SHEET NO :	DRAWING NO :
KT1	02

REV. NO :



Serpong Utara, Tangerang Selatan
+62812 8603 4050
duende.designandbuild@gmail.com

CLIENT :

Mrs. S

CONTRACTOR :

PROJECT :


Vivaldy Residence

LOCATION :

Summarecon Serpong, Tangerang

DRAWING TITLE :

Elevation B Kitchen

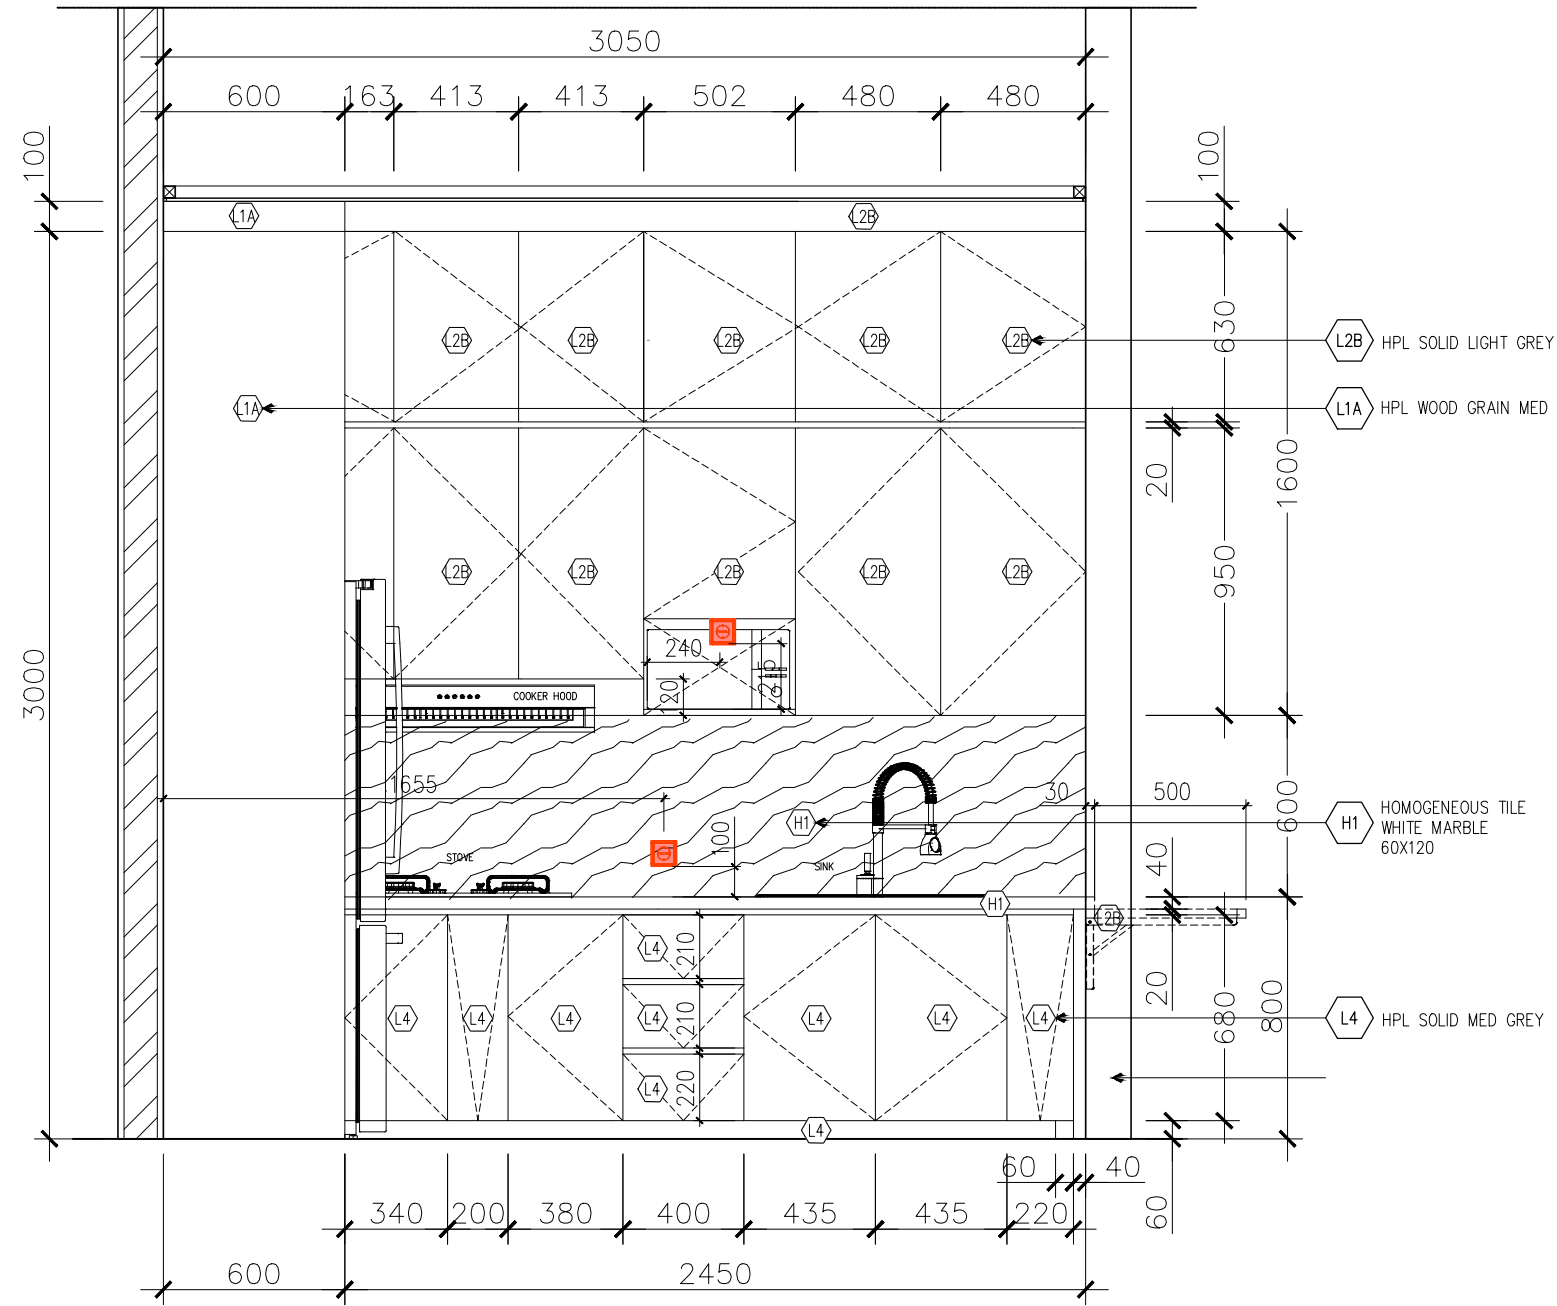

ELEVATION B KITCHEN
SCALE 1:25

DATE ON : 21/11/2025	SCALE : 1 : 25	UNIT : mm	APPROVED BY : Jessica O.
DRAWN : Cla A.			
JOB NO :			CHECKED BY : Jessica O.

SHEET NO : KT1	DRAWING NO : 03
-------------------	--------------------

REV. NO :



DUENDE
design + build
Serpong Utara, Tangerang Selatan
+62812 8603 4050
duende.designandbuild@gmail.com

CLIENT :

Mrs. S


CONTRACTOR :

PROJECT : **Vivaldy Residence**
LOCATION : **Summarecon Serpong, Tangerang**

PROJECT :

Section 1 Kitchen

DRAWING TITLE :

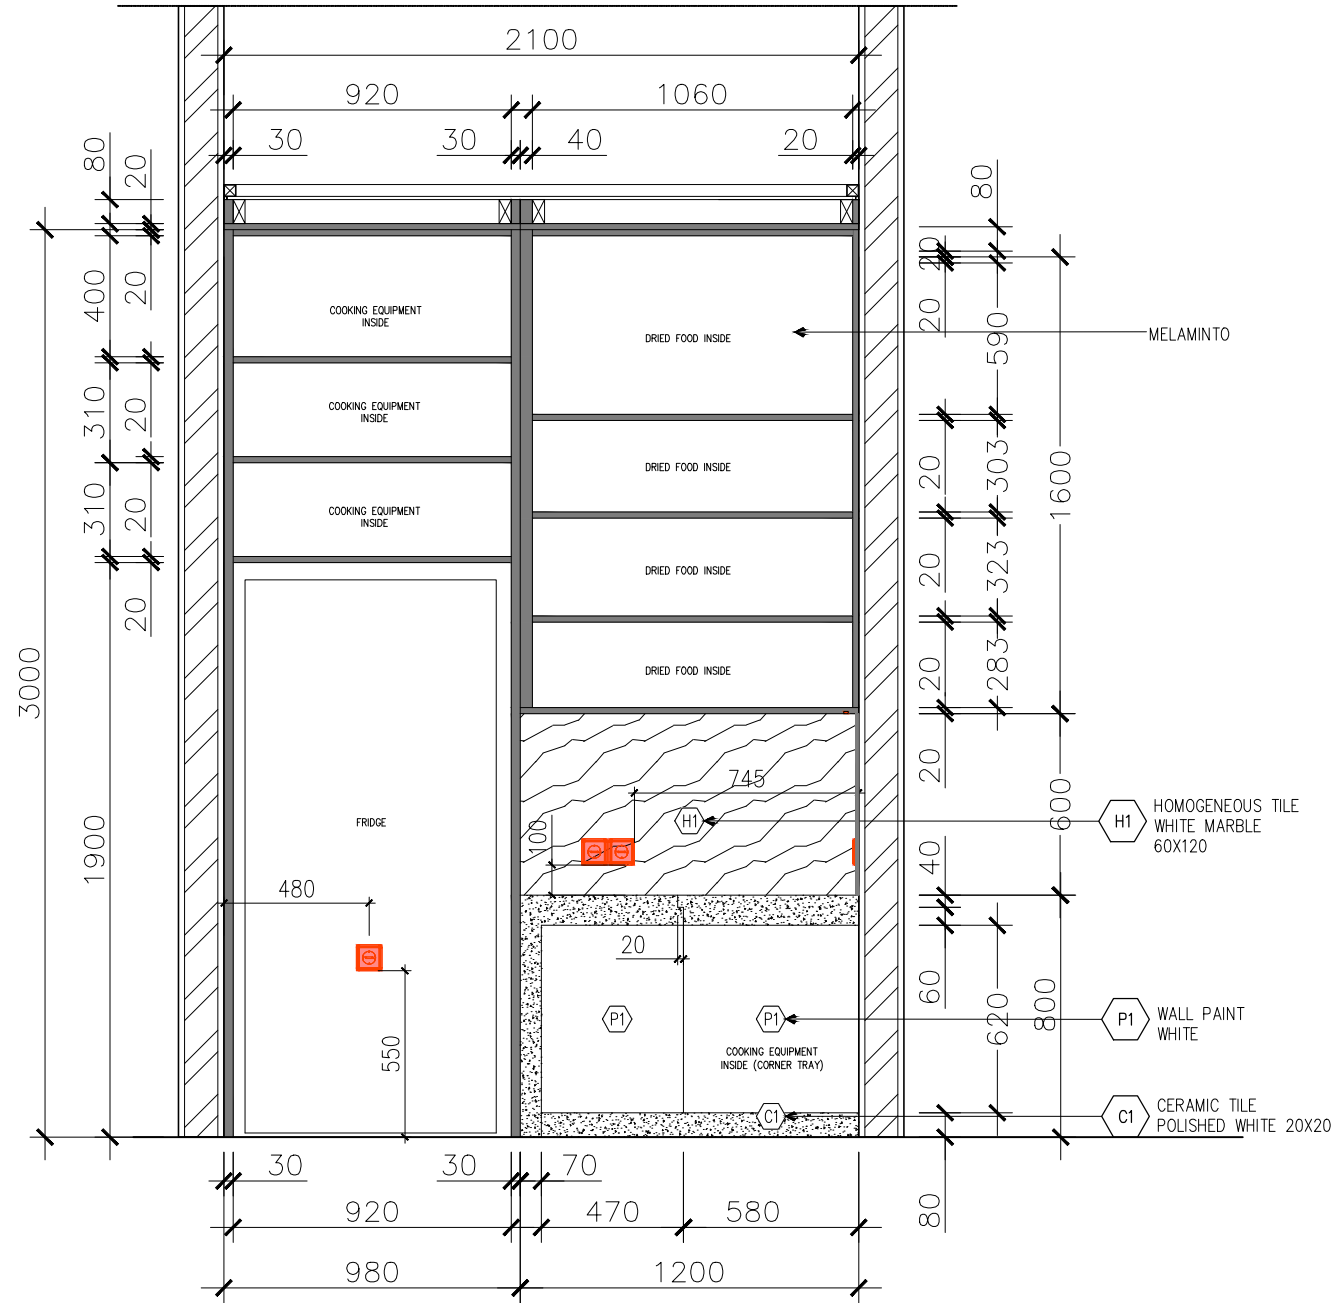


SECTION 1 KITCHEN
SCALE 1:25

DATE ON : 21/11/2025	SCALE : 1 : 25	DRAWN : Olga A.	UNIT : mm	JOB NO : 51
CHECKED BY : Jessica O.			APPROVED BY : Jessica O.	

SHEET NO : KT1	DRAWING NO : 04
-------------------	--------------------

REV. NO :

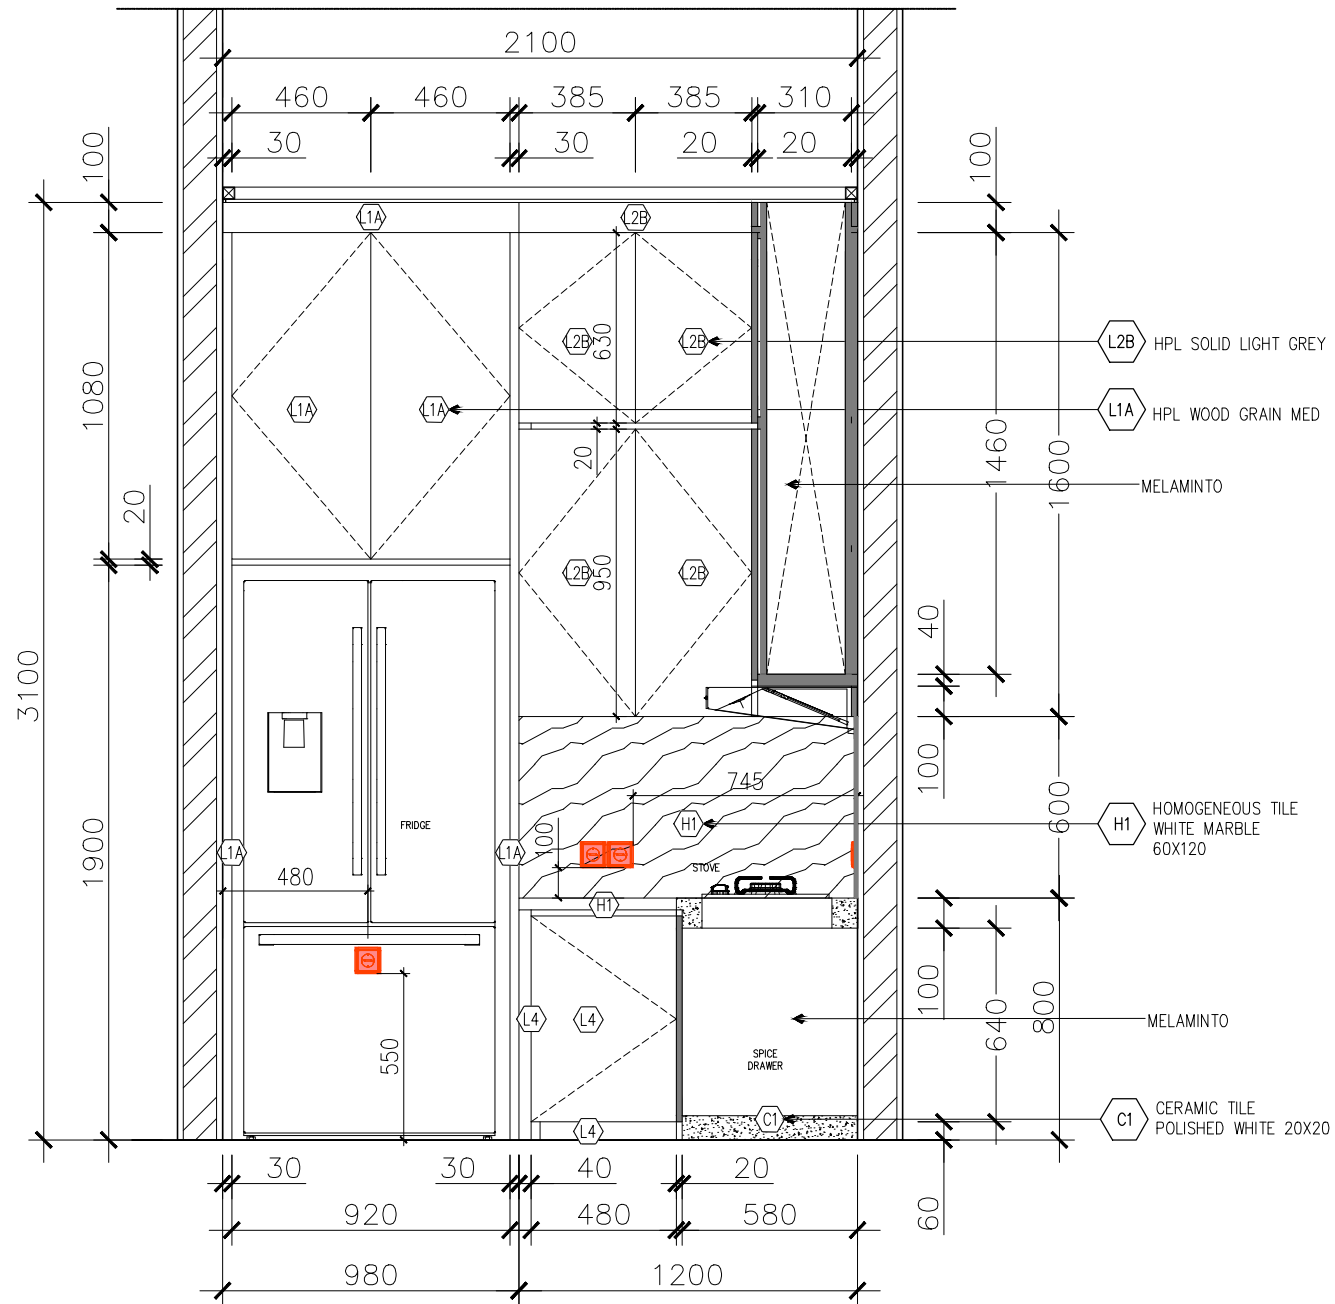

SECTION 2 KITCHEN
SCALE 1:25

CONTRACTOR :

PROJECT :	Vivaldy Residence
LOCATION :	Summarecon Serpong, Tangerang

DRAWING TITLE :

Section 2 Kitchen

DATE ON :	21/11/2025	SCALE :	1 : 25
DRAWN :	Cla A.	UNIT :	mm
JOB NO :		CHECKED BY :	Jessica O.
		APPROVED BY :	Jessica O.

SHEET NO :	DRAWING NO :
KT1	05



DUENDE
design + build

Serpong Utara, Tangerang Selatan
+62812 8603 4050
duende.designandbuild@gmail.com

CLIENT :

Mrs. S

CONTRACTOR :

PROJECT :


Vivaldy Residence

LOCATION :

Summarecon Serpong, Tangerang

DRAWING TITLE :

Section 3 Kitchen

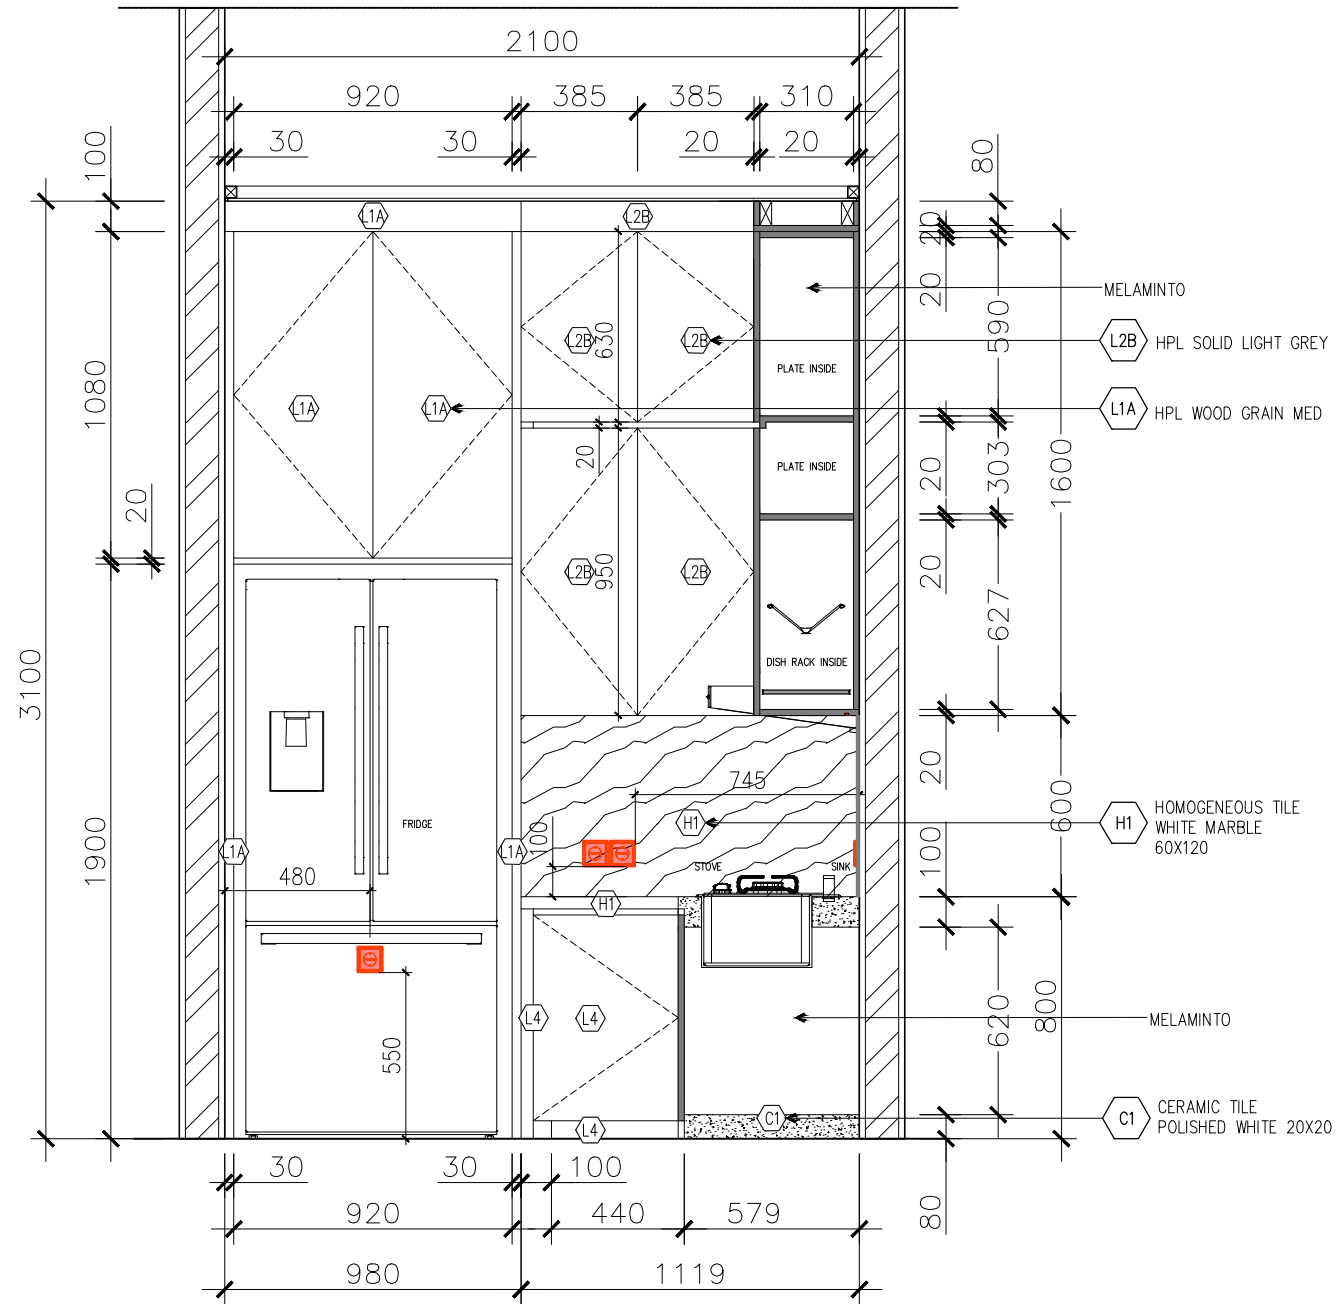

SECTION 3 KITCHEN
SCALE 1:25

DATE ON :	21/11/2025	SCALE :	1 : 25
DRAWN :	Cla A.	UNIT :	mm
JOB NO :		CHECKED BY :	Jessica O.
		APPROVED BY :	Jessica O.

SHEET NO :	DRAWING NO :
KT1	06

REV. NO :



DUENDE
design + build

Serpong Utara, Tangerang Selatan
+62812 8603 4050
duende.designandbuild@gmail.com

CLIENT :

Mrs. S

CONTRACTOR :


Vivaldy Residence

Summarecon Serpong, Tangerang

PROJECT :

Section 4 Kitchen

DRAWING TITLE :

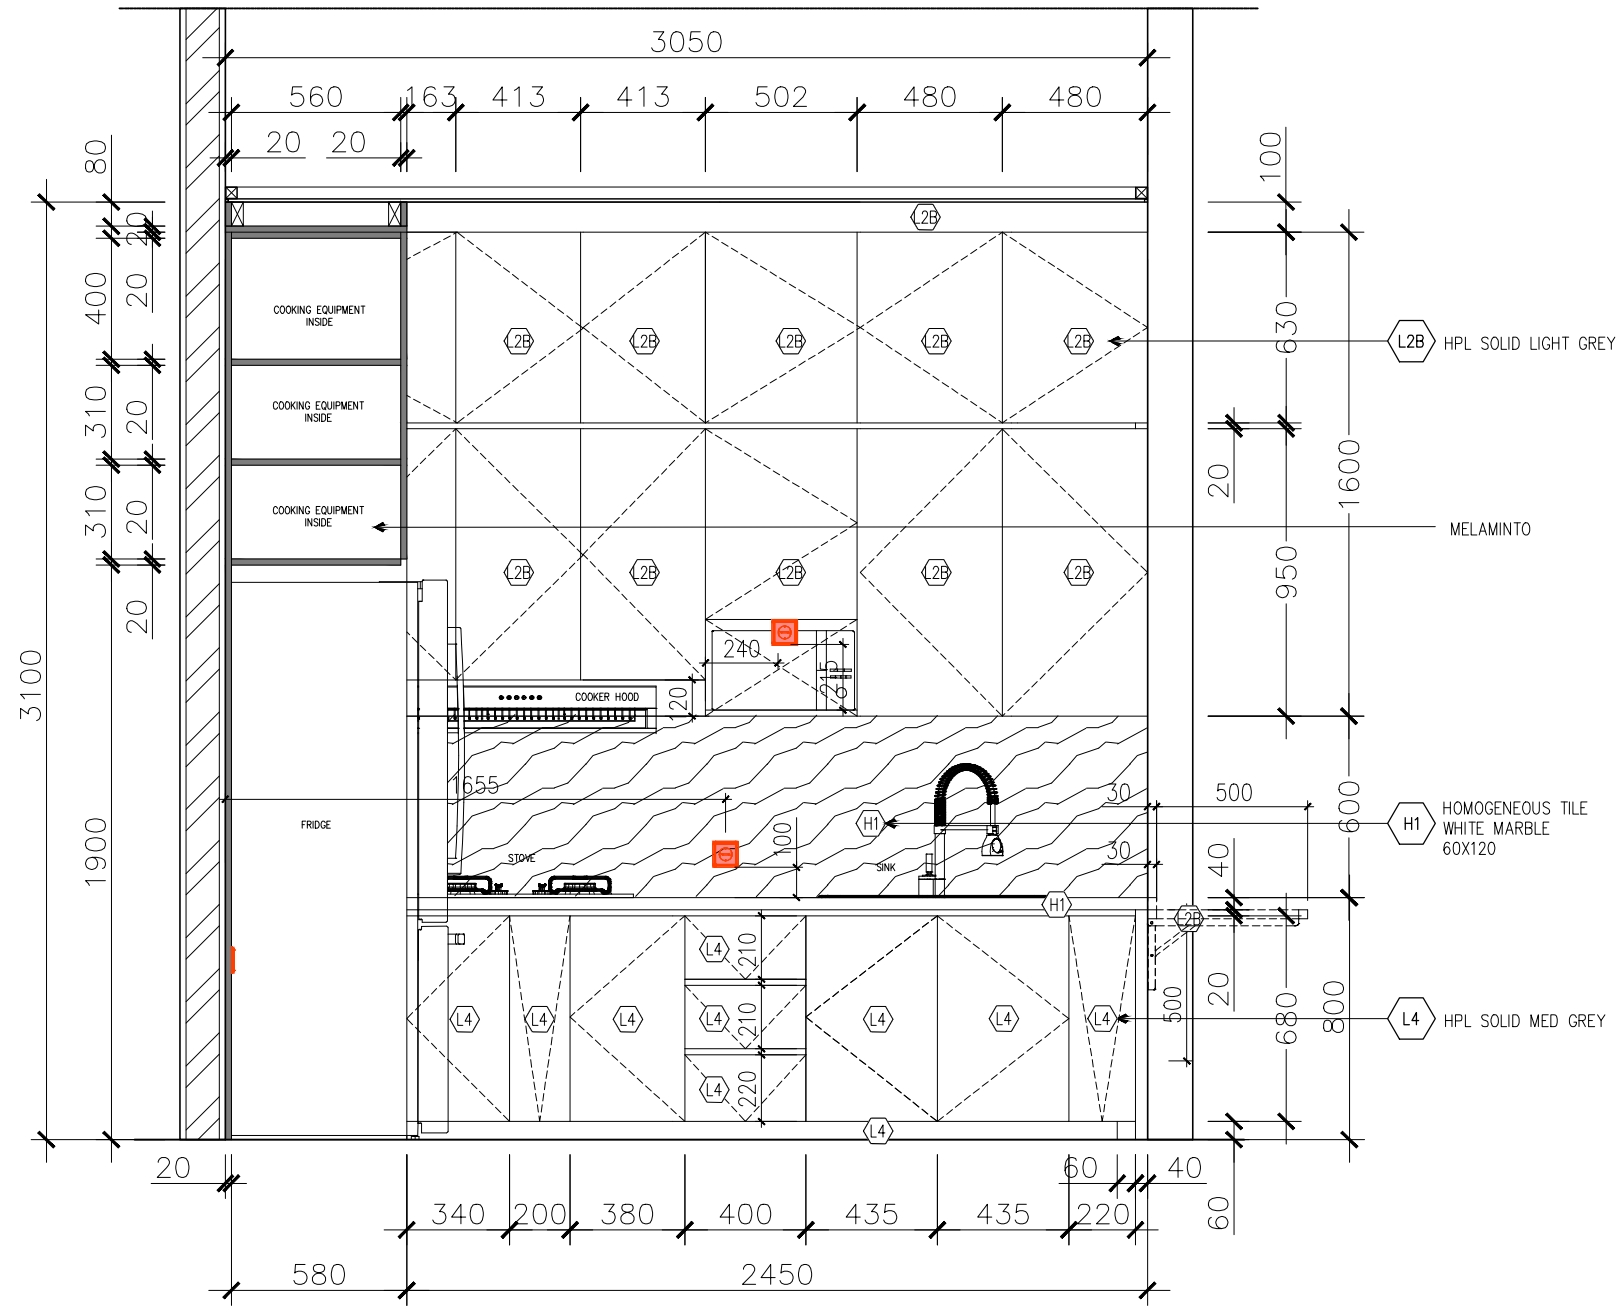

SECTION 4 KITCHEN
SCALE 1:25

DATE ON :	21/11/2025	SCALE :	1 : 25
DRAWN :	Cla A.	UNIT :	mm
JOB NO :		CHECKED BY :	Jessica O.
		APPROVED BY :	Jessica O.

SHEET NO :	DRAWING NO :
KT1	07

REV. NO :



DUENDE
design + build

Serpong Utara, Tangerang Selatan
+62812 8603 4050
duende.designandbuild@gmail.com

CLIENT :

Mrs. S


CONTRACTOR :

PROJECT :
Vivaldy Residence

LOCATION :
Summarecon Serpong, Tangerang

DRAWING TITLE :

Section 5 Kitchen

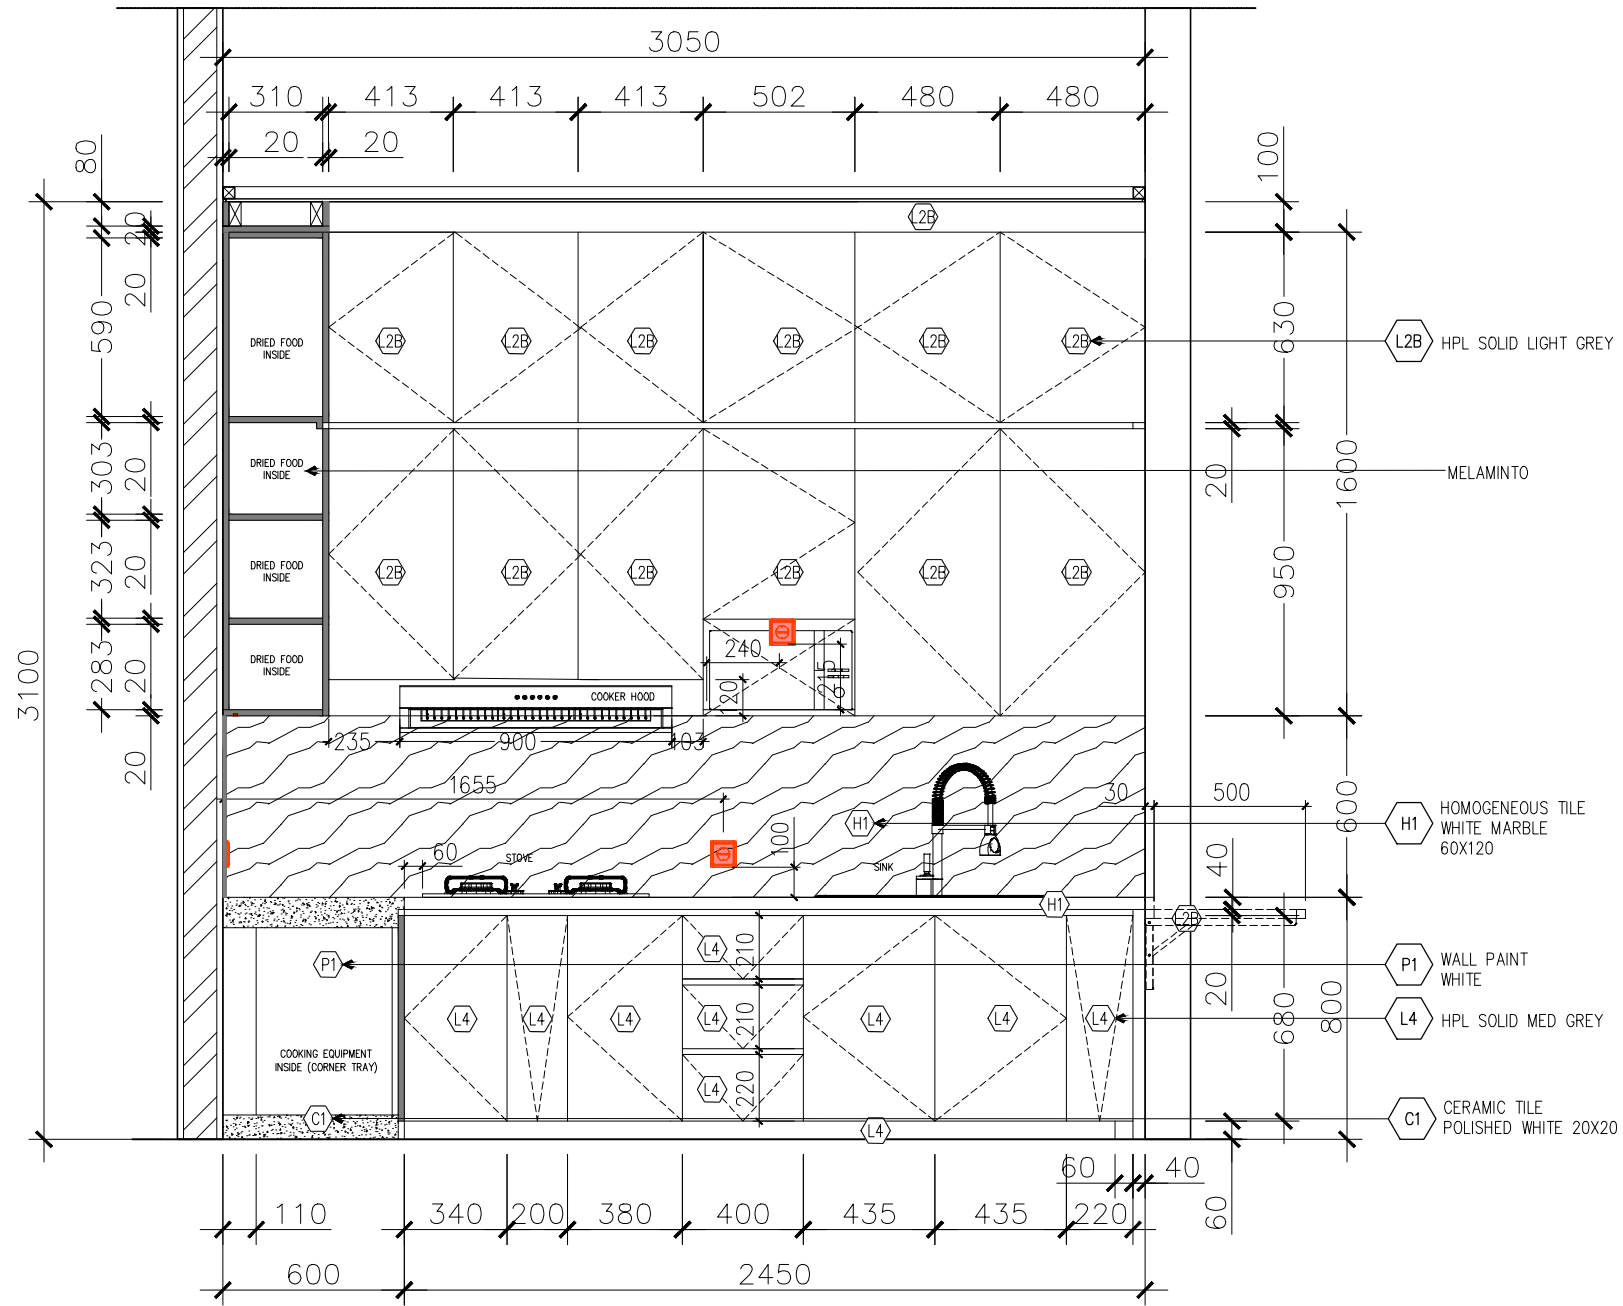


SECTION 5 KITCHEN
SCALE 1:25

DATE ON :	21/11/2025	SCALE :	1 : 25
DRAWN :	Olga A.	UNIT :	mm
JOB NO :		CHECKED BY :	Jessica O.
		APPROVED BY :	Jessica O.

SHEET NO :	DRAWING NO :
KT1	08

REV. NO :

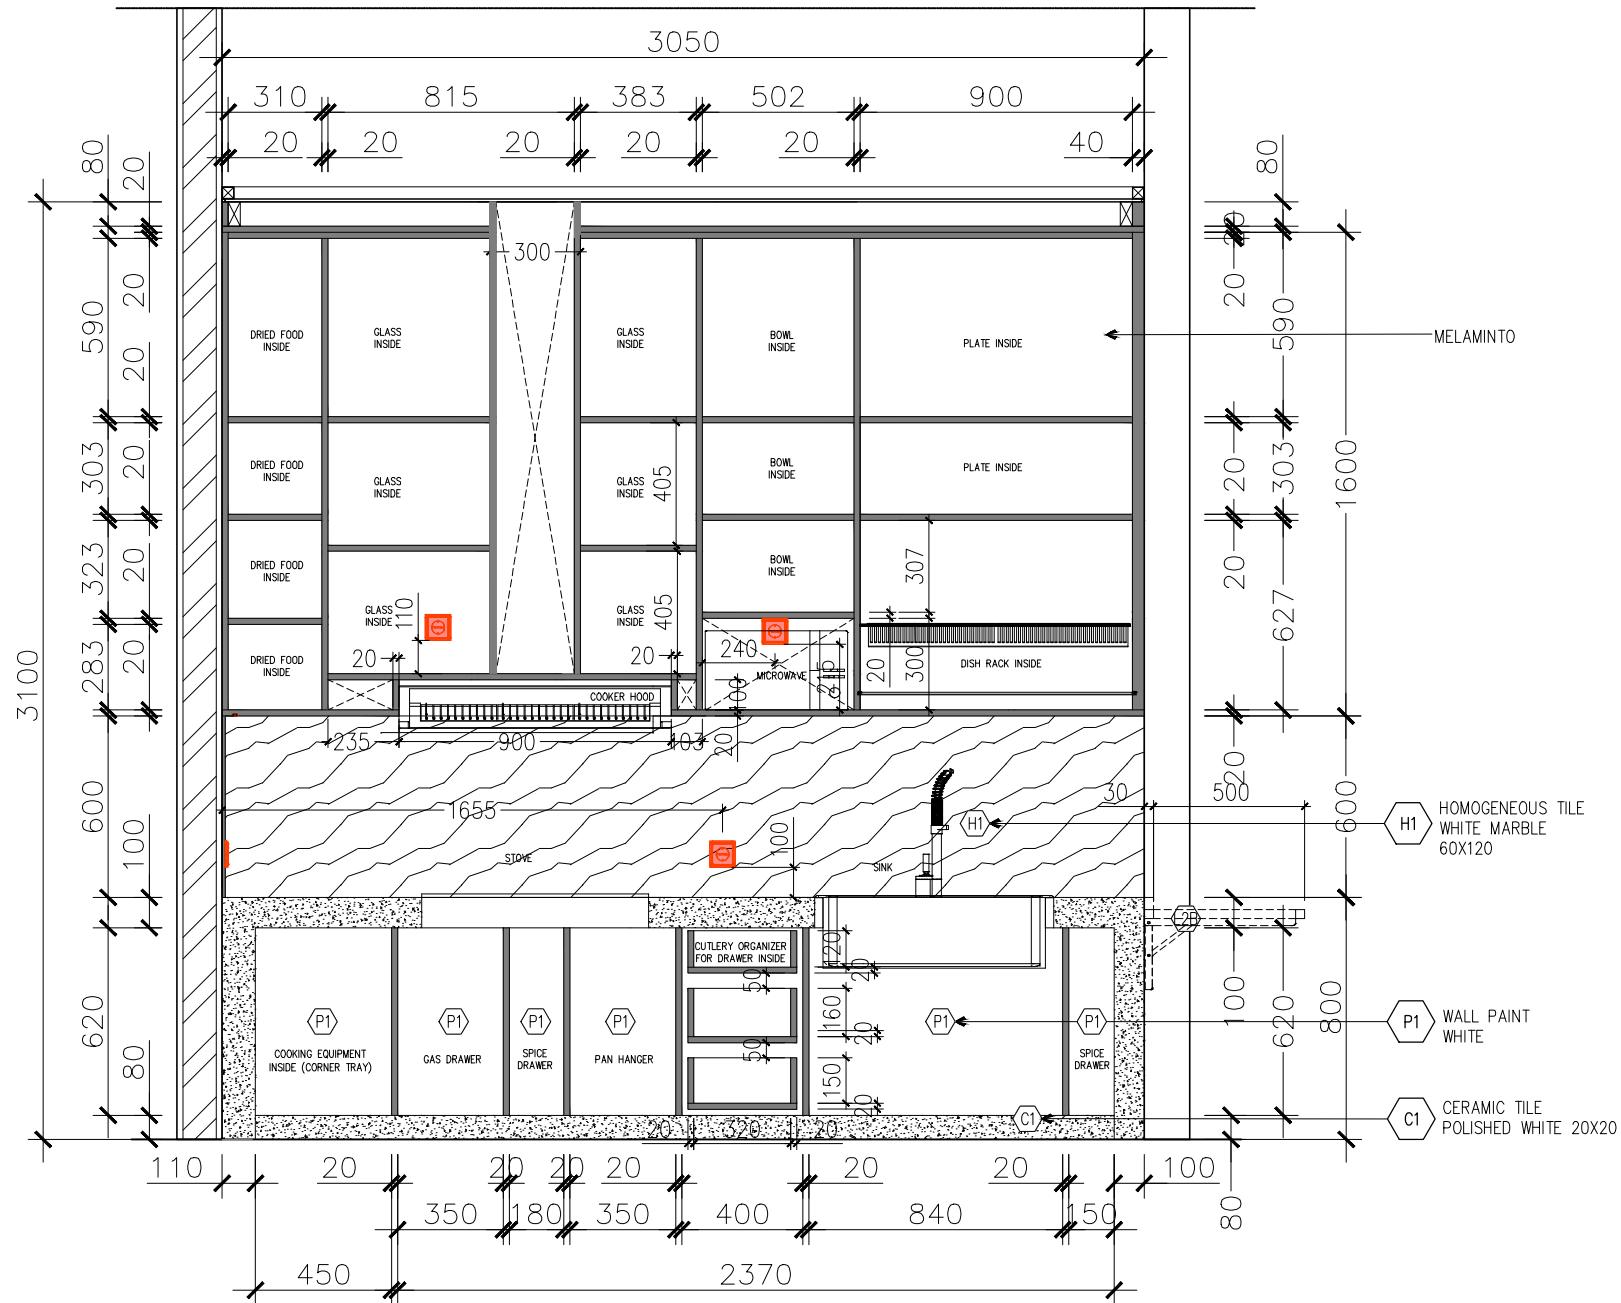

SECTION 6 KITCHEN
SCALE 1:25


CONTRACTOR :
Vivaldy Residence
 LOCATION :
Summarecon Serpong, Tangerang

DRAWING TITLE :
Section 6 Kitchen

DATE ON : 21/11/2025	SCALE : 1 : 25	UNIT : mm	APPROVED BY : Jessica O.
DRAWN : Olga A.	CHECKED BY : Jessica O.	JOB NO : 51	

SHEET NO : KT1	DRAWING NO : 09
-------------------	--------------------

CLIENT :
Mrs. S

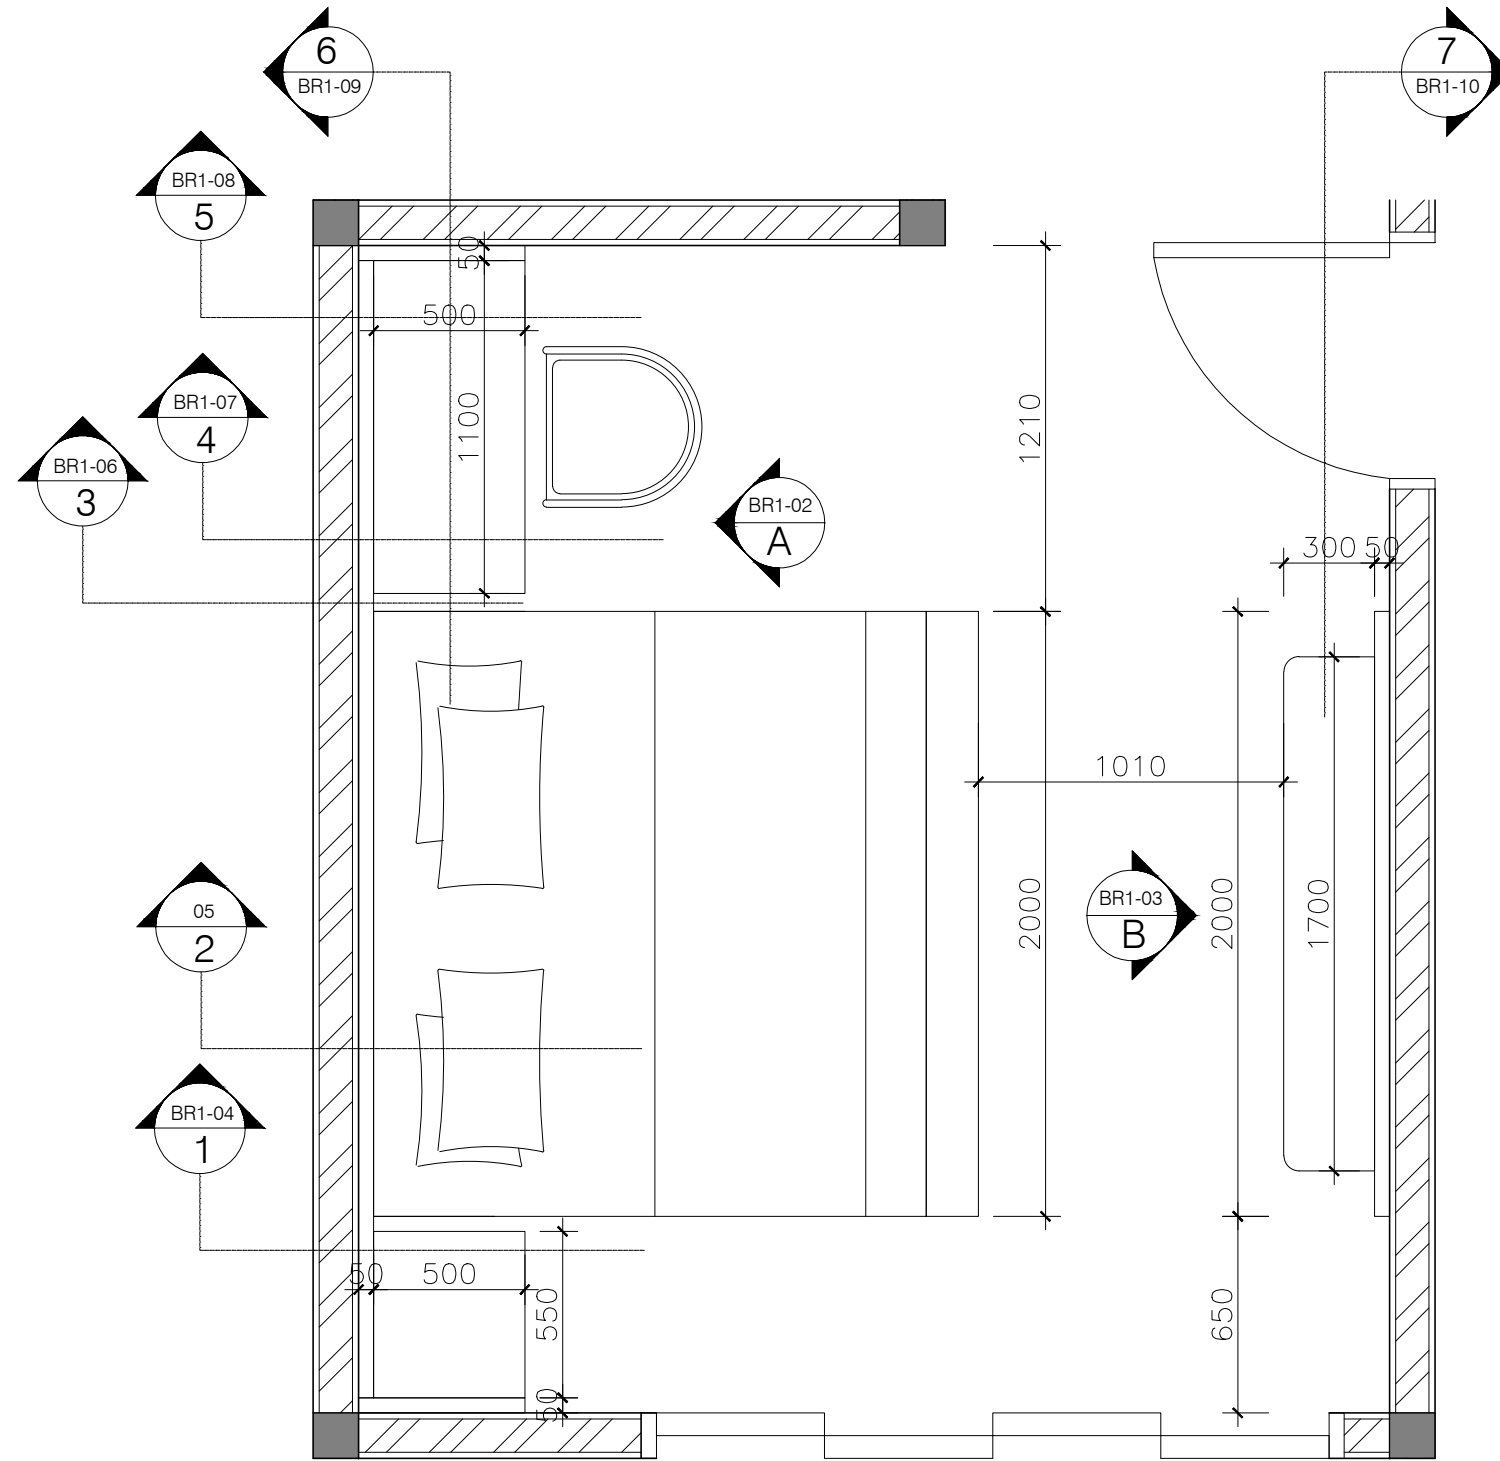

Layout Master Bedroom
 Scale 1:25

CONTRACTOR :
 PROJECT : **Vivaldy Residence**
 LOCATION : **Summarecon Serpong, Tangerang**

DRAWING TITLE :
Layout Master Bedroom

DATE ON : 21/11/2025	SCALE : 1 : 25	DRAWN : Linda Walyu L. S.	UNIT : mm	JOB NO : 51	CHECKED BY : Jessica O.	APPROVED BY : Jessica O.
-------------------------	-------------------	------------------------------	--------------	----------------	----------------------------	-----------------------------

SHEET NO : BR1	DRAWING NO : 01
-------------------	--------------------



DUENDE
design + build

Serpong Utara, Tangerang Selatan
+62812 8603 4050
duende.designandbuild@gmail.com

CLIENT :

Mrs. S

CONTRACTOR :

PROJECT :


Vivaldy Residence

LOCATION :

Summarecon Serpong, Tangerang

DRAWING TITLE :

Elevation A Master Bedroom

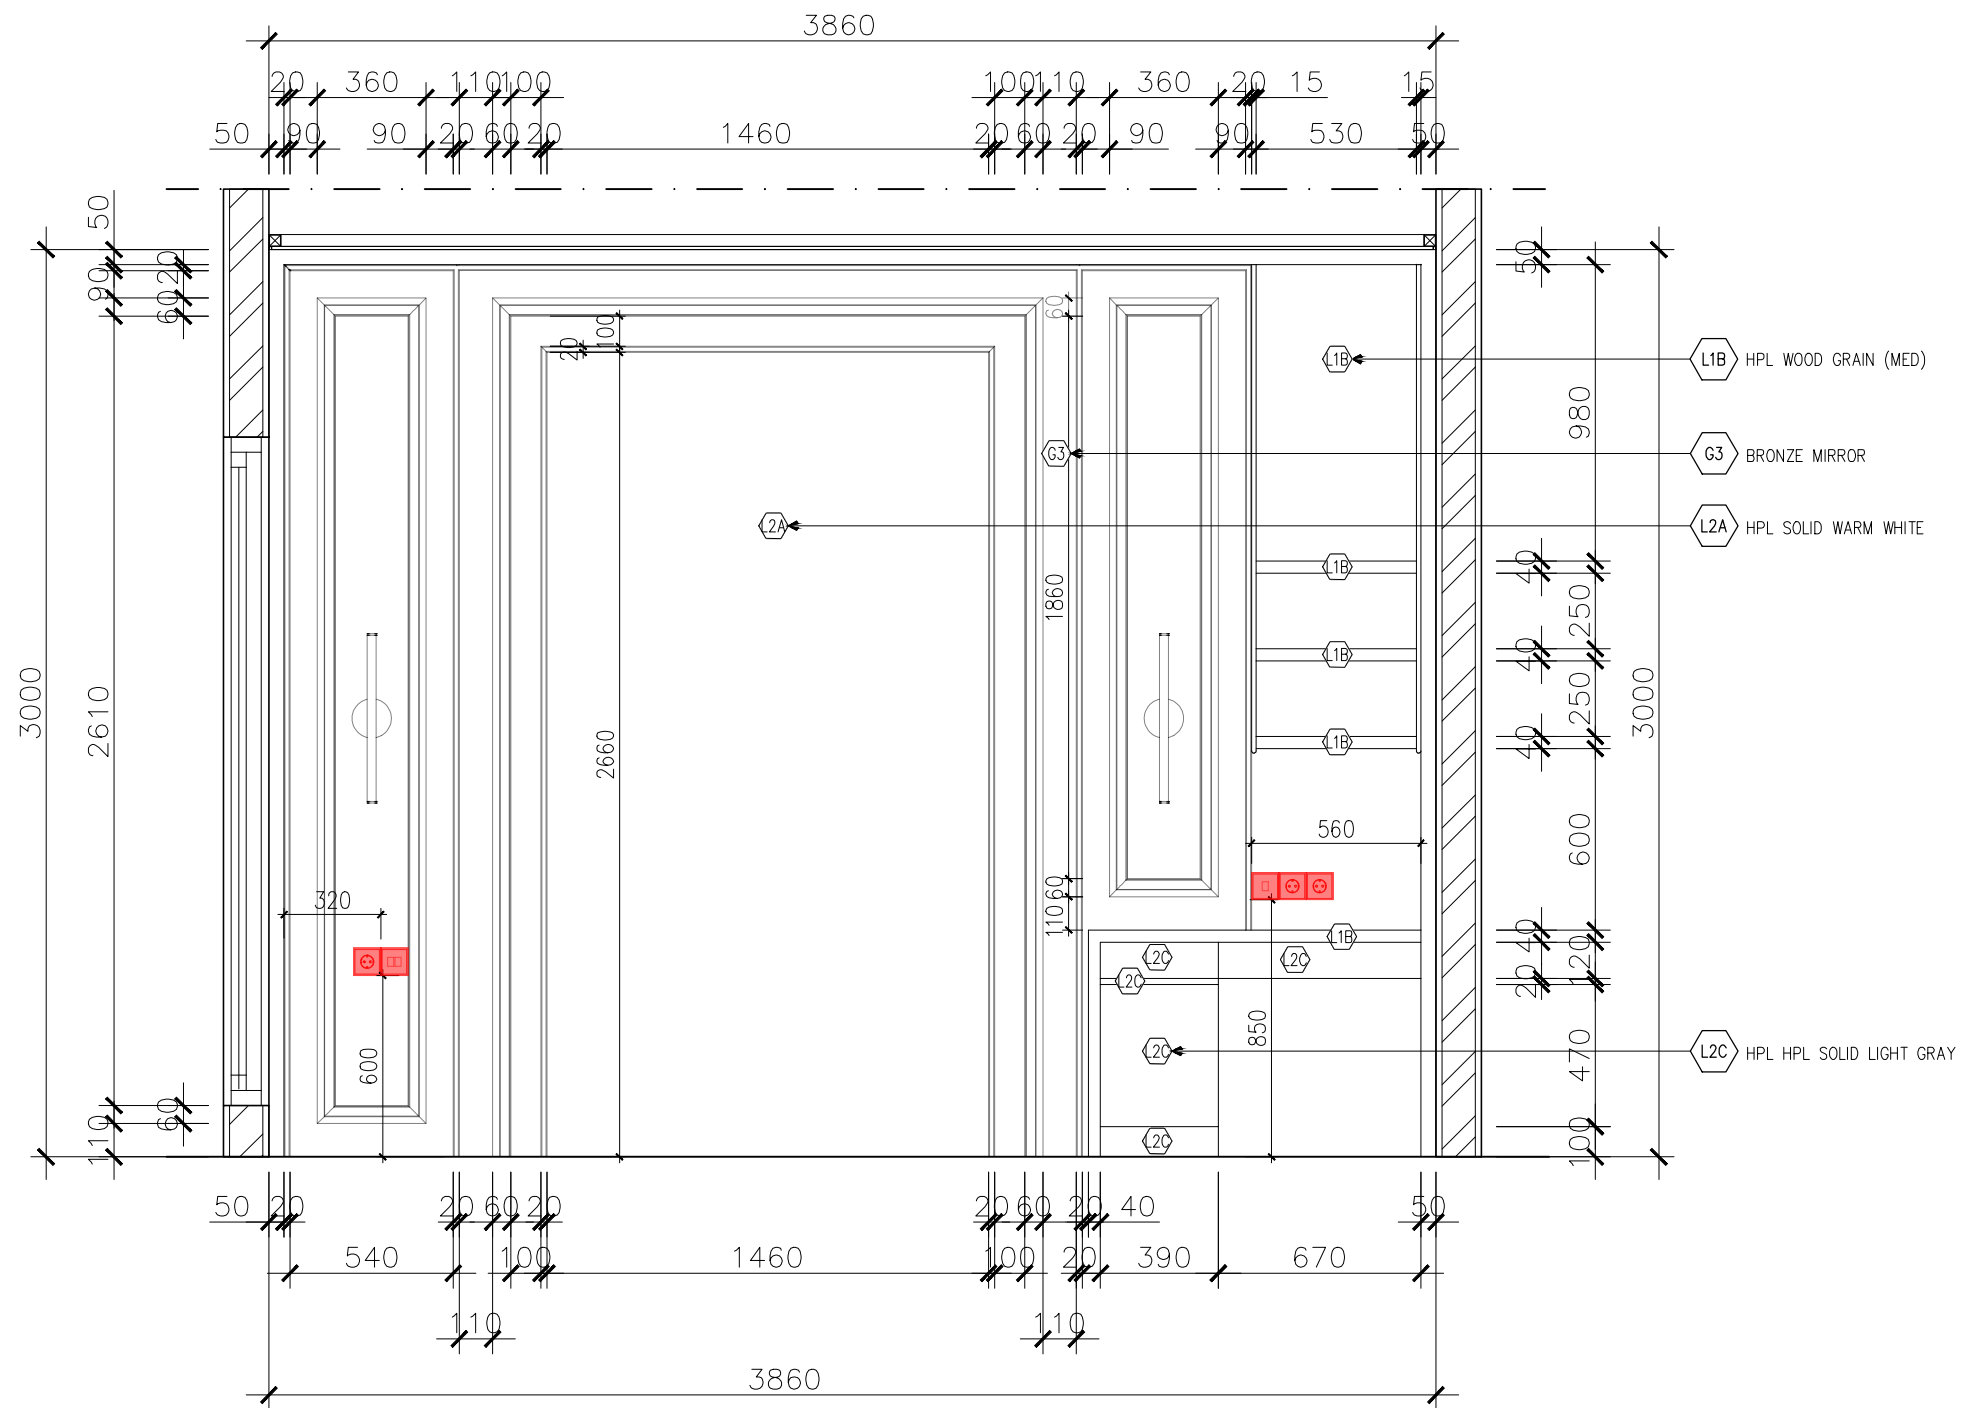

Elevation A
Scale 1:25

DATE ON :	21/11/2025	SCALE :	1 : 25
DRAWN :	Linda Watiyul L. S.	UNIT :	mm
JOB NO :			51
CHECKED BY :	Jessica O.	APPROVED BY :	Jessica O.



Serpong Utara, Tangerang Selatan
+62812 8603 4050
duende.designandbuild@gmail.com

CLIENT :

Mrs. S

CONTRACTOR :

PROJECT :


Vivaldy Residence

LOCATION :

Summarecon Serpong, Tangerang

DRAWING TITLE :

Elevation B Master Bedroom

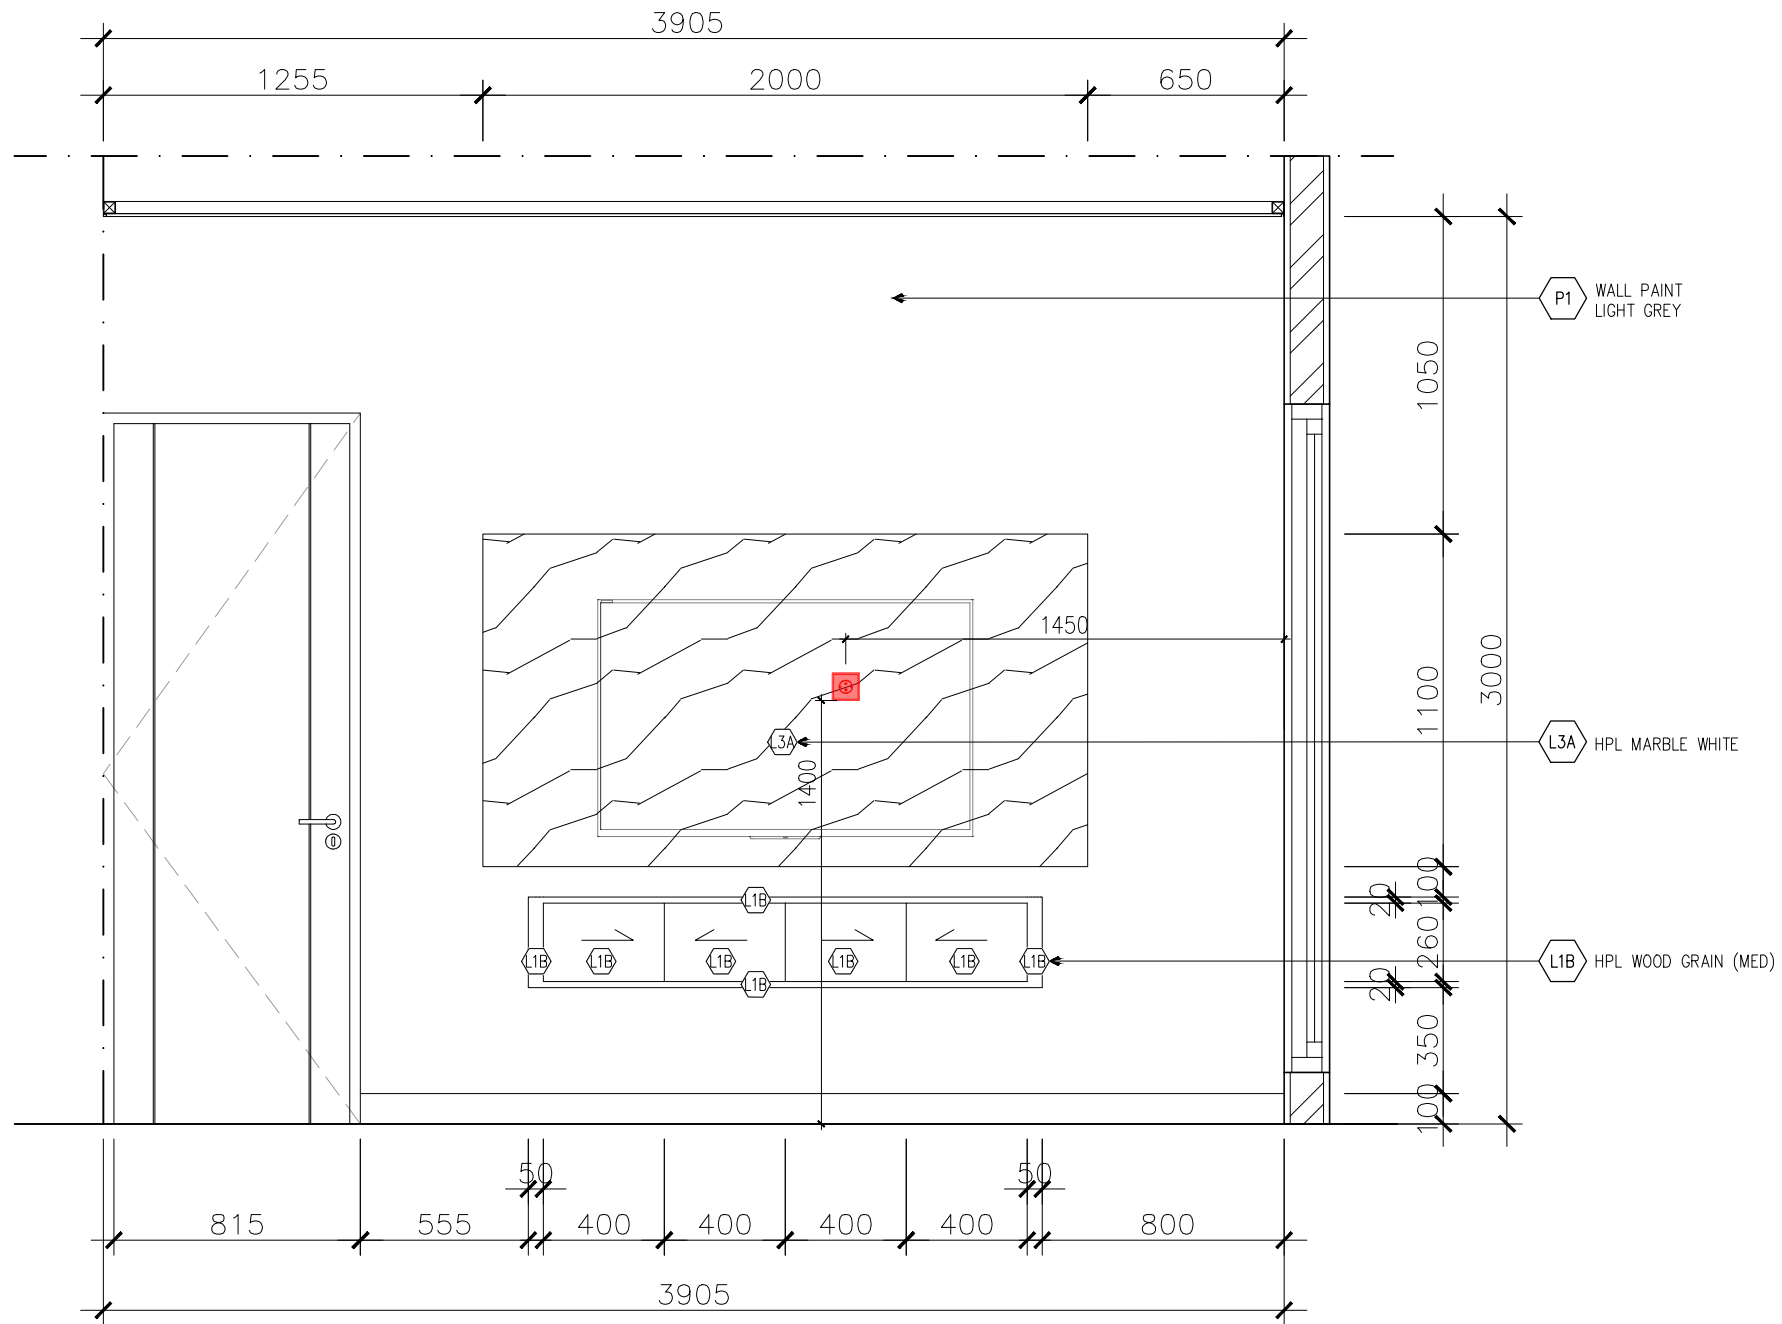

Elevation B
Scale 1:25

DATE ON : 21/11/2025	SCALE : 1 : 25	DRAWN : Linda Watiyul L. S.	UNIT : mm	JOB NO :	51
CHECKED BY : Jessica O.			APPROVED BY : Jessica O.		

SHEET NO : BR1	DRAWING NO : 03
-------------------	--------------------

REV. NO :



Serpong Utara, Tangerang Selatan
+62812 8603 4050
duende.designandbuild@gmail.com

CLIENT :

Mrs. S

CONTRACTOR :

PROJECT :

Vivaldy Residence

LOCATION :

Summarecon Serpong, Tangerang


DRAWING TITLE :

Section 1 Master Bedroom

DATE ON :	21/11/2025	SCALE :	1 : 25
DRAWN :	Linda Walyu L. S.	UNIT :	mm
JOB NO :			51
CHECKED BY :	Jessica O.	APPROVED BY :	Jessica O.

SHEET NO :	BR1	DRAWING NO :	04
------------	-----	--------------	----

REV. NO :

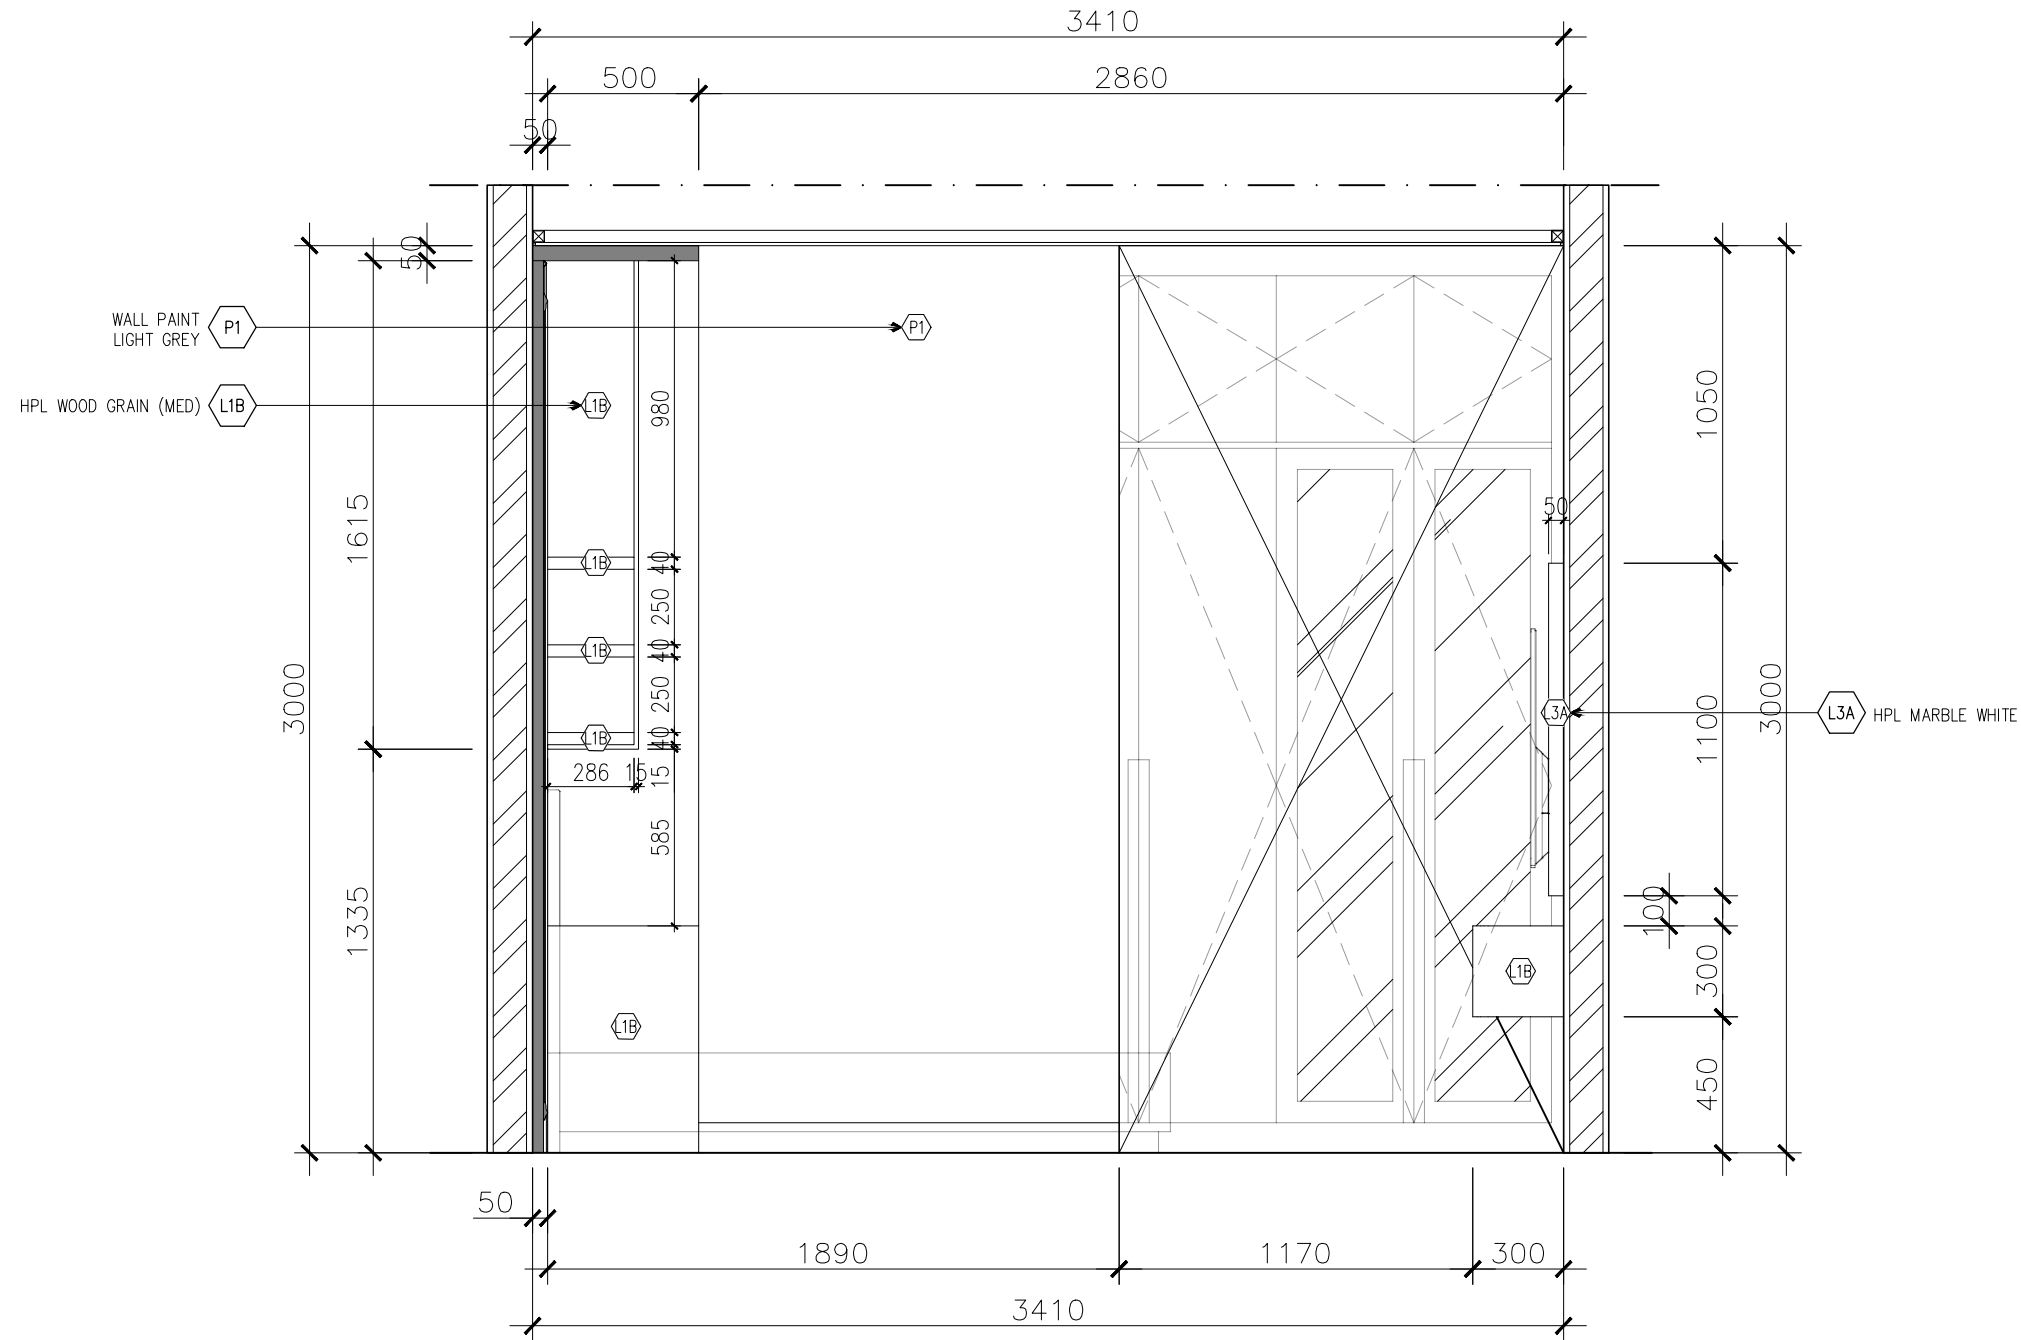

Section 1
Scale 1:25



DUENDE
design + build

Serpong Utara, Tangerang Selatan
+62812 8603 4050
duende.designandbuild@gmail.com

CLIENT :

Mrs. S

CONTRACTOR :

PROJECT :

Vivaldy Residence

LOCATION :

Summarecon Serpong, Tangerang


DRAWING TITLE :

Section 2 Master Bedroom

DATE ON :	21/11/2025	SCALE :	1 : 25
DRAWN :	Linda Walyu L. S.	UNIT :	mm
JOB NO :		CHECKED BY :	Jessica O.
		APPROVED BY :	Jessica O.

SHEET NO :	BR1	DRAWING NO :	05
------------	-----	--------------	----

REV. NO :

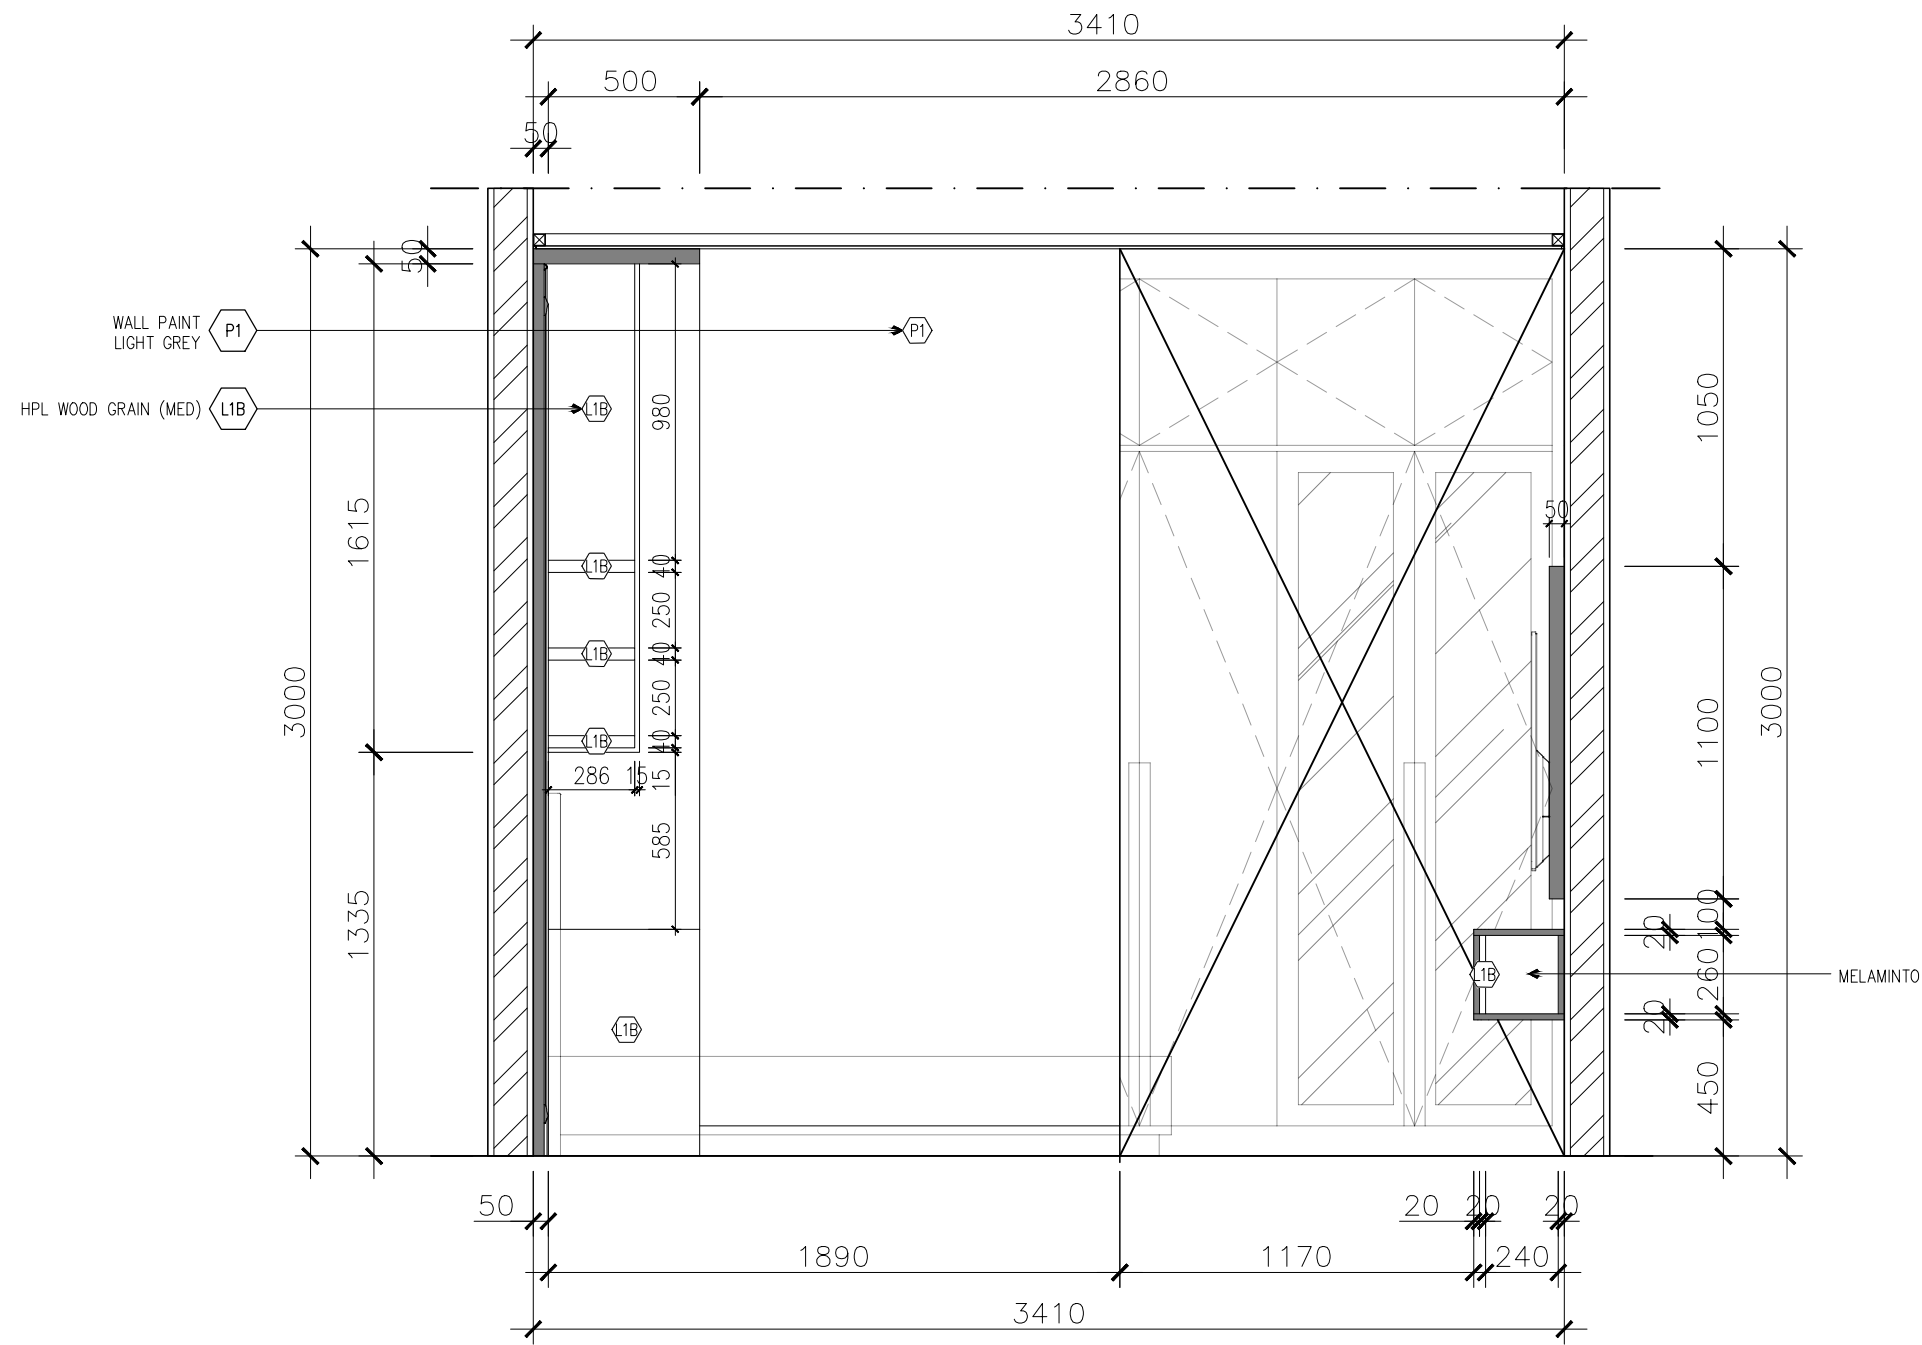



DUENDE
design + build

Serpong Utara, Tangerang Selatan
+62812 8603 4050
duende.designandbuild@gmail.com

CLIENT :

Mrs. S

CONTRACTOR :

PROJECT :


Vivaldy Residence

LOCATION :

Summarecon Serpong, Tangerang

DRAWING TITLE :

Section 3 Master Bedroom

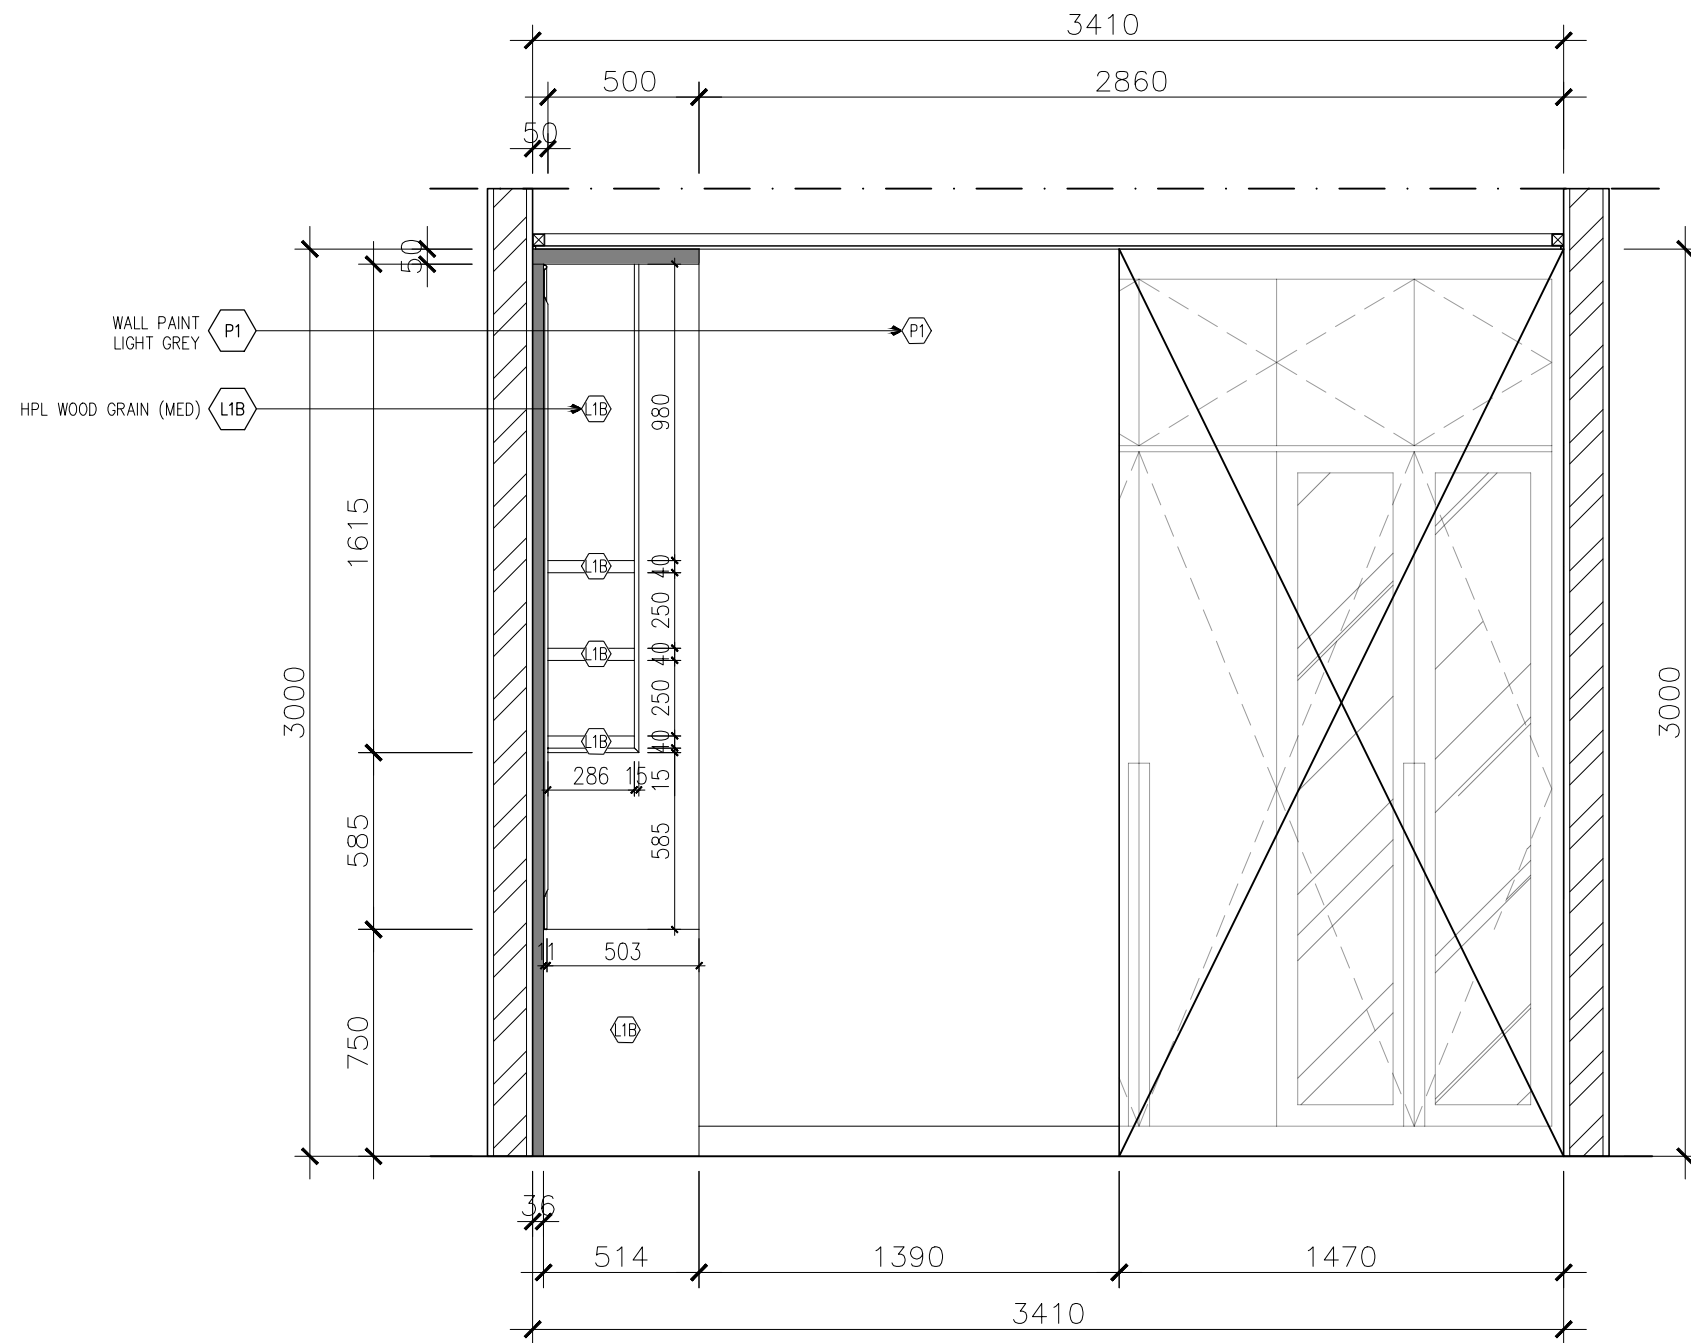

Section 3
Scale 1:25

DATE ON :	21/11/2025	SCALE :	1 : 25
DRAWN :	Linda Walyu L. S.	UNIT :	mm
JOB NO :			51
CHECKED BY :	Jessica O.	APPROVED BY :	Jessica O.

SHEET NO :	BR1	DRAWING NO :	06
------------	-----	--------------	----

REV. NO :



DUENDE
design + build

Serpong Utara, Tangerang Selatan
+62812 8603 4050
duende.designandbuild@gmail.com

CLIENT :

Mrs. S

CONTRACTOR :

PROJECT :


Vivaldy Residence

LOCATION :

Summarecon Serpong, Tangerang

DRAWING TITLE :

Section 4 Master Bedroom

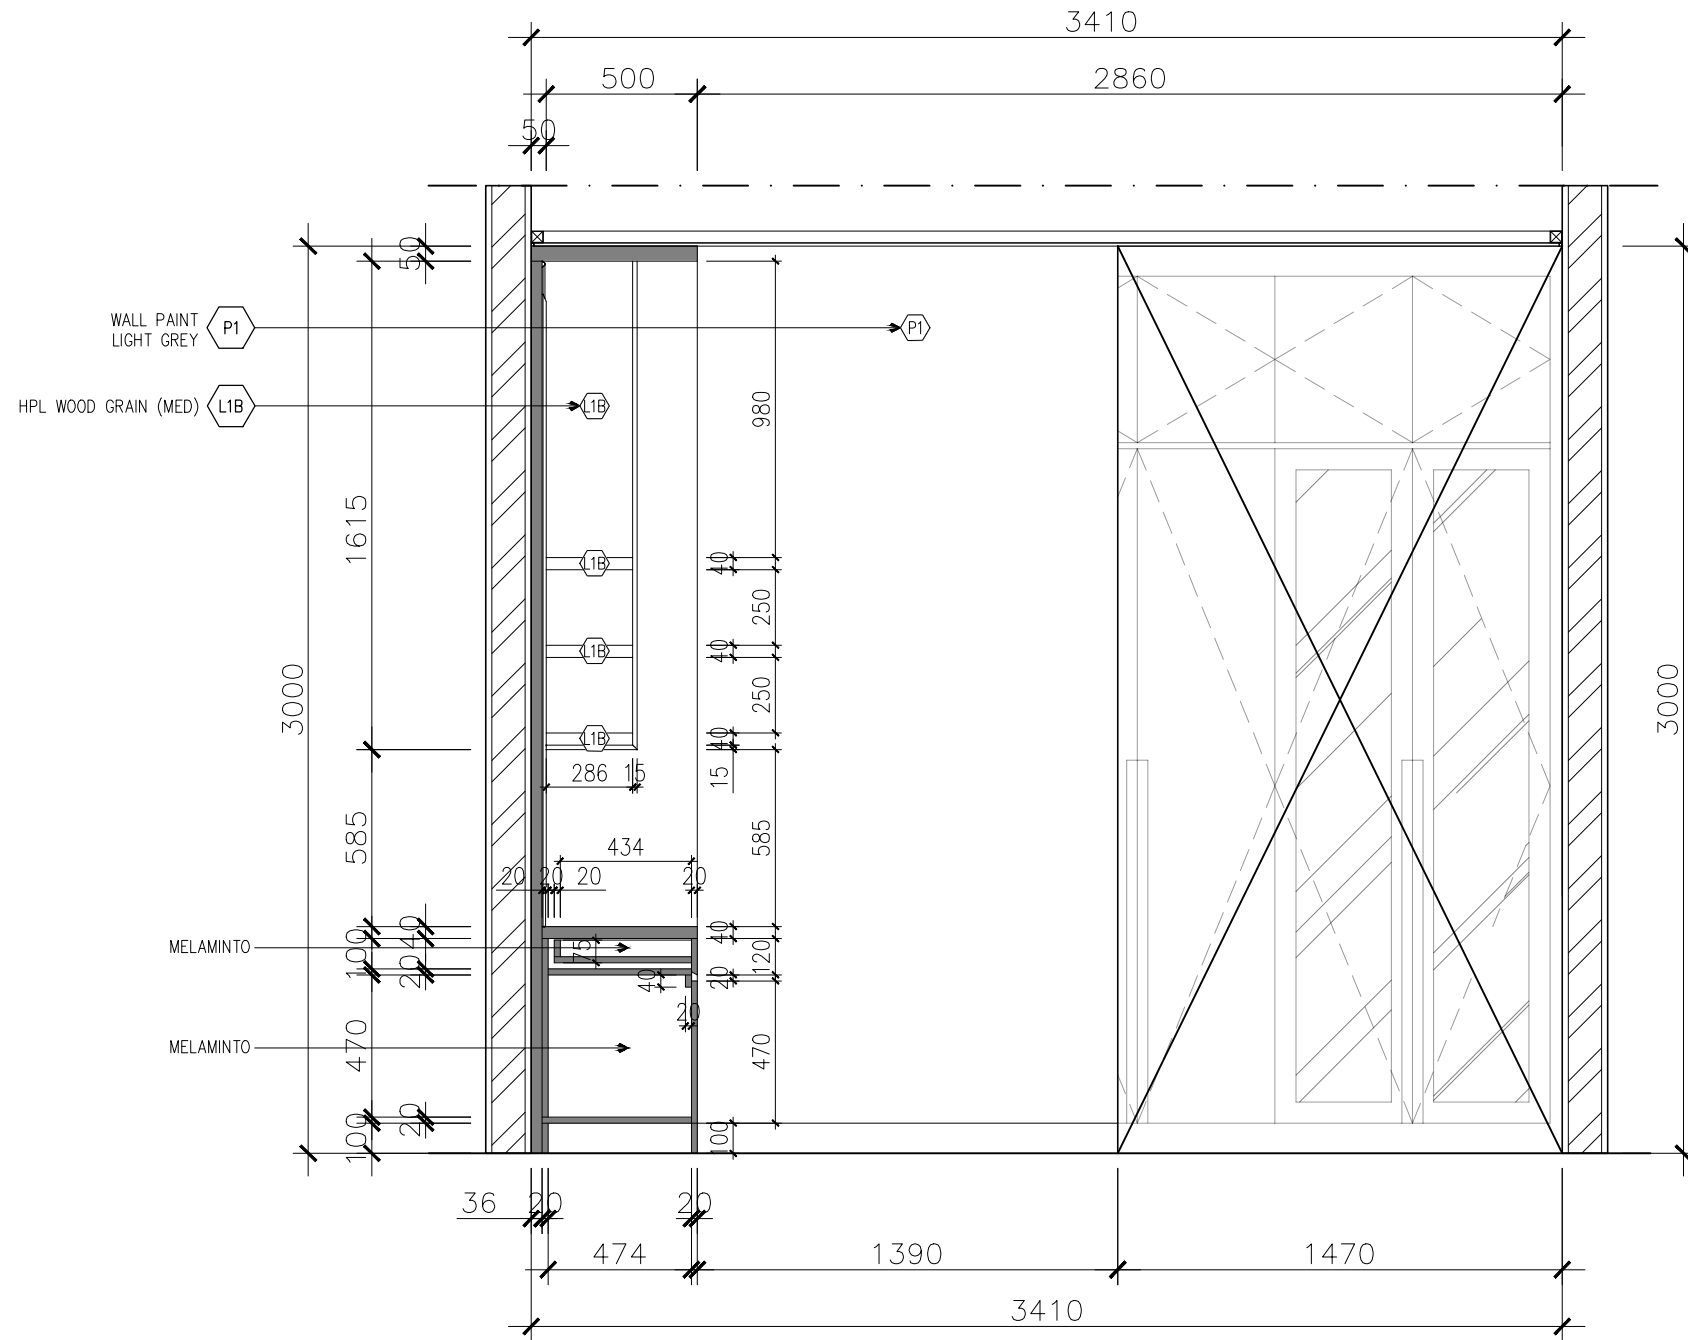

DATE ON :	21/11/2025	SCALE :	1 : 25
DRAWN :	Linda Walyu L. S.	UNIT :	mm
JOB NO :		CHECKED BY :	Jessica O.
		APPROVED BY :	Jessica O.

SHEET NO :	DRAWING NO :
BR1	07

REV. NO :



DUENDE
design + build

Serpong Utara, Tangerang Selatan
+62812 8603 4050
duende.designandbuild@gmail.com

CLIENT :

Mrs. S

CONTRACTOR :

PROJECT :


Vivaldy Residence

LOCATION :

Summarecon Serpong, Tangerang

DRAWING TITLE :

Section 5 Master Bedroom

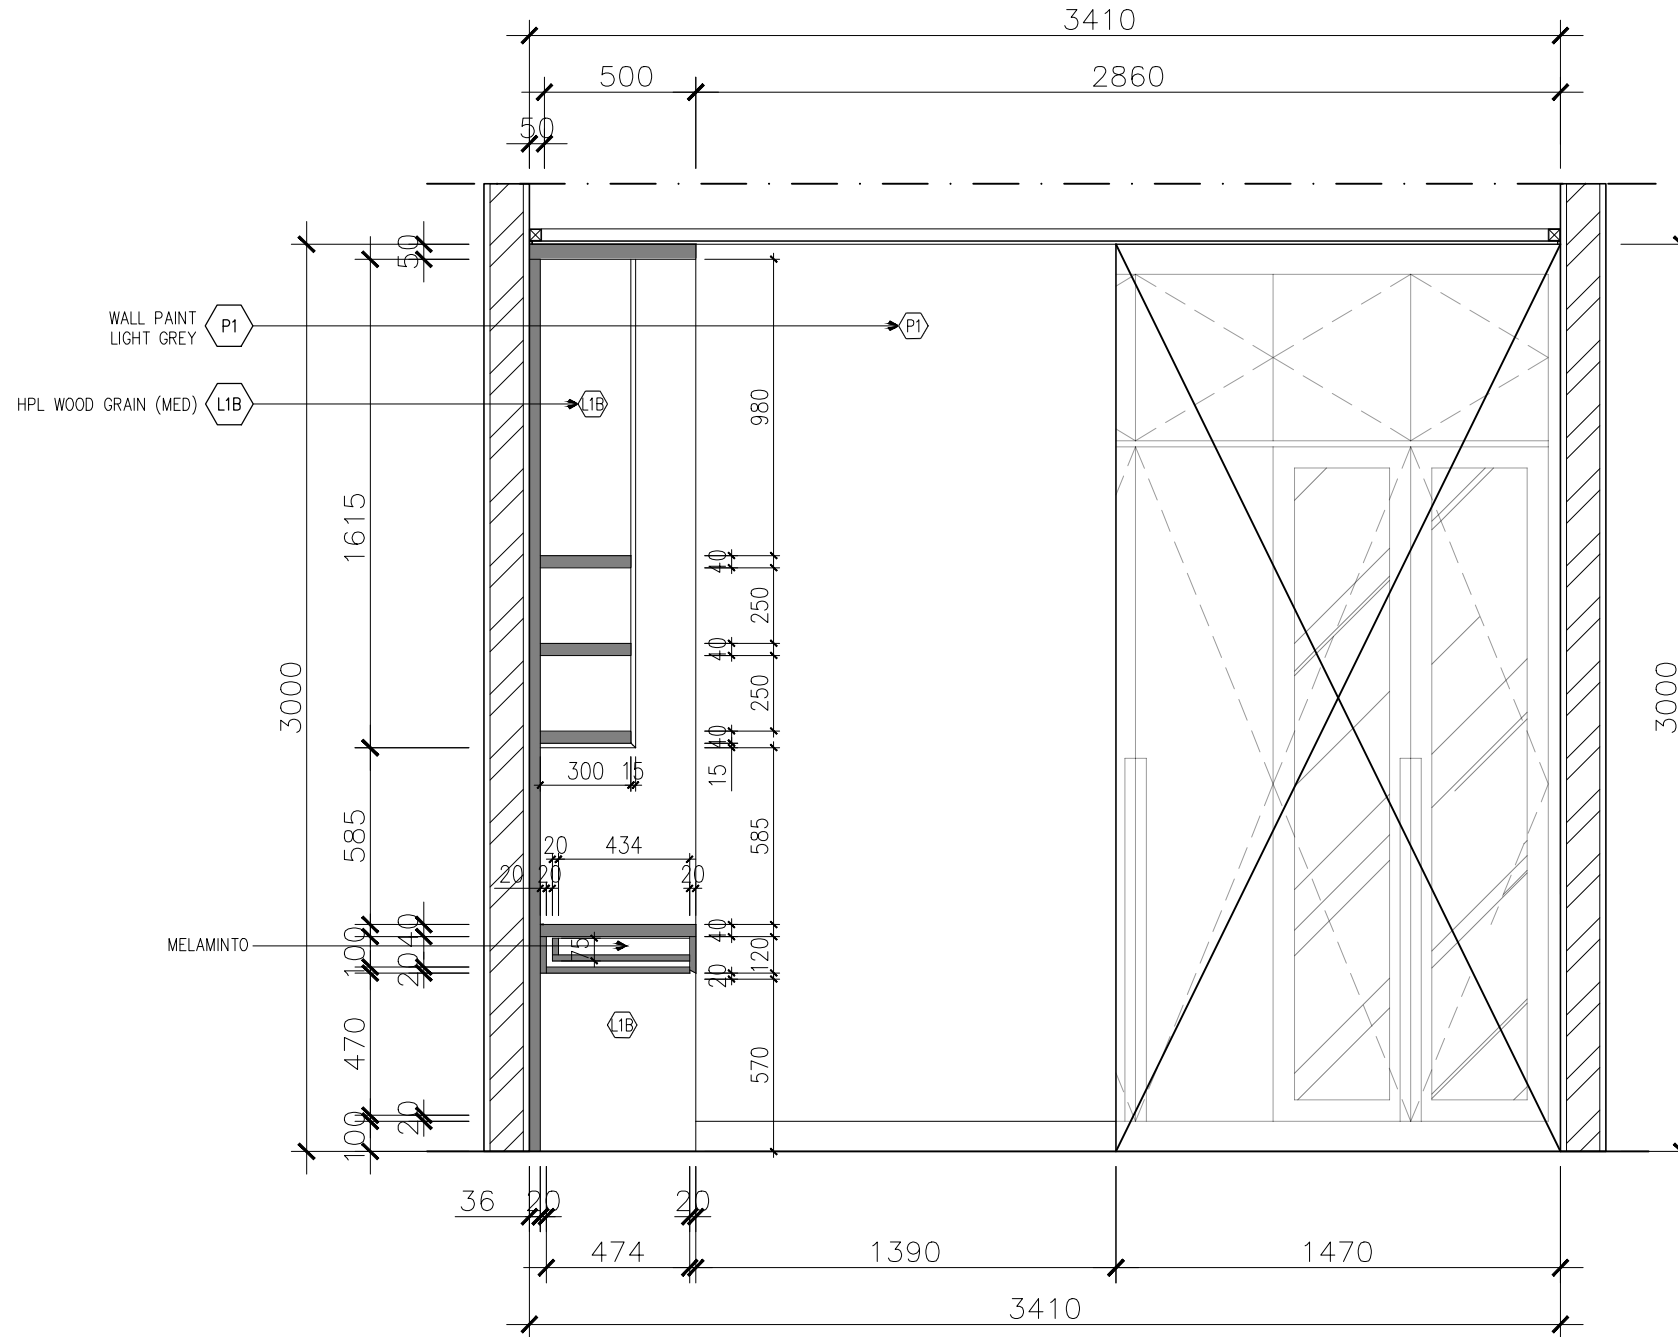

Section 5
Scale 1:25

DATE ON :	21/11/2025	SCALE :	1 : 25
DRAWN :	Linda Walyu L. S.	UNIT :	mm
JOB NO :			51
CHECKED BY :	Jessica O.	APPROVED BY :	Jessica O.

SHEET NO :	BR1	DRAWING NO :	08
------------	-----	--------------	----

REV. NO :



DUENDE
design + build

Serpong Utara, Tangerang Selatan
+62812 8603 4050
duende.designandbuild@gmail.com

CLIENT :

Mrs. S

CONTRACTOR :

PROJECT :

Vivaldy Residence

LOCATION :

Summarecon Serpong, Tangerang


DRAWING TITLE :

Section 6 Master Bedroom


DATE ON :	21/11/2025	SCALE :	1 : 25
DRAWN :	Linda Walyu L. S.	UNIT :	mm
JOB NO :		CHECKED BY :	Jessica O.
		APPROVED BY :	Jessica O.

SHEET NO :	BR1	DRAWING NO :	09
------------	-----	--------------	----

REV. NO :

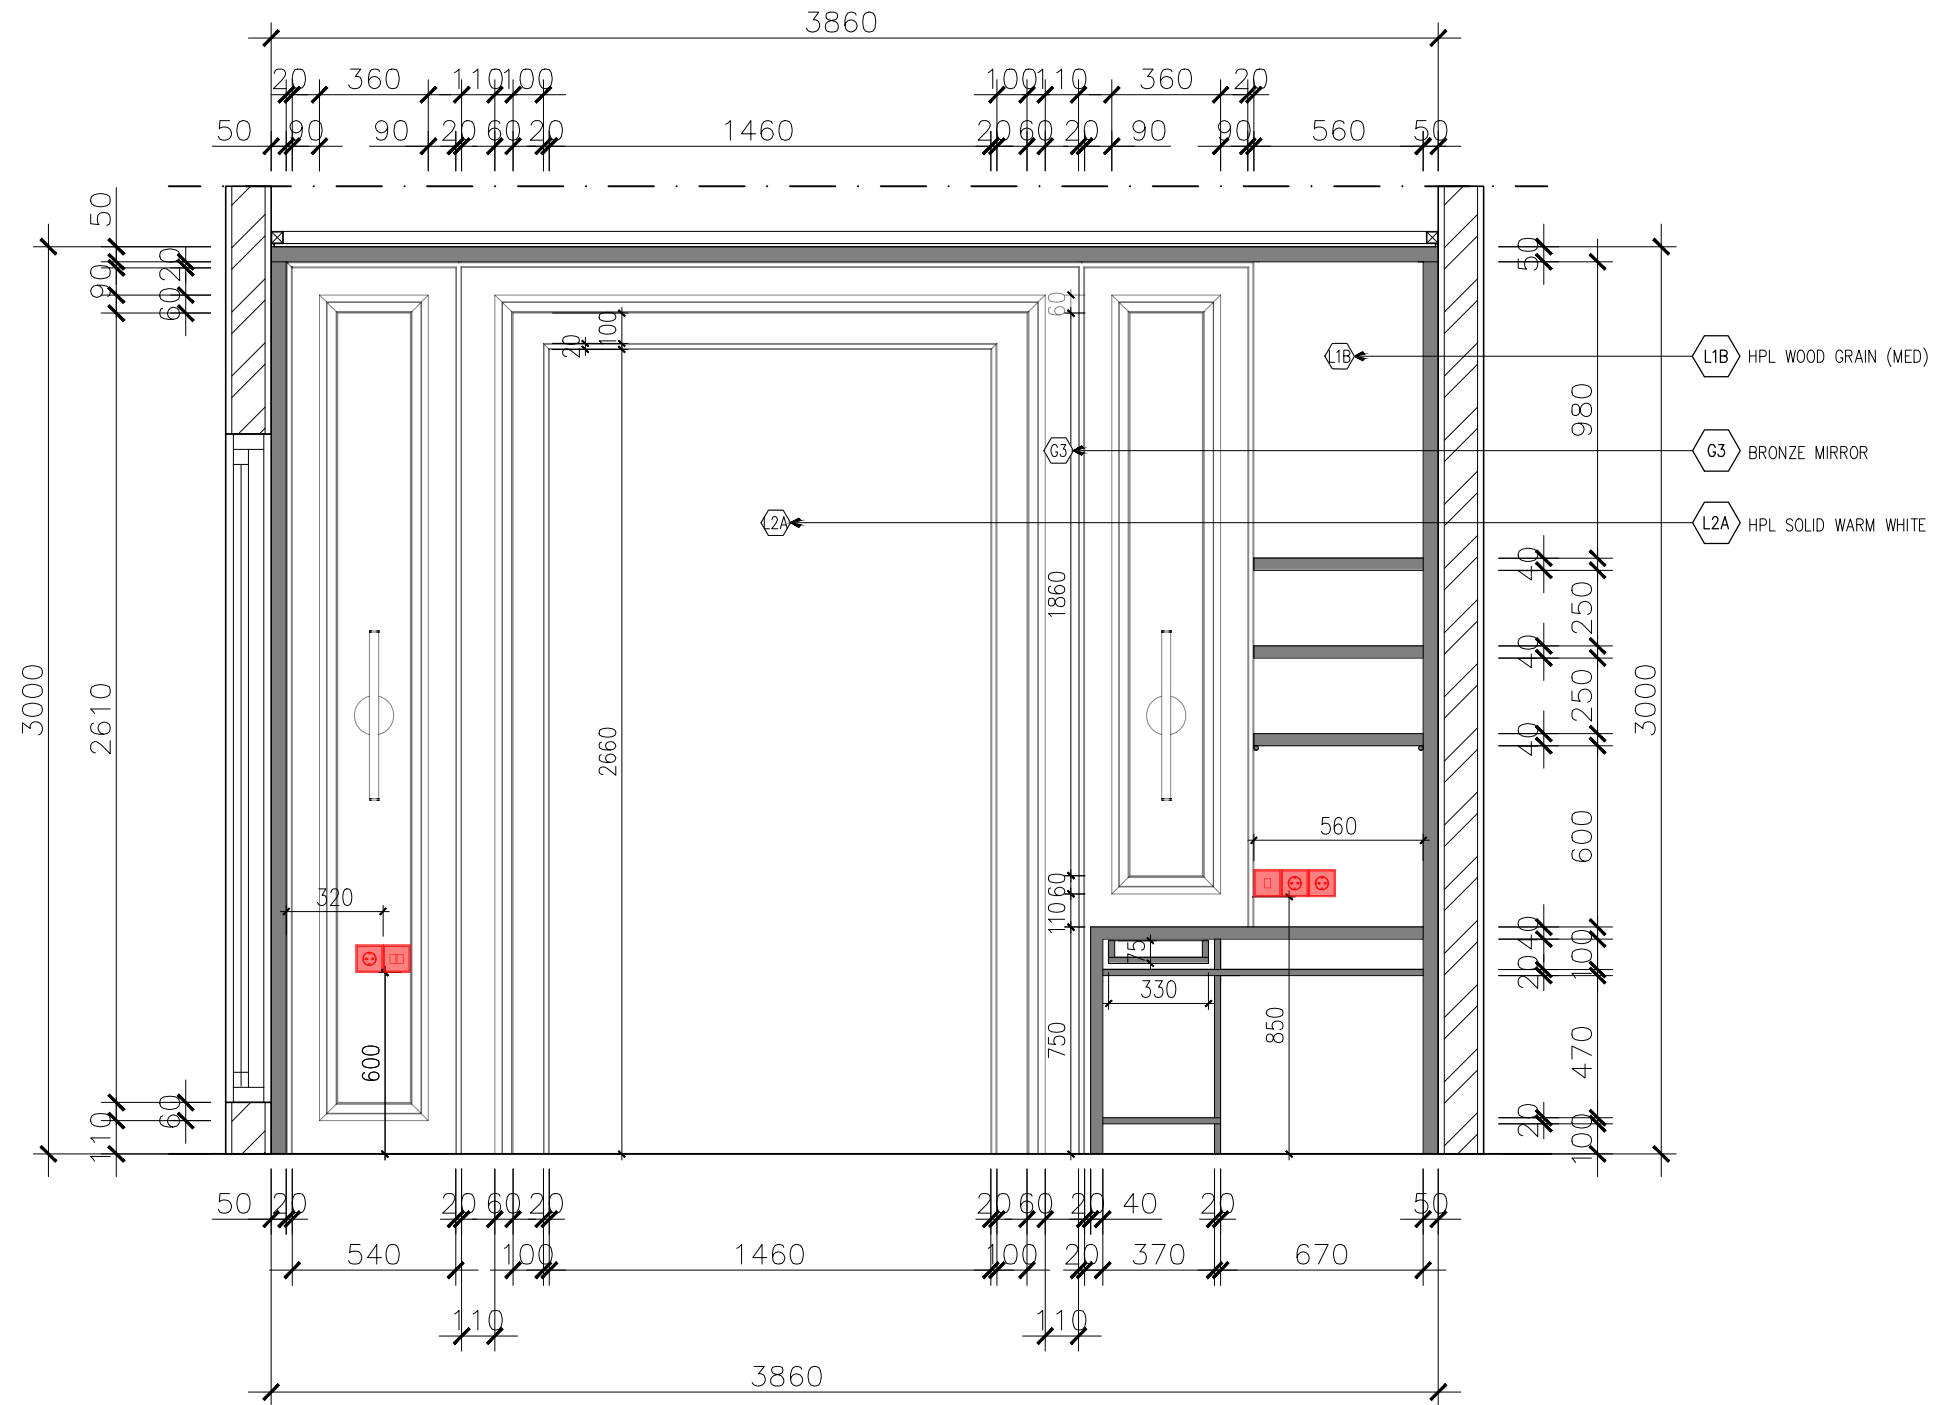


Section 6
Scale 1:25

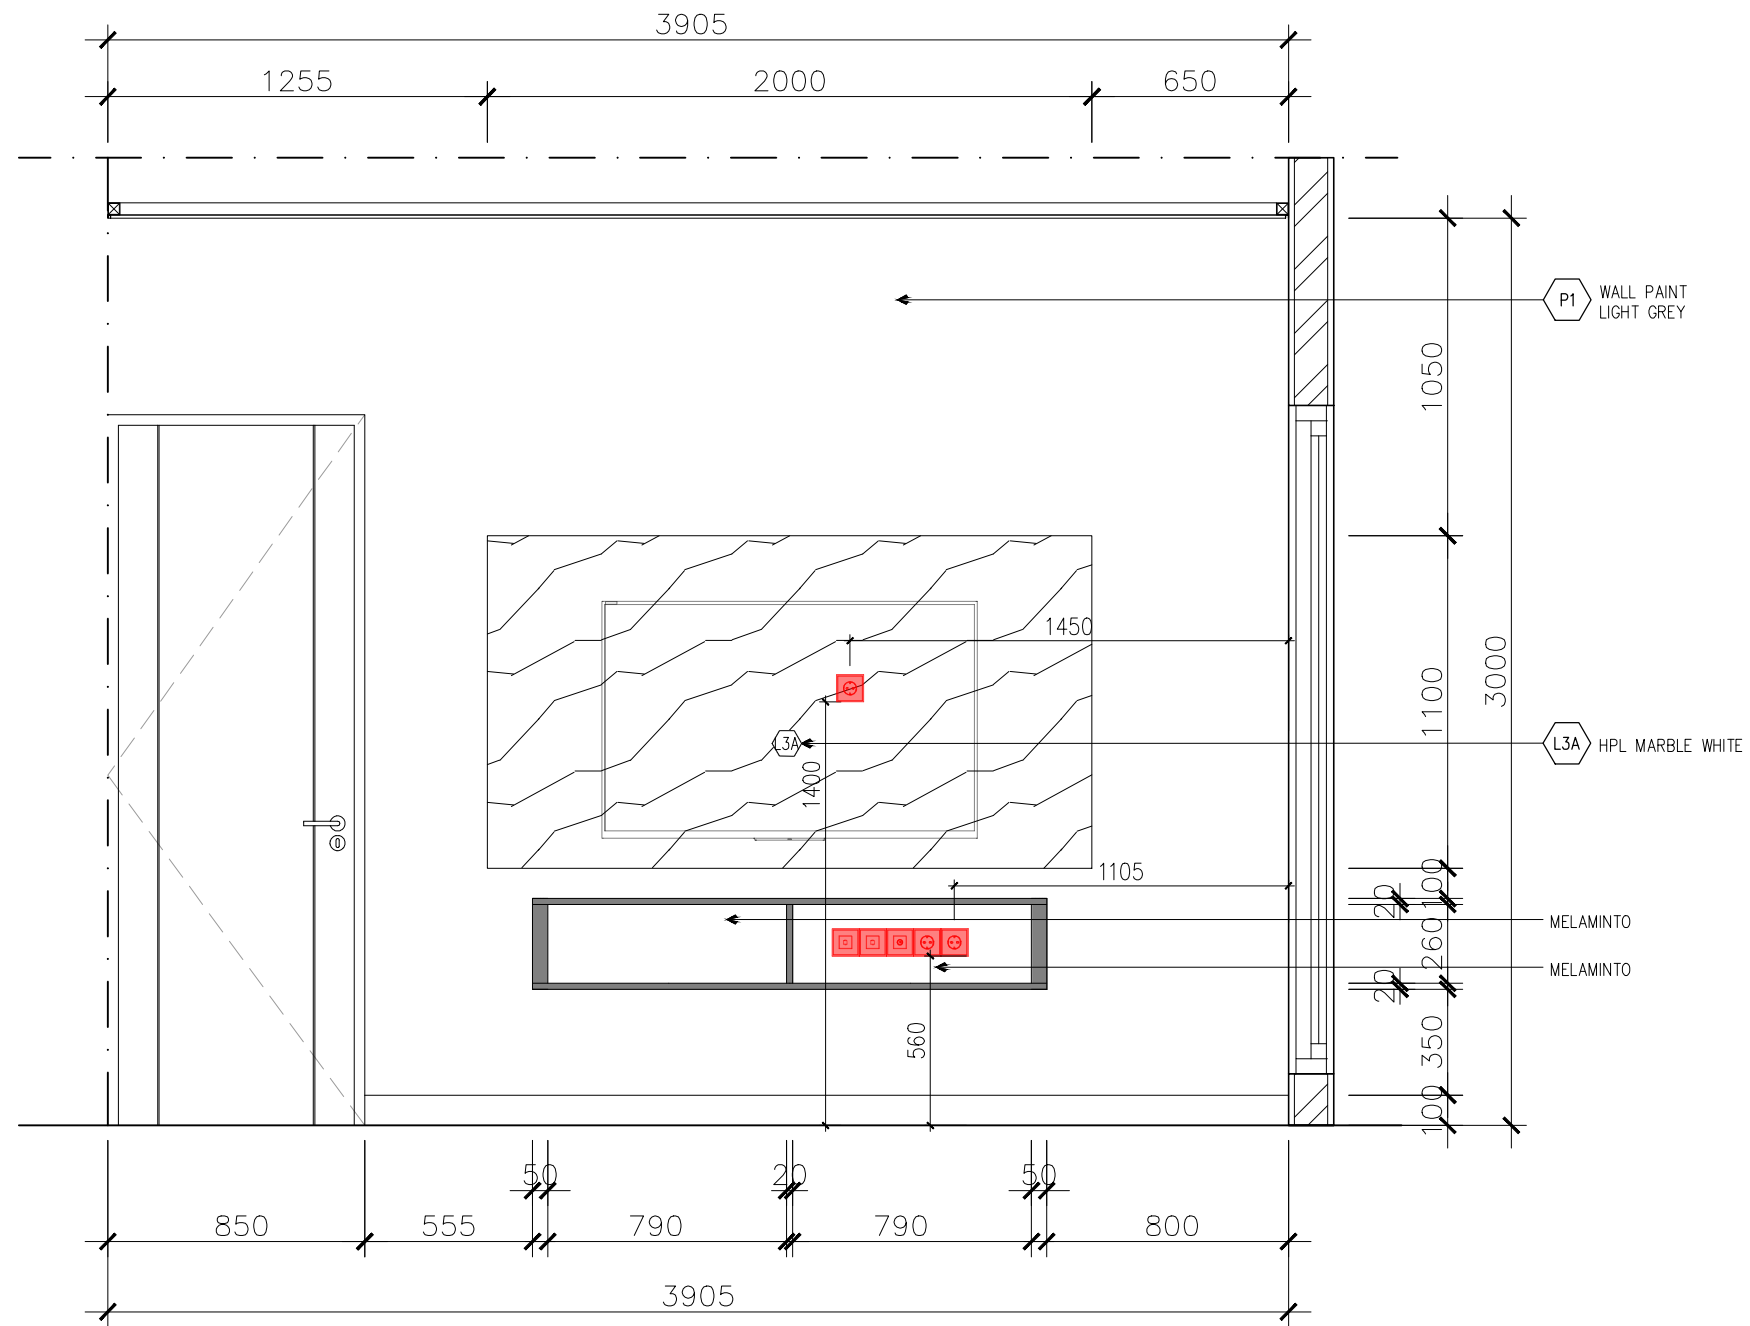

Section 7
Scale 1:25

DATE ON : 21/11/2025	SCALE : 1 : 25	DRAWN : Linda Walyu L. S.	UNIT : mm	JOB NO : 51	APPROVED BY : Jessica O.
CHECKED BY : Jessica O.					

SHEET NO : BR1	DRAWING NO : 10
-------------------	--------------------

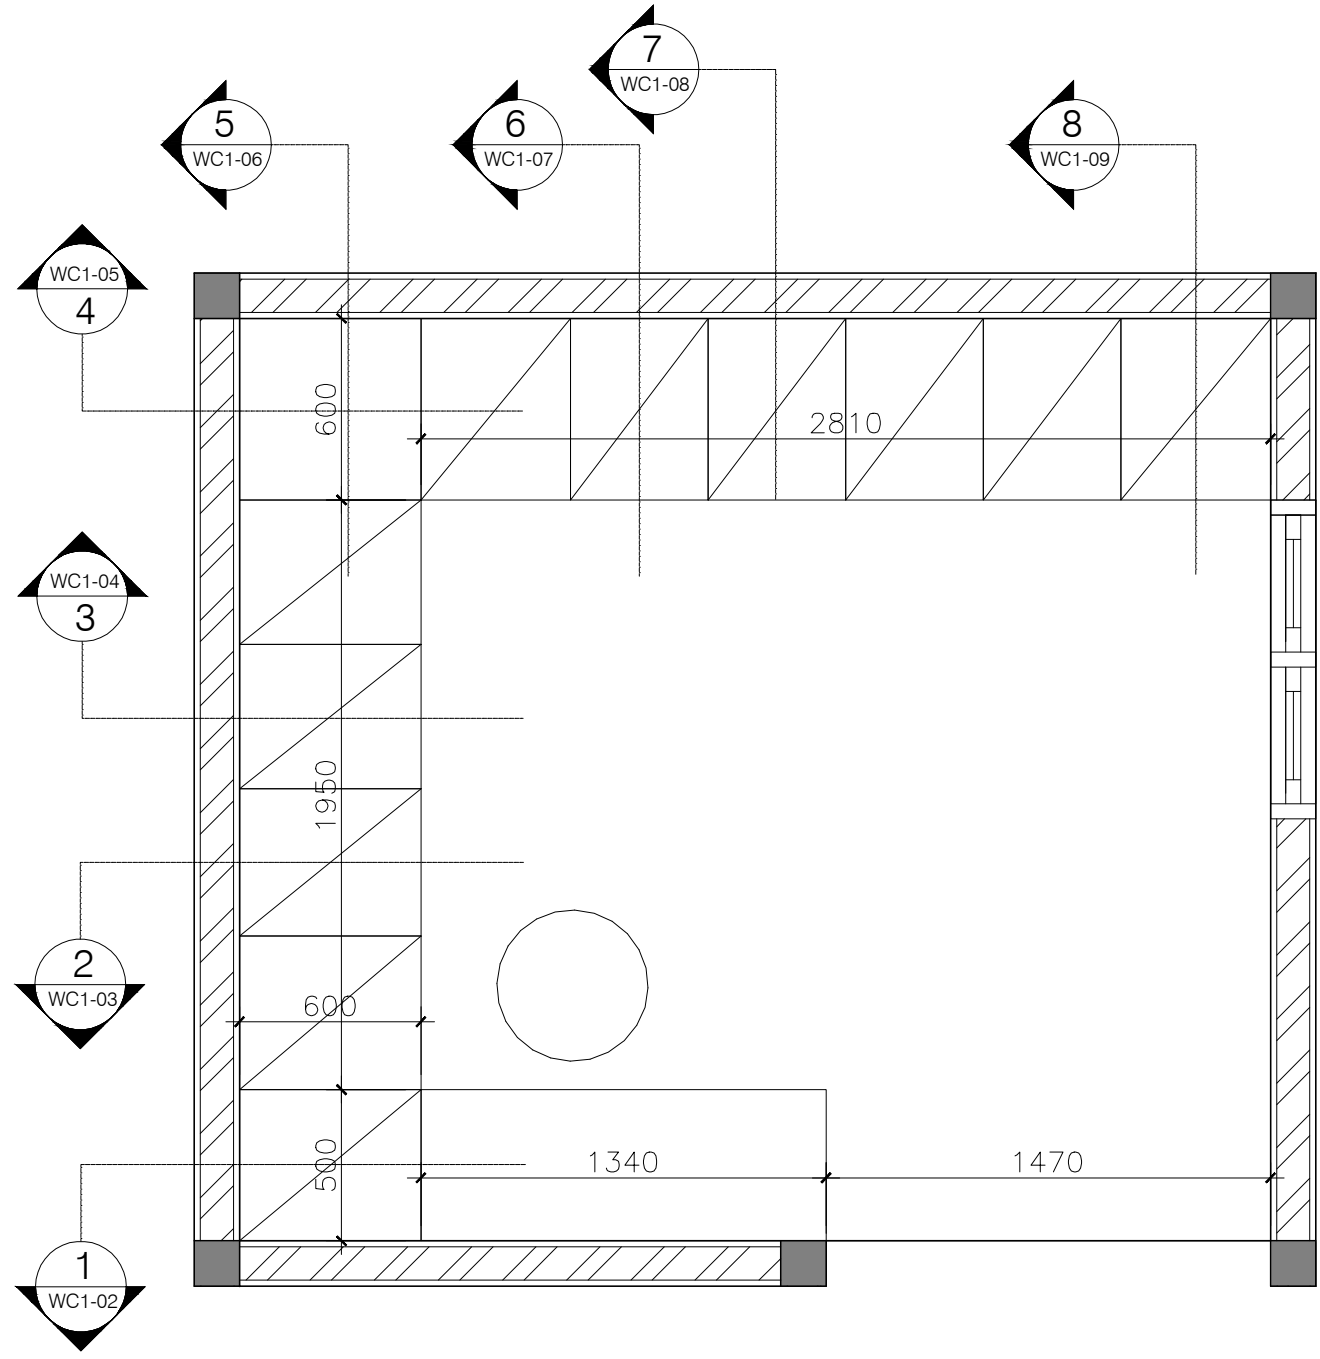

Layout Walk in Closet
 Scale 1:25

CONTRACTOR :

PROJECT :	Vivaldy Residence
LOCATION :	Summarecon Serpong, Tangerang

DRAWING TITLE :

Layout Walk in Closet	
-----------------------	--

DATE ON :	21/11/2025	SCALE :	1 : 25
DRAWN :	Linda Walyu L. S.	UNIT :	mm
JOB NO :			51
CHECKED BY :		APPROVED BY :	
Jessica O.		Jessica O.	

SHEET NO :	DRAWING NO :
WC1	01

REV. NO :



DUENDE
design + build

Serpong Utara, Tangerang Selatan
+62812 8603 4050
duende.designandbuild@gmail.com

CLIENT :

Mrs. S

CONTRACTOR :

PROJECT :


Vivaldy Residence

LOCATION :

Summarecon Serpong, Tangerang

DRAWING TITLE :

Section 1 Walk in Closet

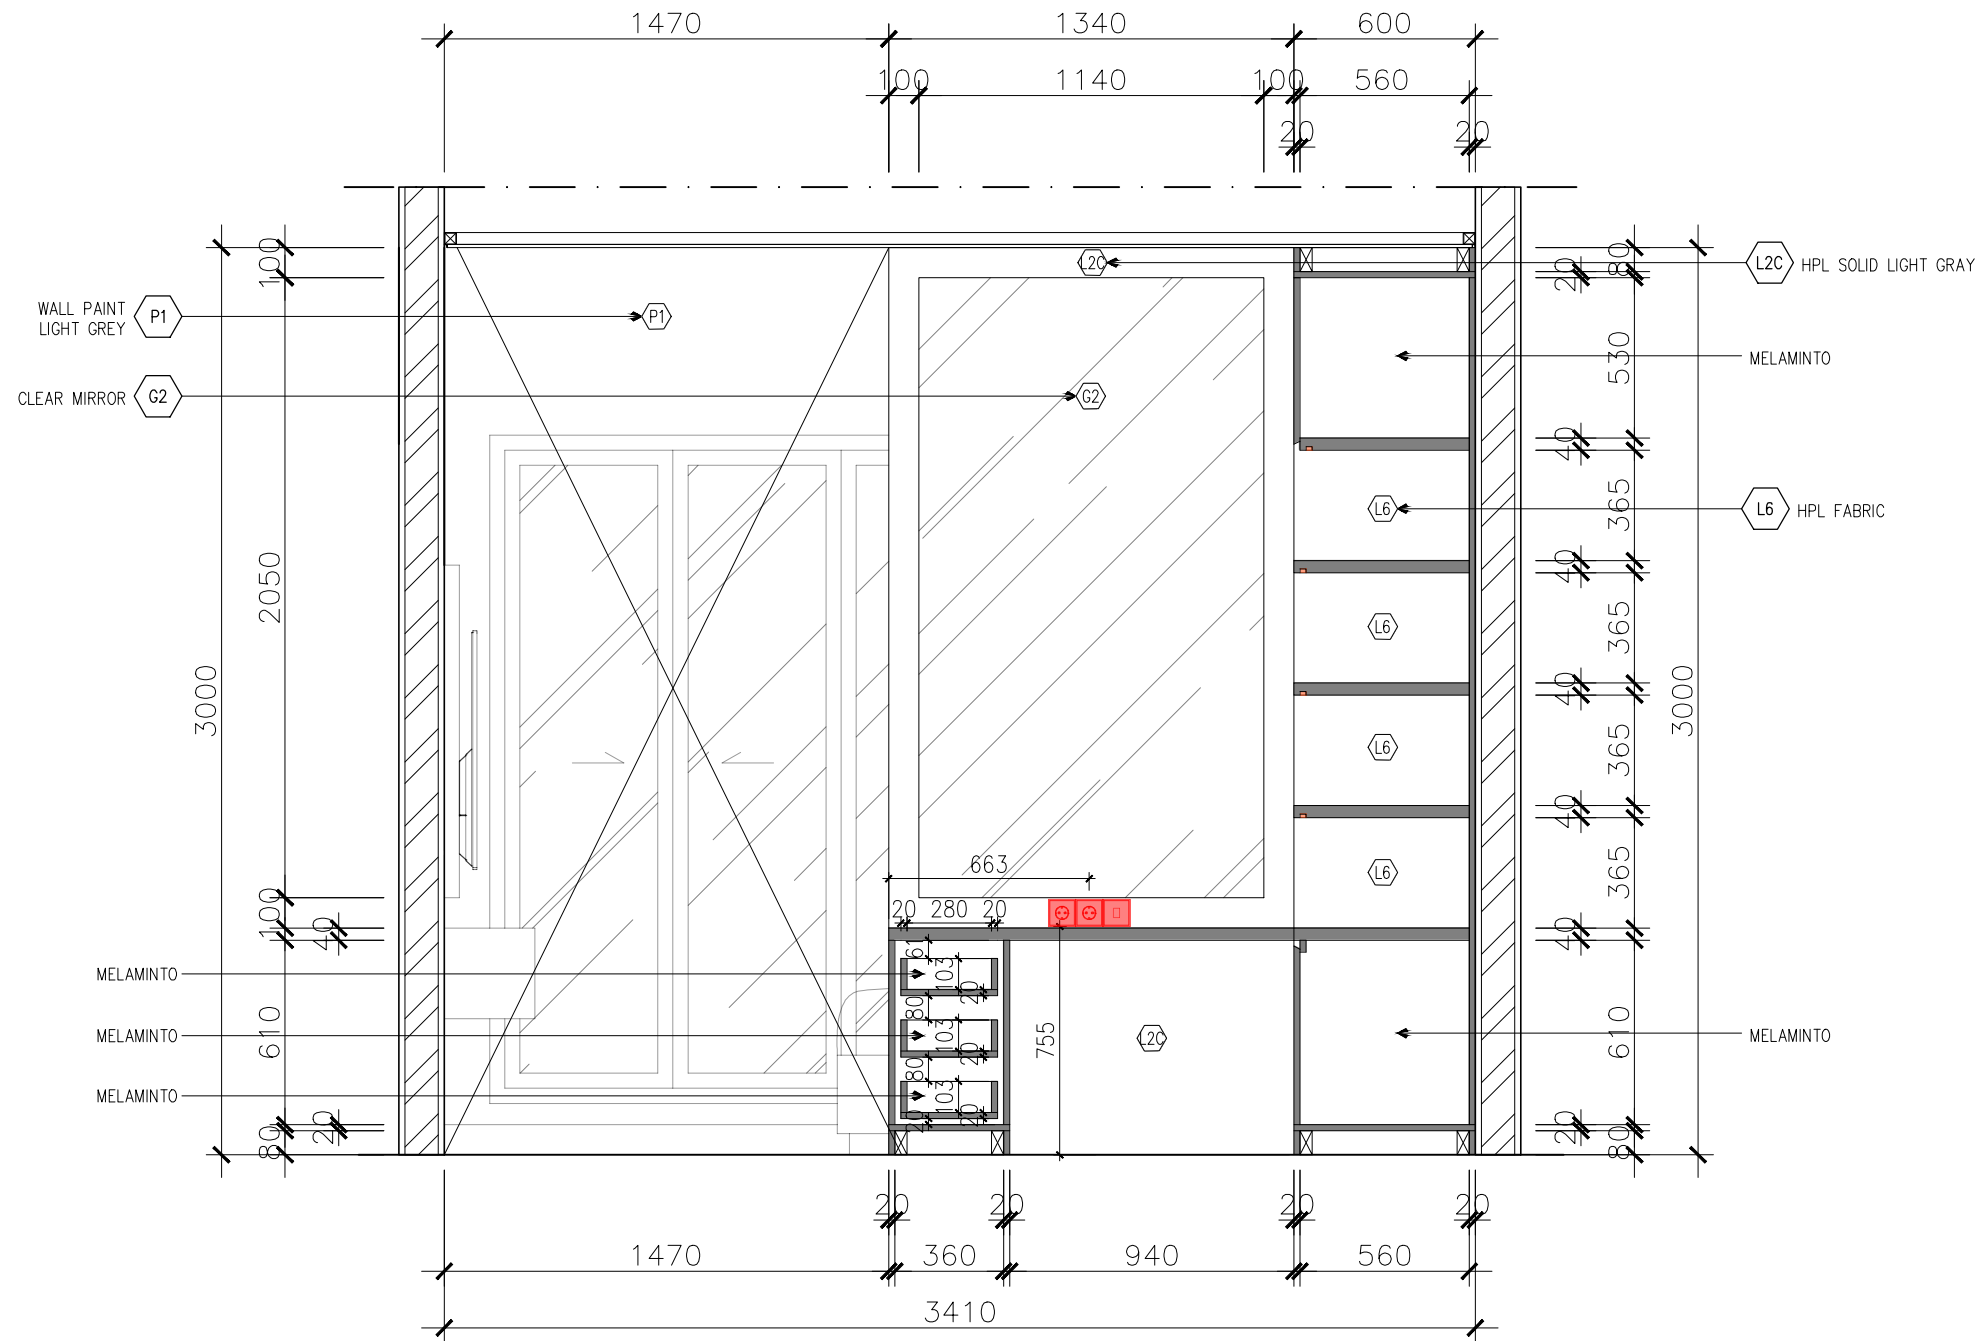

Section 1
Scale 1:25

DATE ON :	21/11/2025	SCALE :	1 : 25
DRAWN :	Linda Walyu L. S.	UNIT :	mm
JOB NO :			51
CHECKED BY :	Jessica O.	APPROVED BY :	Jessica O.

SHEET NO :	WC1	DRAWING NO :	02
------------	-----	--------------	----

REV. NO :



DUENDE
design + build

Serpong Utara, Tangerang Selatan
+62812 8603 4050
duende.designandbuild@gmail.com

CLIENT :

Mrs. S

CONTRACTOR :

PROJECT :


Vivaldy Residence

LOCATION :

Summarecon Serpong, Tangerang

DRAWING TITLE :

Section 2 Walk in Closet

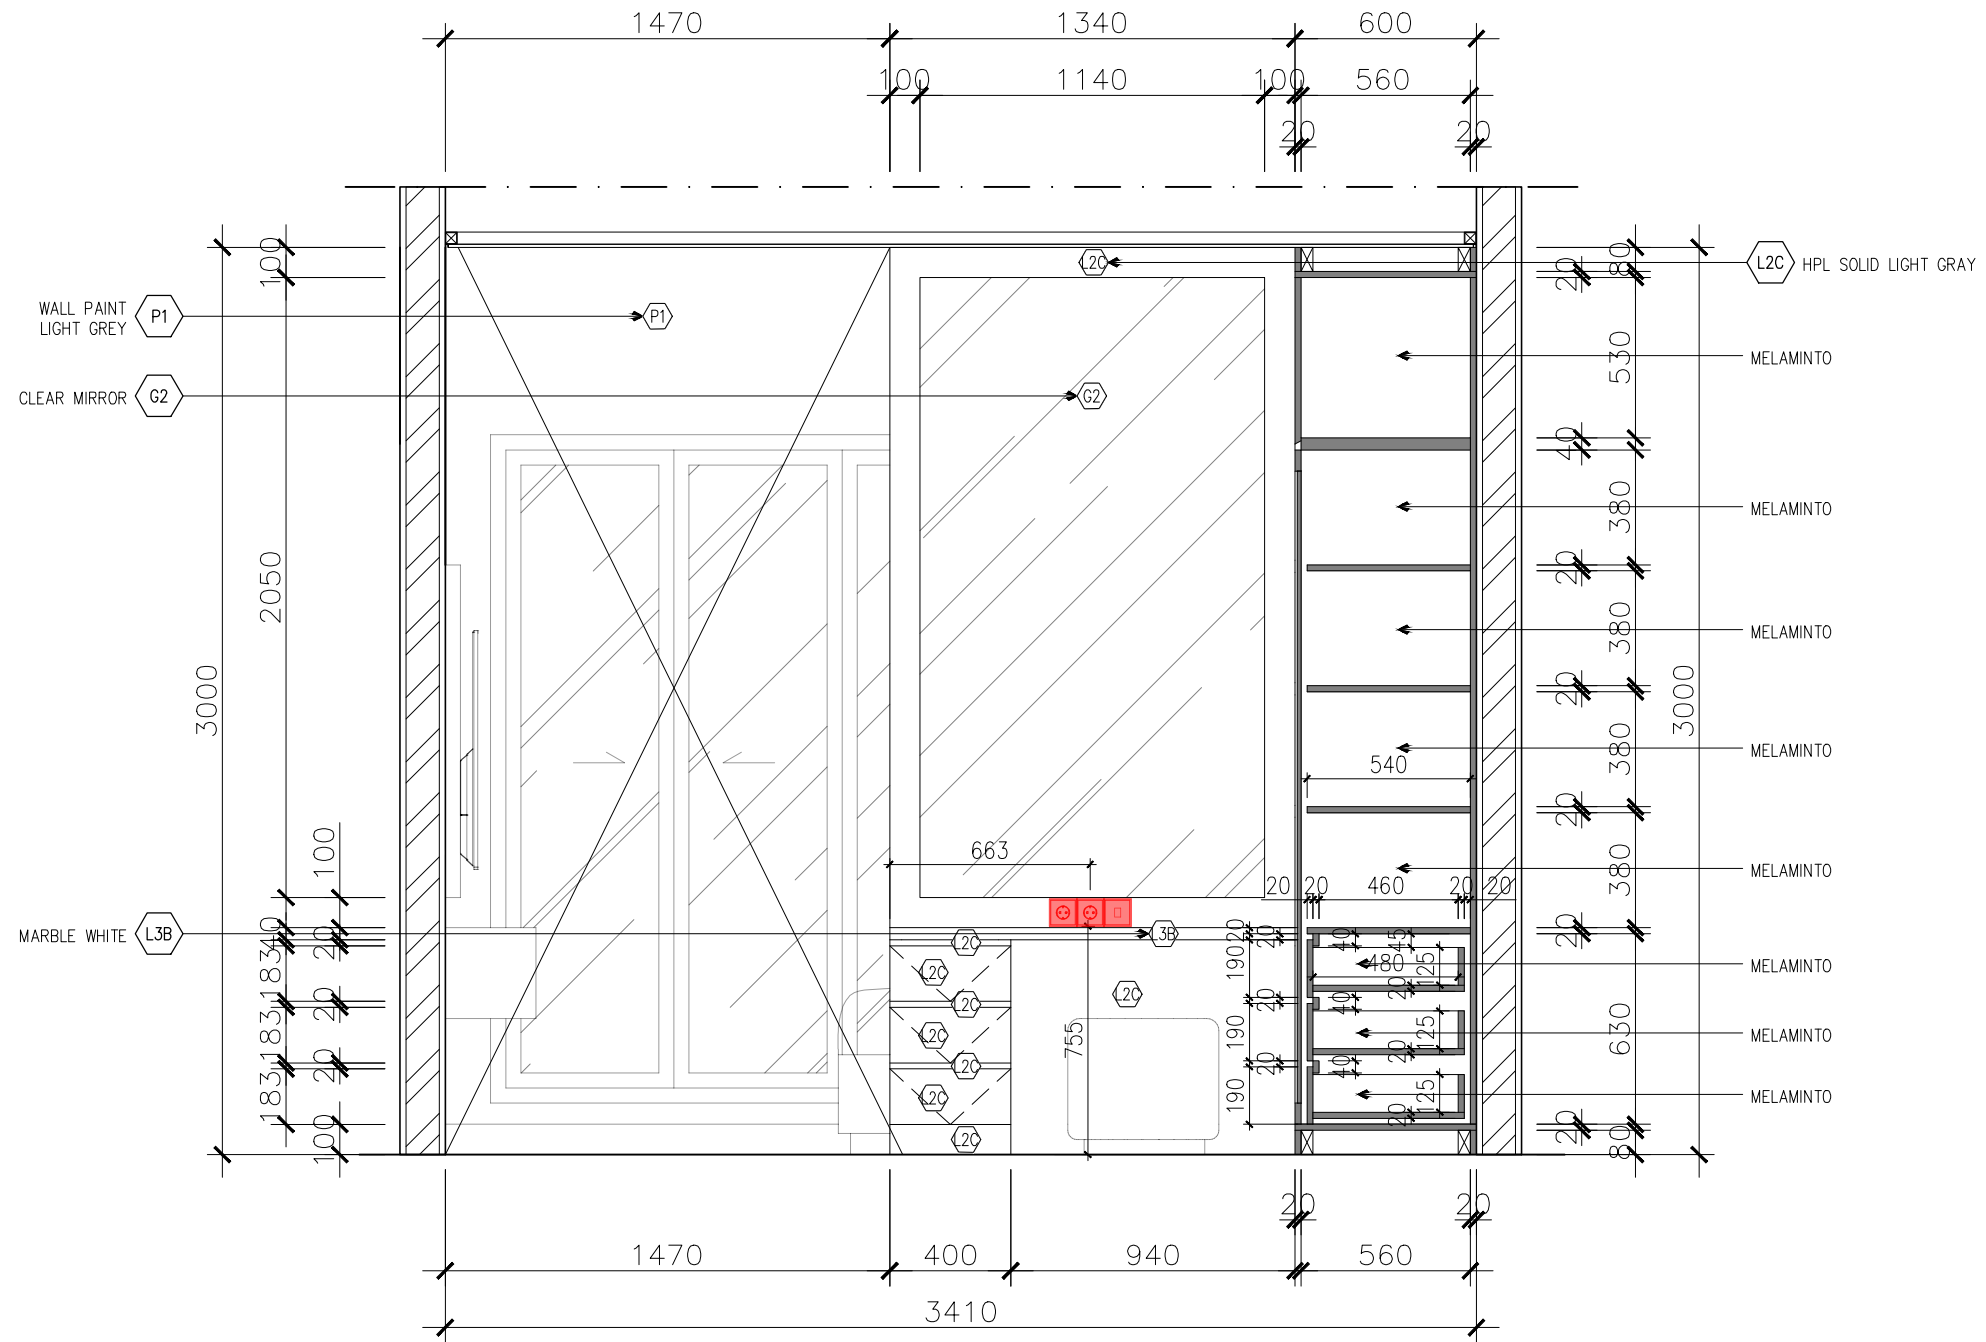

Section 2
Scale 1:25

DATE ON :	21/11/2025	SCALE :	1 : 25
DRAWN :	Linda Walyu L. S.	UNIT :	mm
JOB NO :			51
CHECKED BY :	Jessica O.	APPROVED BY :	Jessica O.

SHEET NO :	WC1	DRAWING NO :	03
------------	-----	--------------	----

REV. NO :



DUENDE
design + build

Serpong Utara, Tangerang Selatan
+62812 8603 4050
duende.designandbuild@gmail.com

CLIENT :

Mrs. S

CONTRACTOR :

PROJECT :


Vivaldy Residence

LOCATION :

Summarecon Serpong, Tangerang

DRAWING TITLE :

Section 3 Walk in Closet

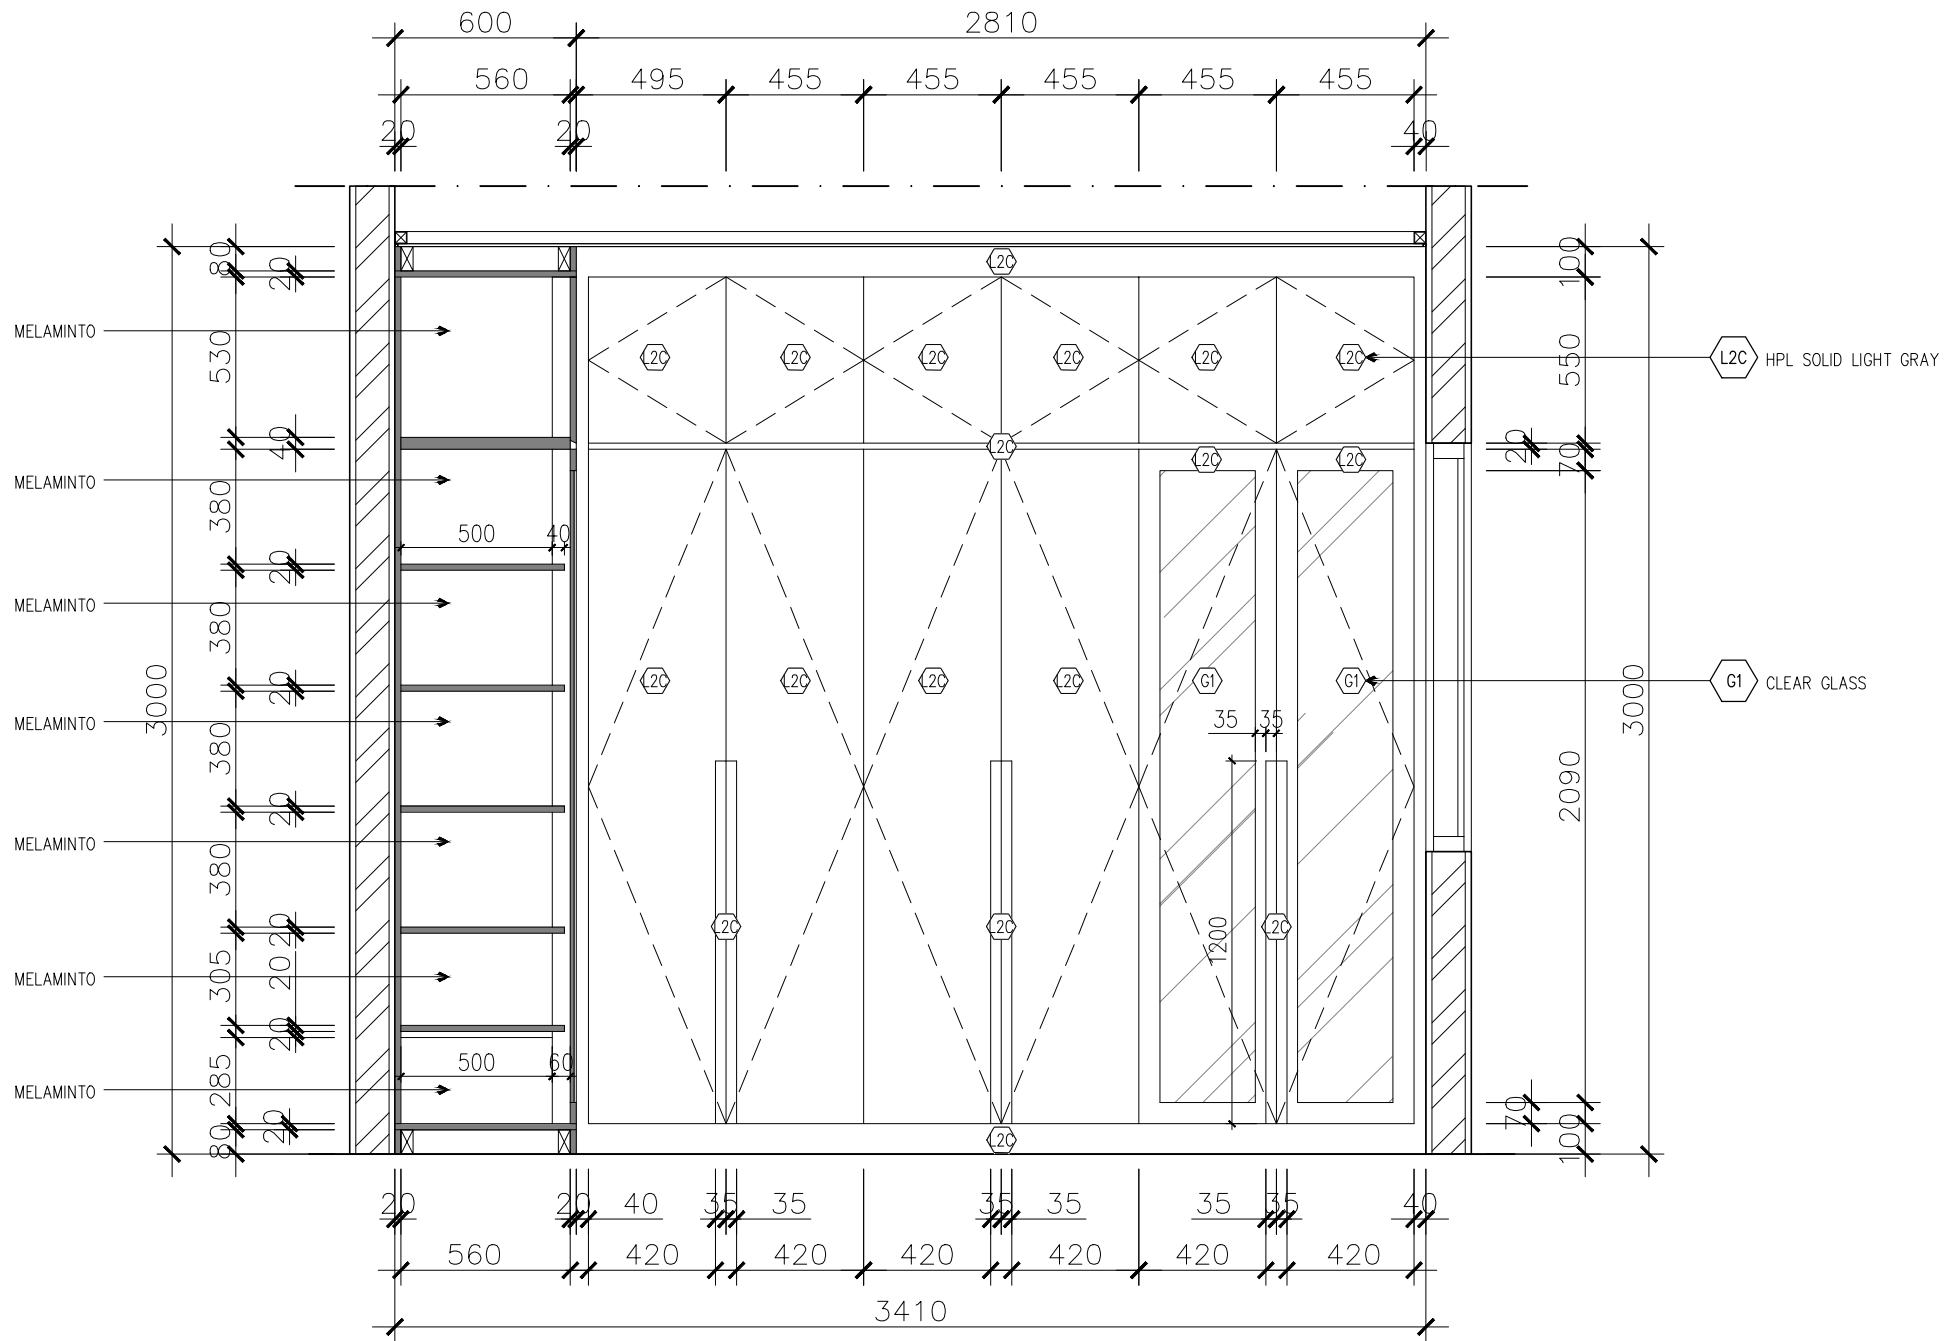


Section 3
Scale 1:25

DATE ON :	21/11/2025	SCALE :	1 : 25
DRAWN :	Linda Walyu L. S.	UNIT :	mm
JOB NO :			51
CHECKED BY :	Jessica O.	APPROVED BY :	Jessica O.

SHEET NO :	WC1	DRAWING NO :	04
------------	-----	--------------	----

REV. NO :

CLIENT :
Mrs. S

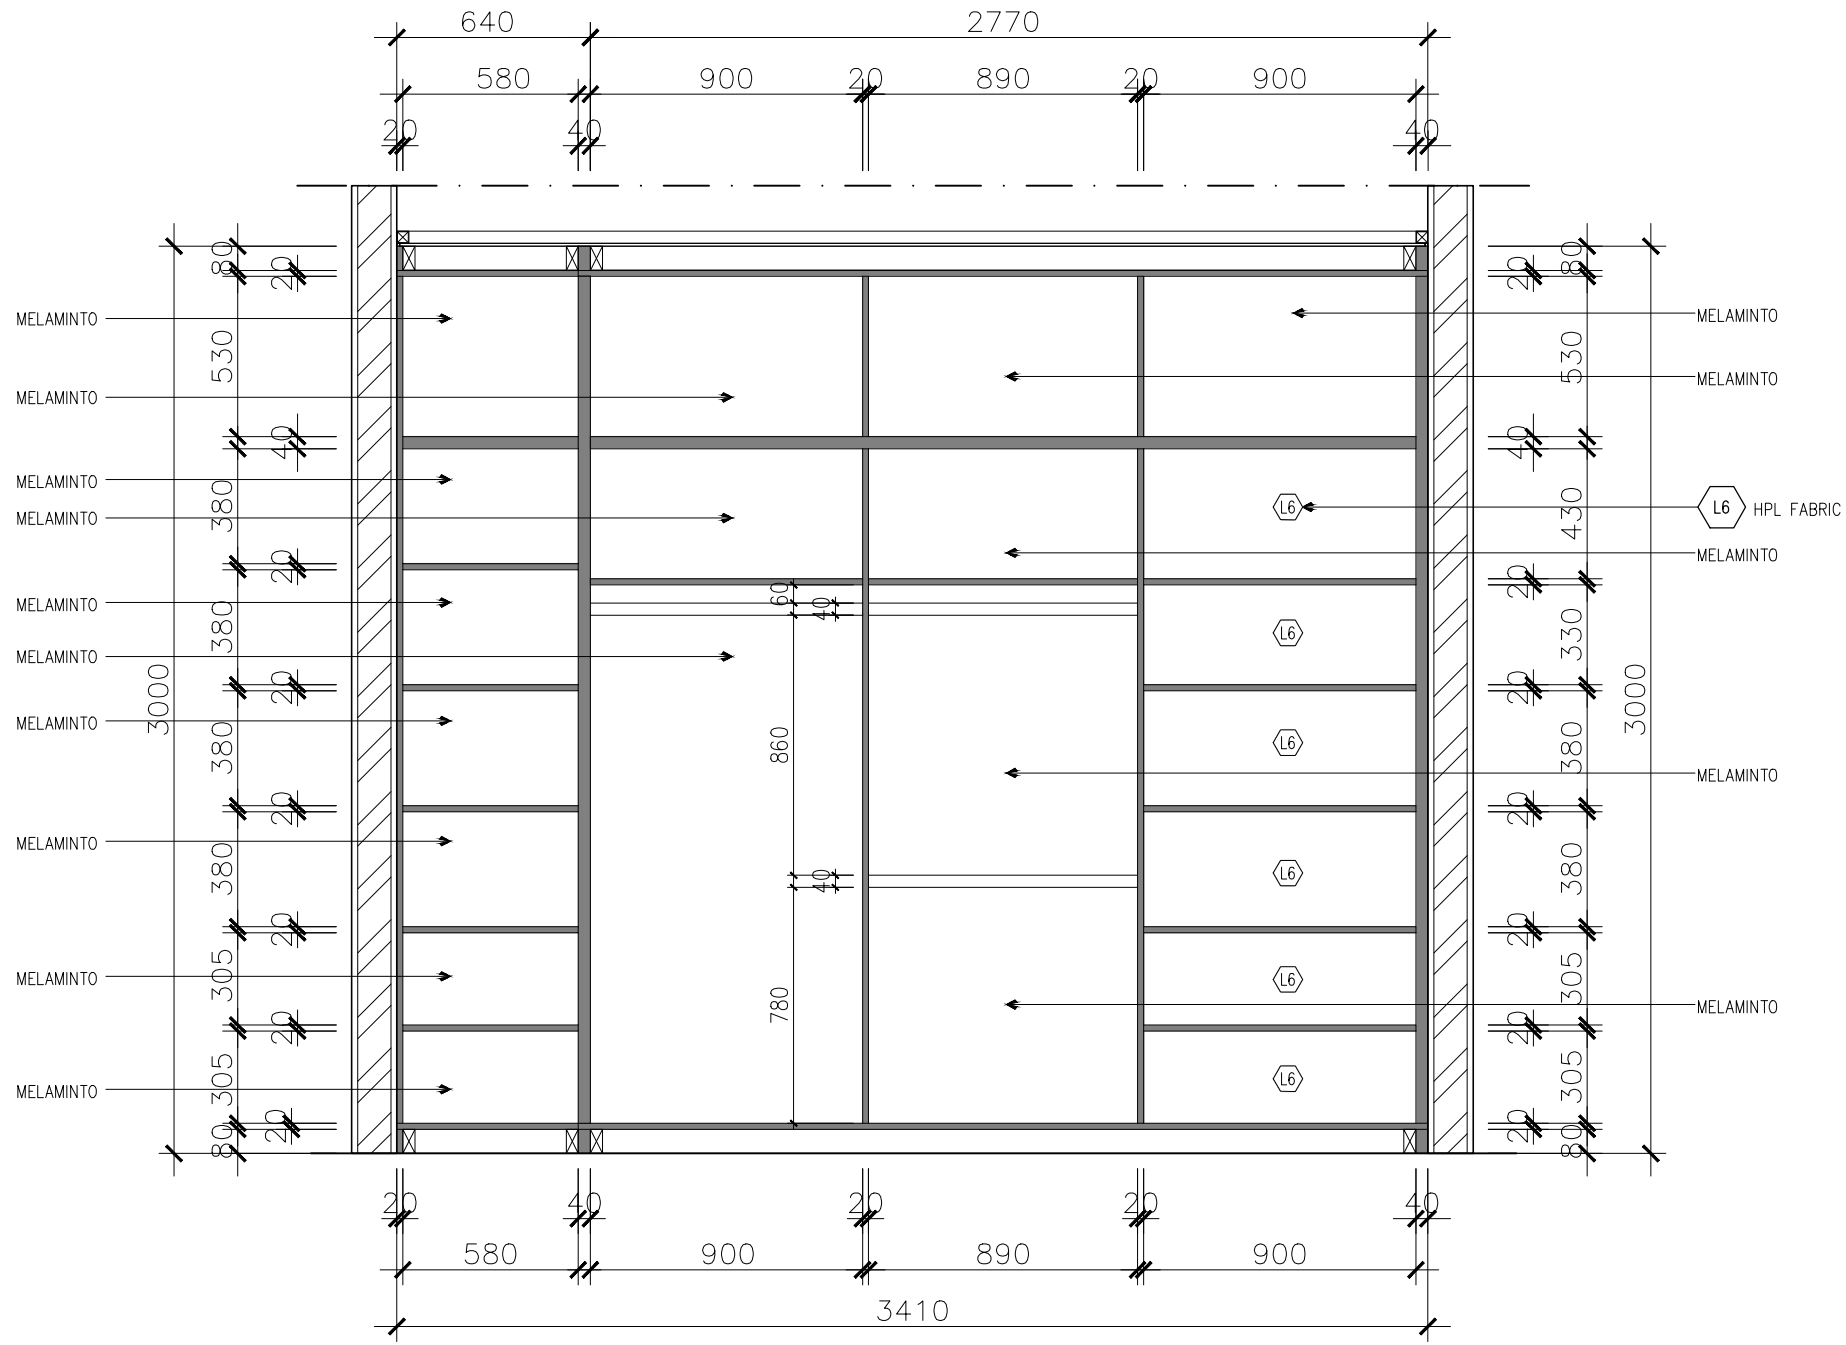

Section 4
Scale 1:25

CONTRACTOR :
Vivaldy Residence
 LOCATION :
Summarecon Serpong, Tangerang

PROJECT :
Vivaldy Residence
 LOCATION :
Summarecon Serpong, Tangerang

DRAWING TITLE :
Section 4 Walk in Closet

DATE ON : 21/11/2025	SCALE : 1 : 25	UNIT : mm	SHEET NO : 51
DRAWN : Linda Wahyuni L. S.	CHECKED BY : Jessica O.	APPROVED BY : Jessica O.	
JOB NO :			

SHEET NO : WC1	DRAWING NO : 05
-------------------	--------------------



DUENDE
design + build

Serpong Utara, Tangerang Selatan
+62812 8603 4050
duende.designandbuild@gmail.com

CLIENT :

Mrs. S

CONTRACTOR :

PROJECT :


Vivaldy Residence

LOCATION :

Summarecon Serpong, Tangerang

DRAWING TITLE :

Section 5 Walk in Closet

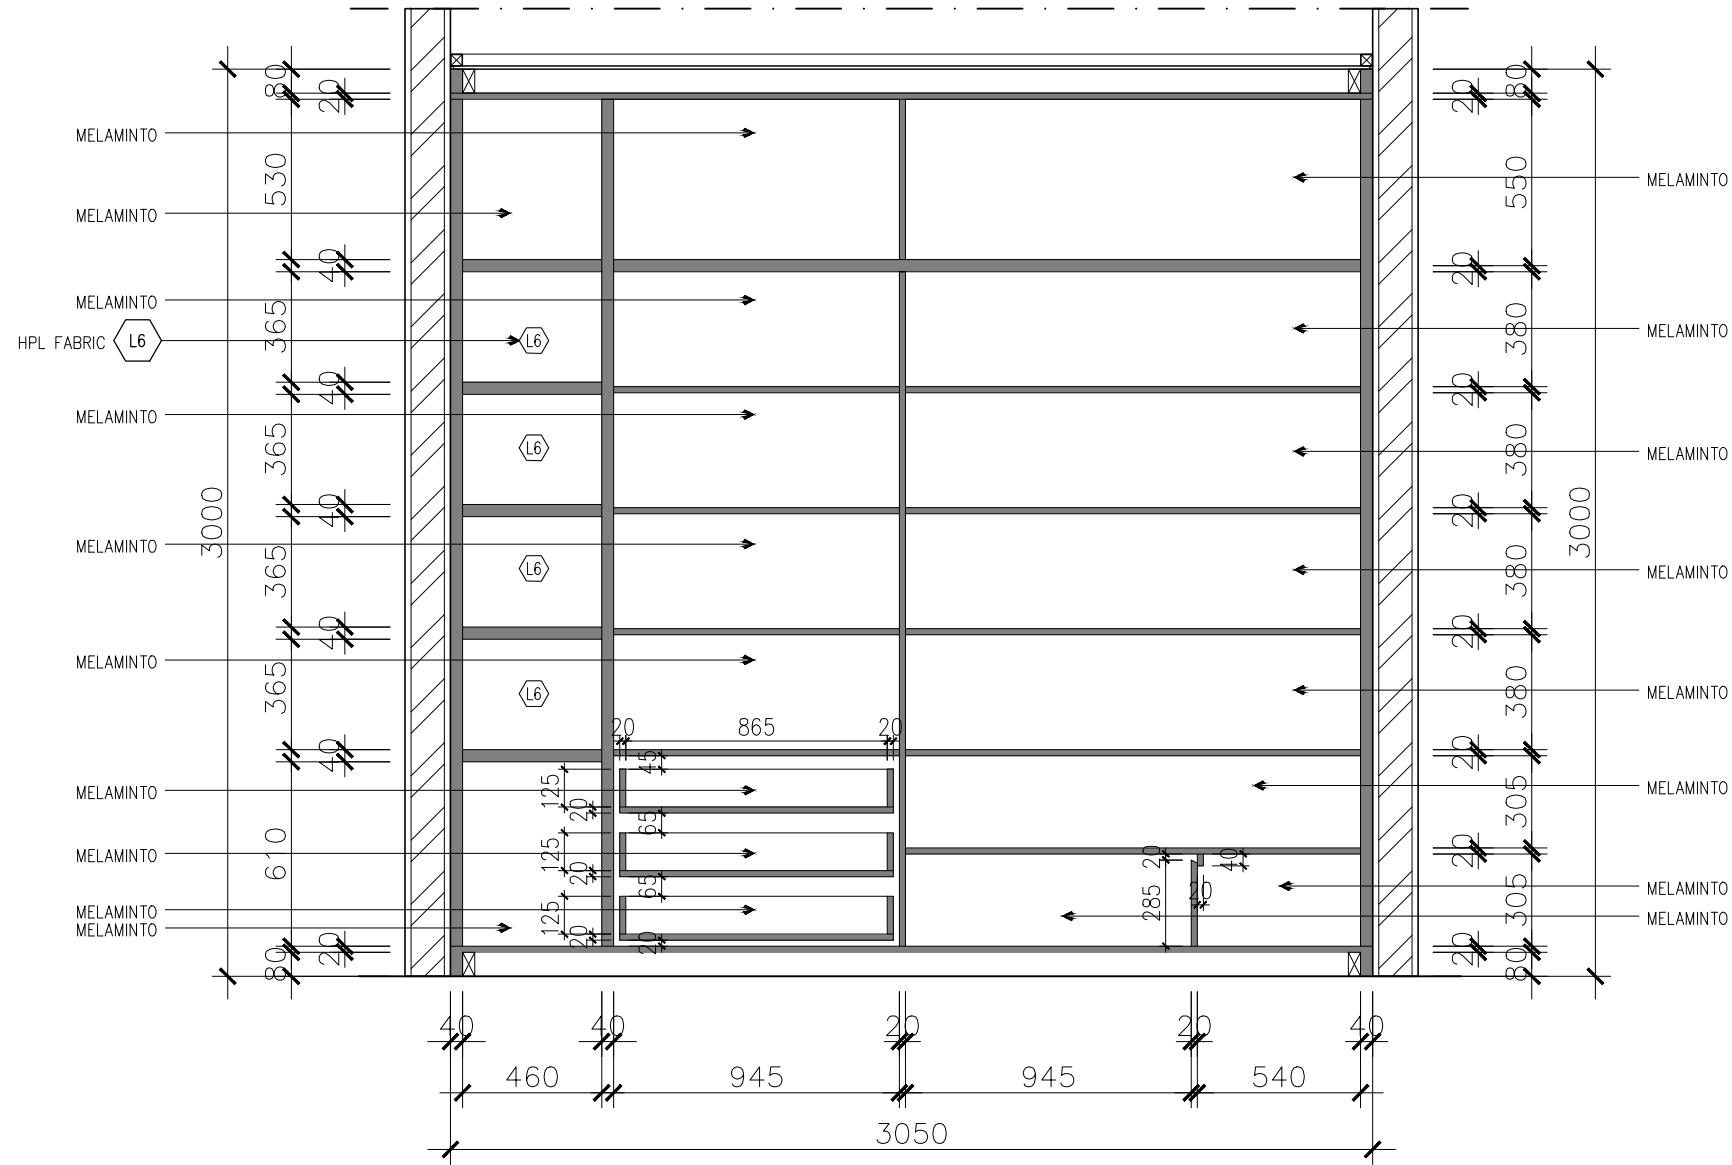


Section 5
Scale 1:25

DATE ON :	21/11/2025	SCALE :	1 : 25
DRAWN :	Linda Wallyu L. S.	UNIT :	mm
JOB NO :			51
CHECKED BY :	Jessica O.	APPROVED BY :	Jessica O.

SHEET NO :	WC1	DRAWING NO :	06
------------	-----	--------------	----

REV. NO :

CLIENT :
Mrs. S

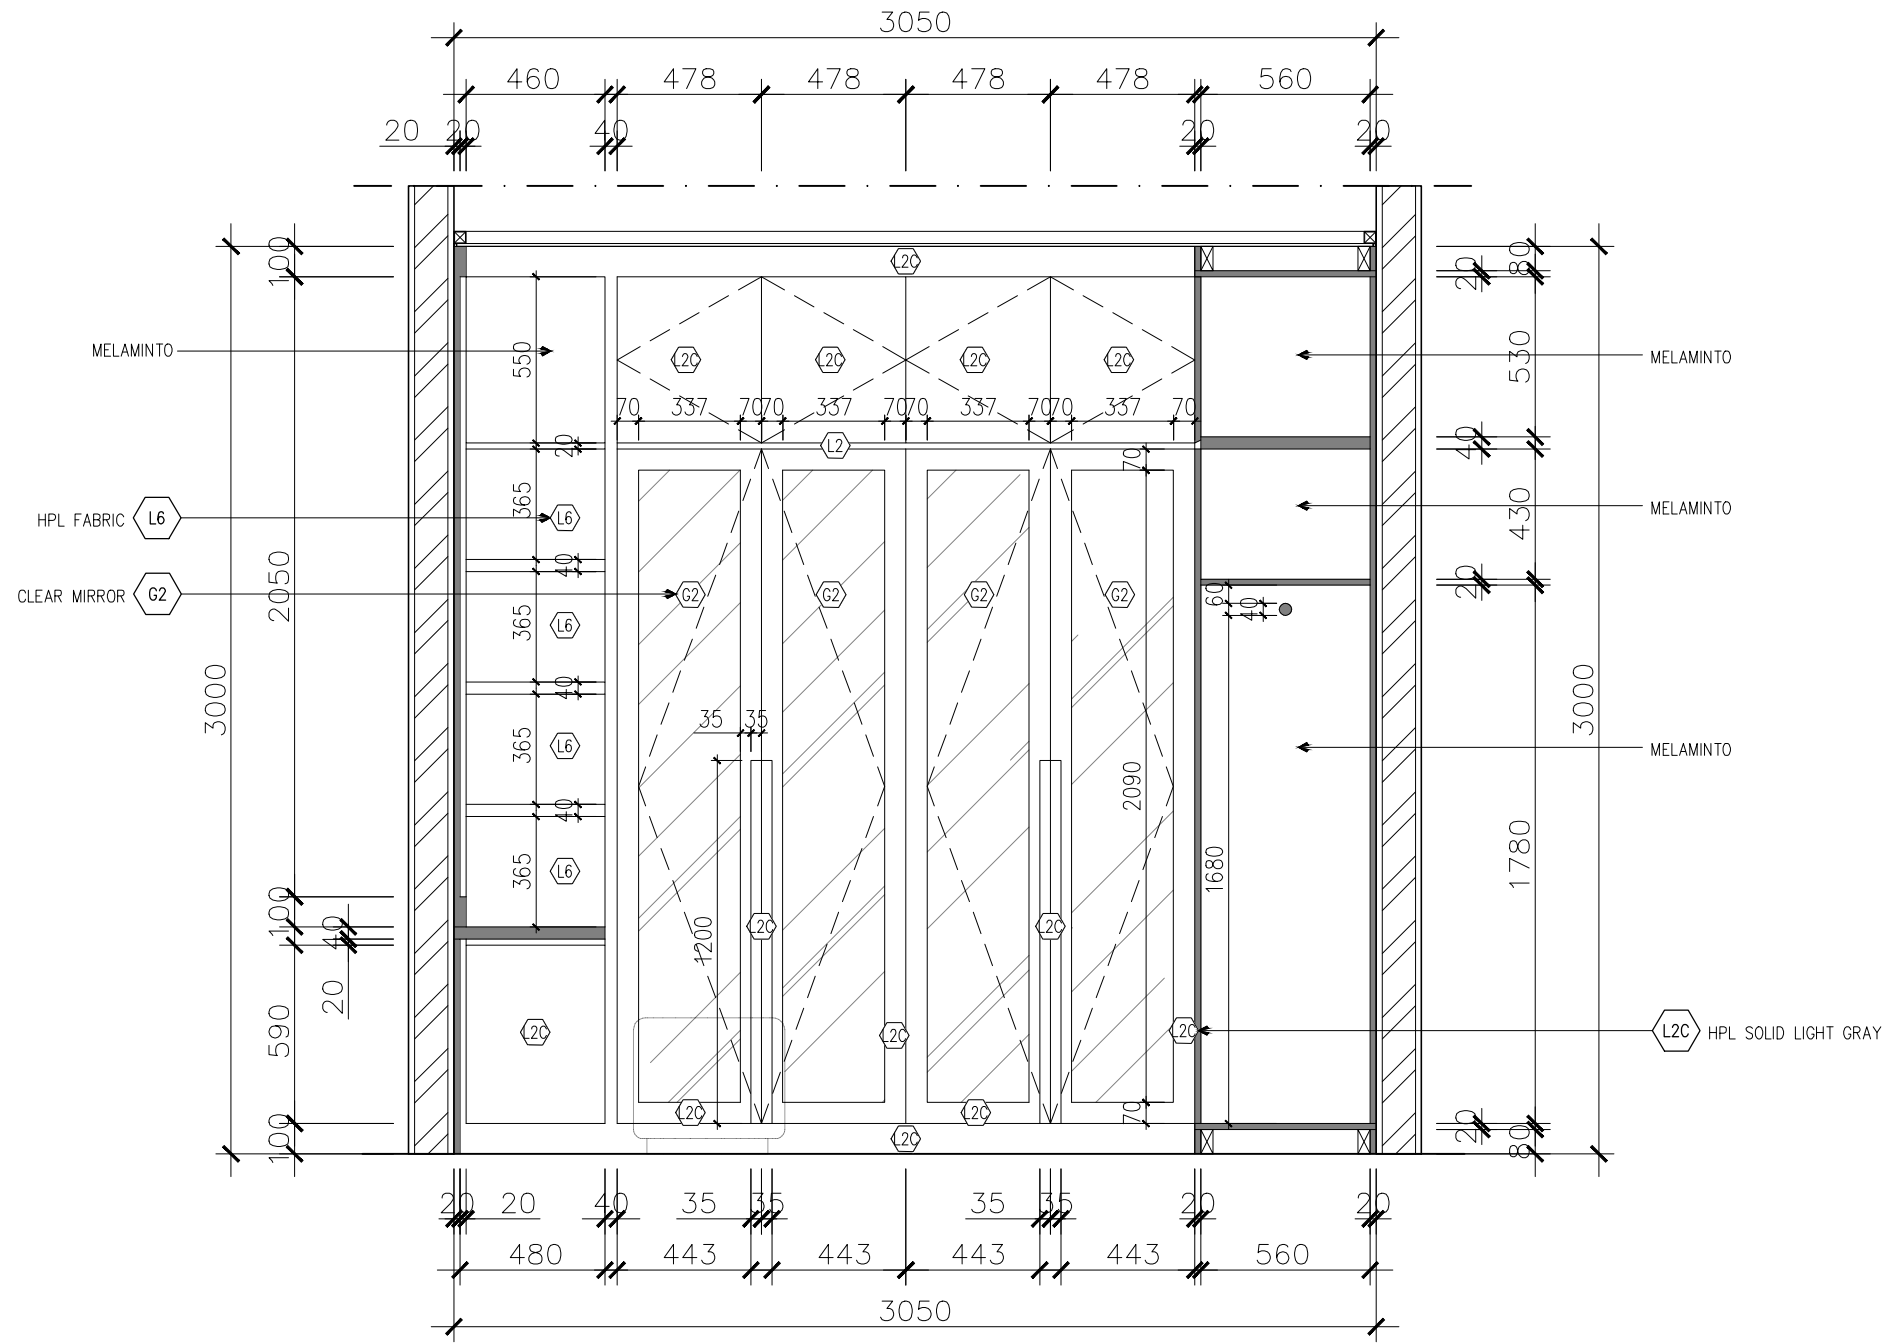

Section 6
Scale 1:25

CONTRACTOR :
Vivaldy Residence
 Summarecon Serpong, Tangerang

DRAWING TITLE :
Section 6 Walk in Closet

DATE ON : 21/11/2025	SCALE : 1 : 25	DRAWN : Linda Watiyul L. S.	UNIT : mm	JOB NO : 51	CHECKED BY : Jessica O.	APPROVED BY : Jessica O.
-------------------------	-------------------	--------------------------------	--------------	----------------	----------------------------	-----------------------------

SHEET NO : WC1	DRAWING NO : 07
-------------------	--------------------



DUENDE
design + build

Serpong Utara, Tangerang Selatan
+62812 8603 4050
duende.designandbuild@gmail.com

CLIENT :

Mrs. S

CONTRACTOR :

PROJECT :


Vivaldy Residence

LOCATION :

Summarecon Serpong, Tangerang

DRAWING TITLE :

Section 7 Walk in Closet

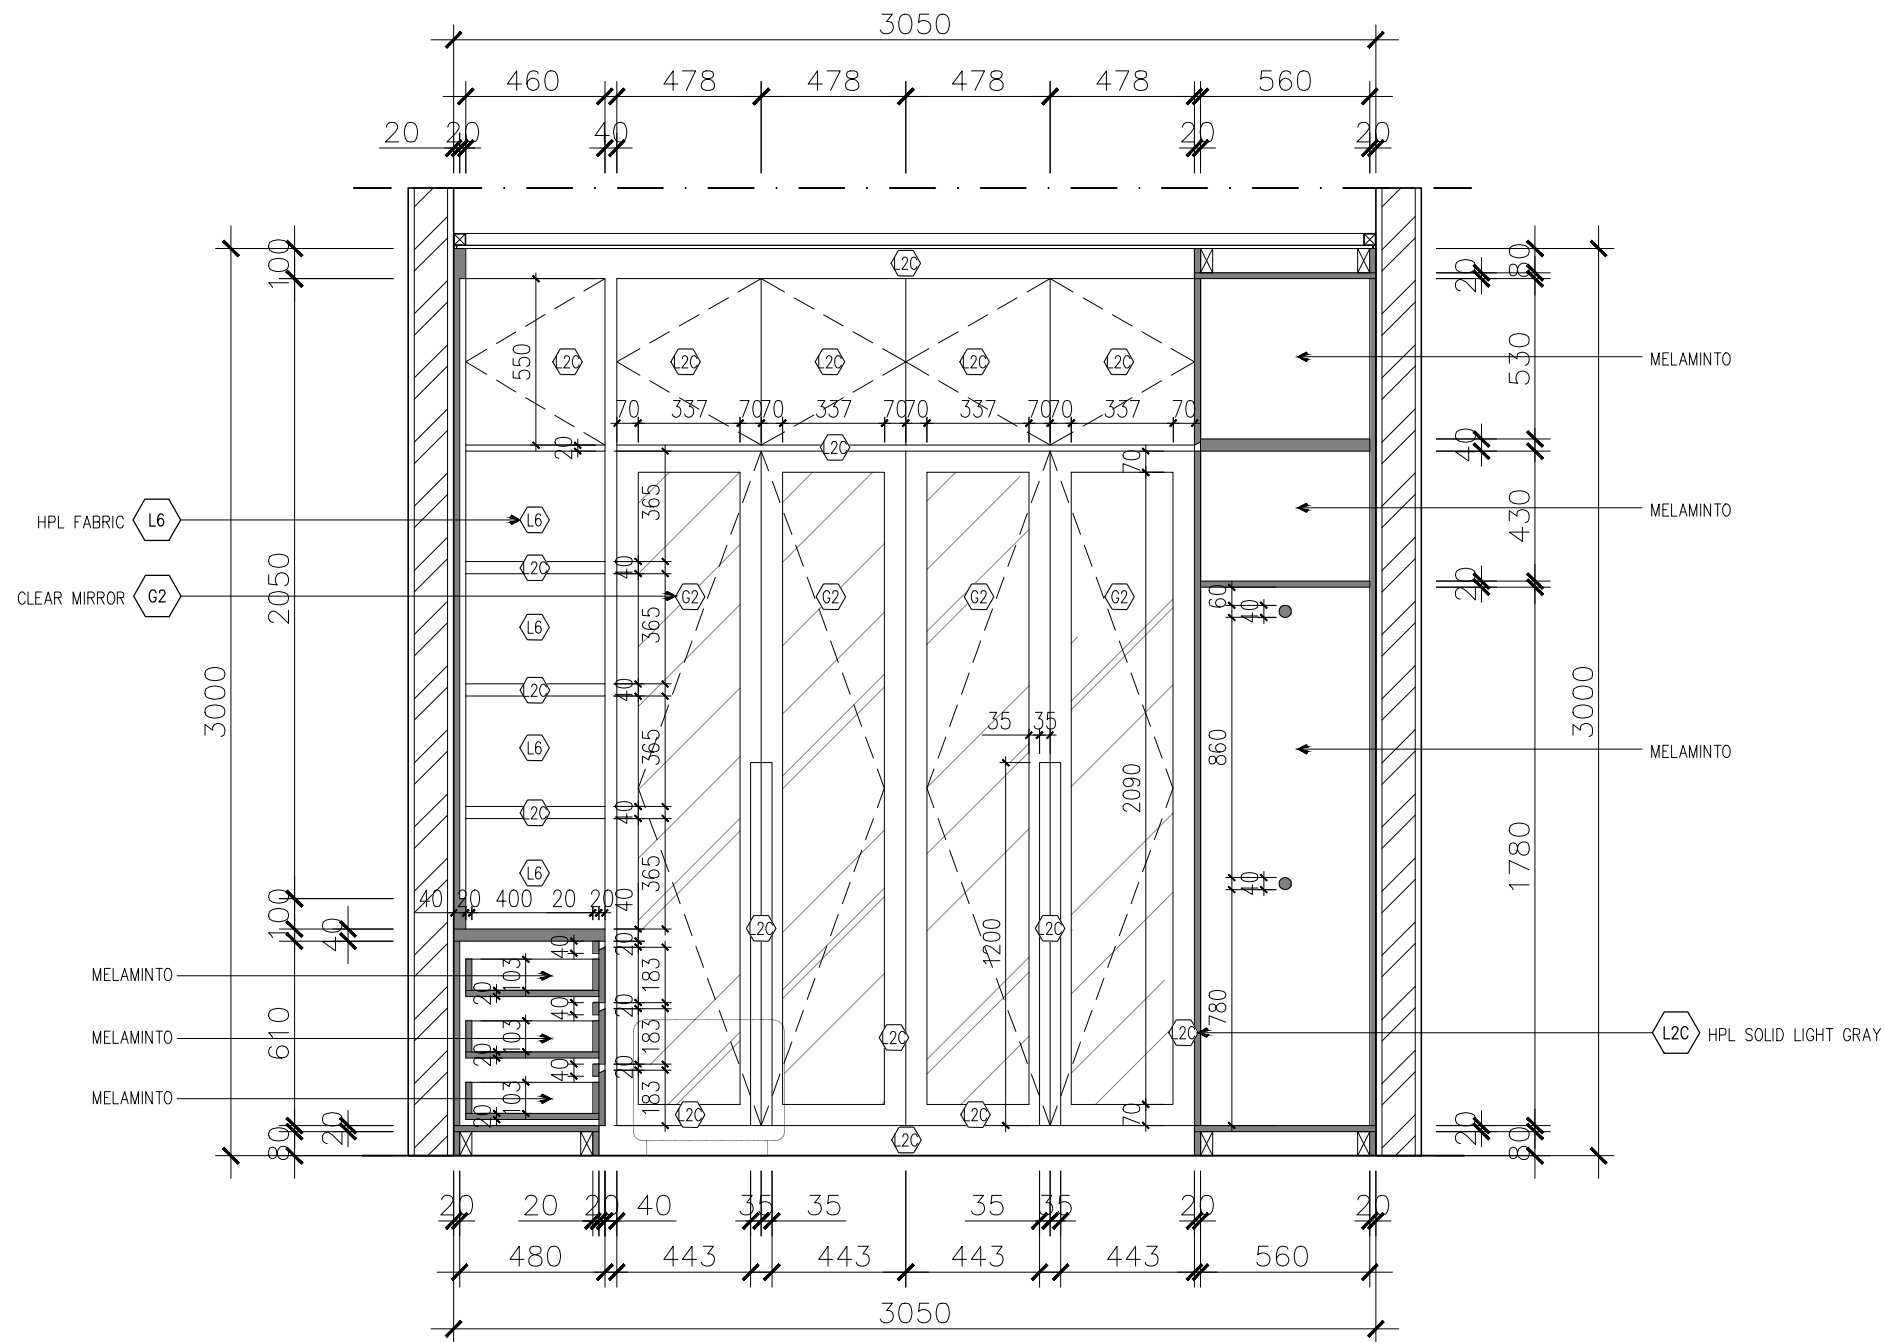

Section 7
Scale 1:25

DATE ON :	21/11/2025	SCALE :	1 : 25
DRAWN :	Linda Walyu L. S.	UNIT :	mm
JOB NO :			51
CHECKED BY :	Jessica O.	APPROVED BY :	Jessica O.

SHEET NO :	WC1	DRAWING NO :	08
------------	-----	--------------	----

REV. NO :



DUENDE
design + build

Serpong Utara, Tangerang Selatan
+62812 8603 4050
duende.designandbuild@gmail.com

CLIENT :

Mrs. S

CONTRACTOR :

PROJECT :


Vivaldy Residence

LOCATION :

Summarecon Serpong, Tangerang

DRAWING TITLE :

Section 8 Walk in Closet

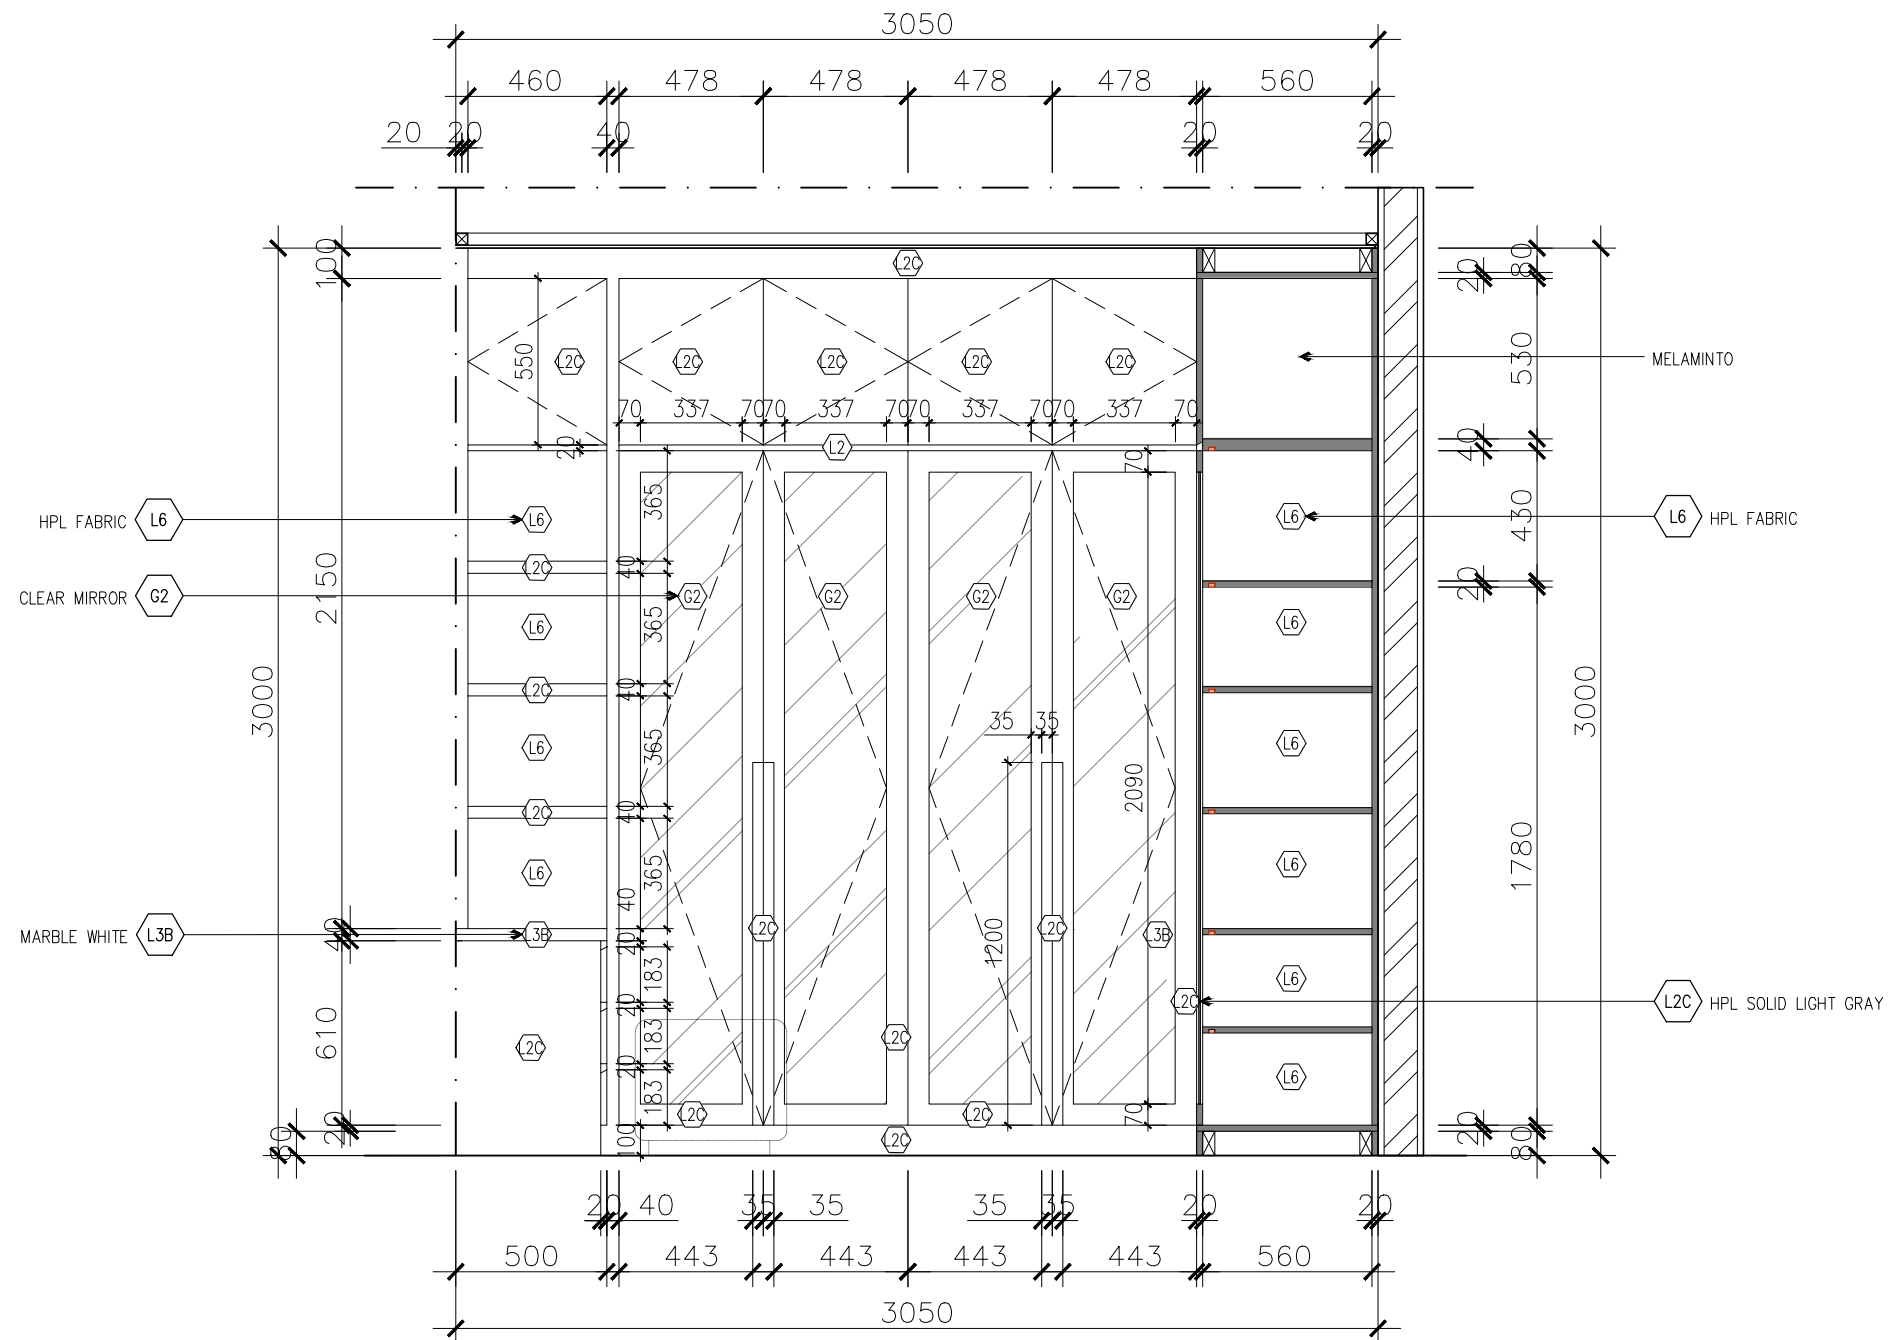

Section 8
Scale 1:25

DATE ON :	21/11/2025	SCALE :	1 : 25
DRAWN :	Linda Walyu L. S.	UNIT :	mm
JOB NO :			51
CHECKED BY :	Jessica O.	APPROVED BY :	Jessica O.

SHEET NO :	DRAWING NO :
WC1	09

REV. NO :